

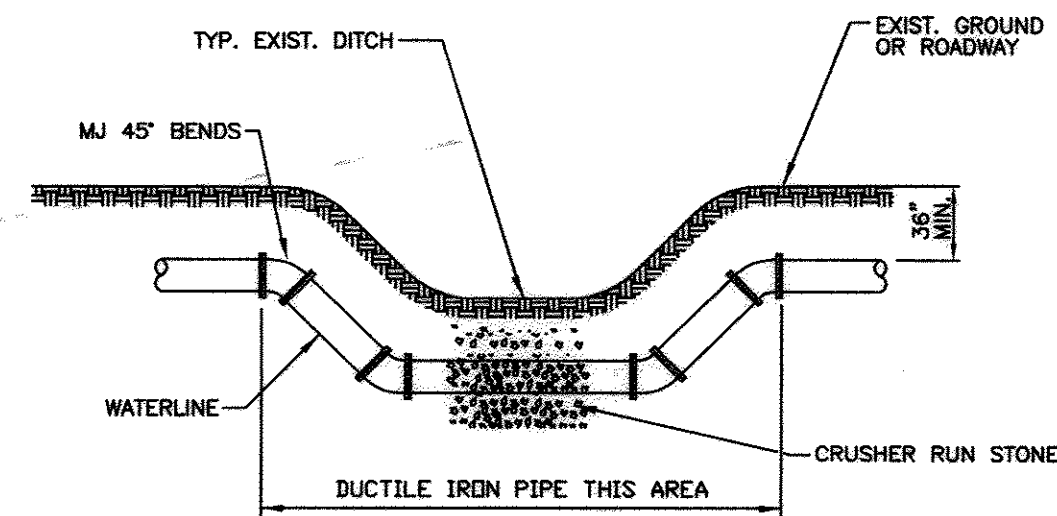
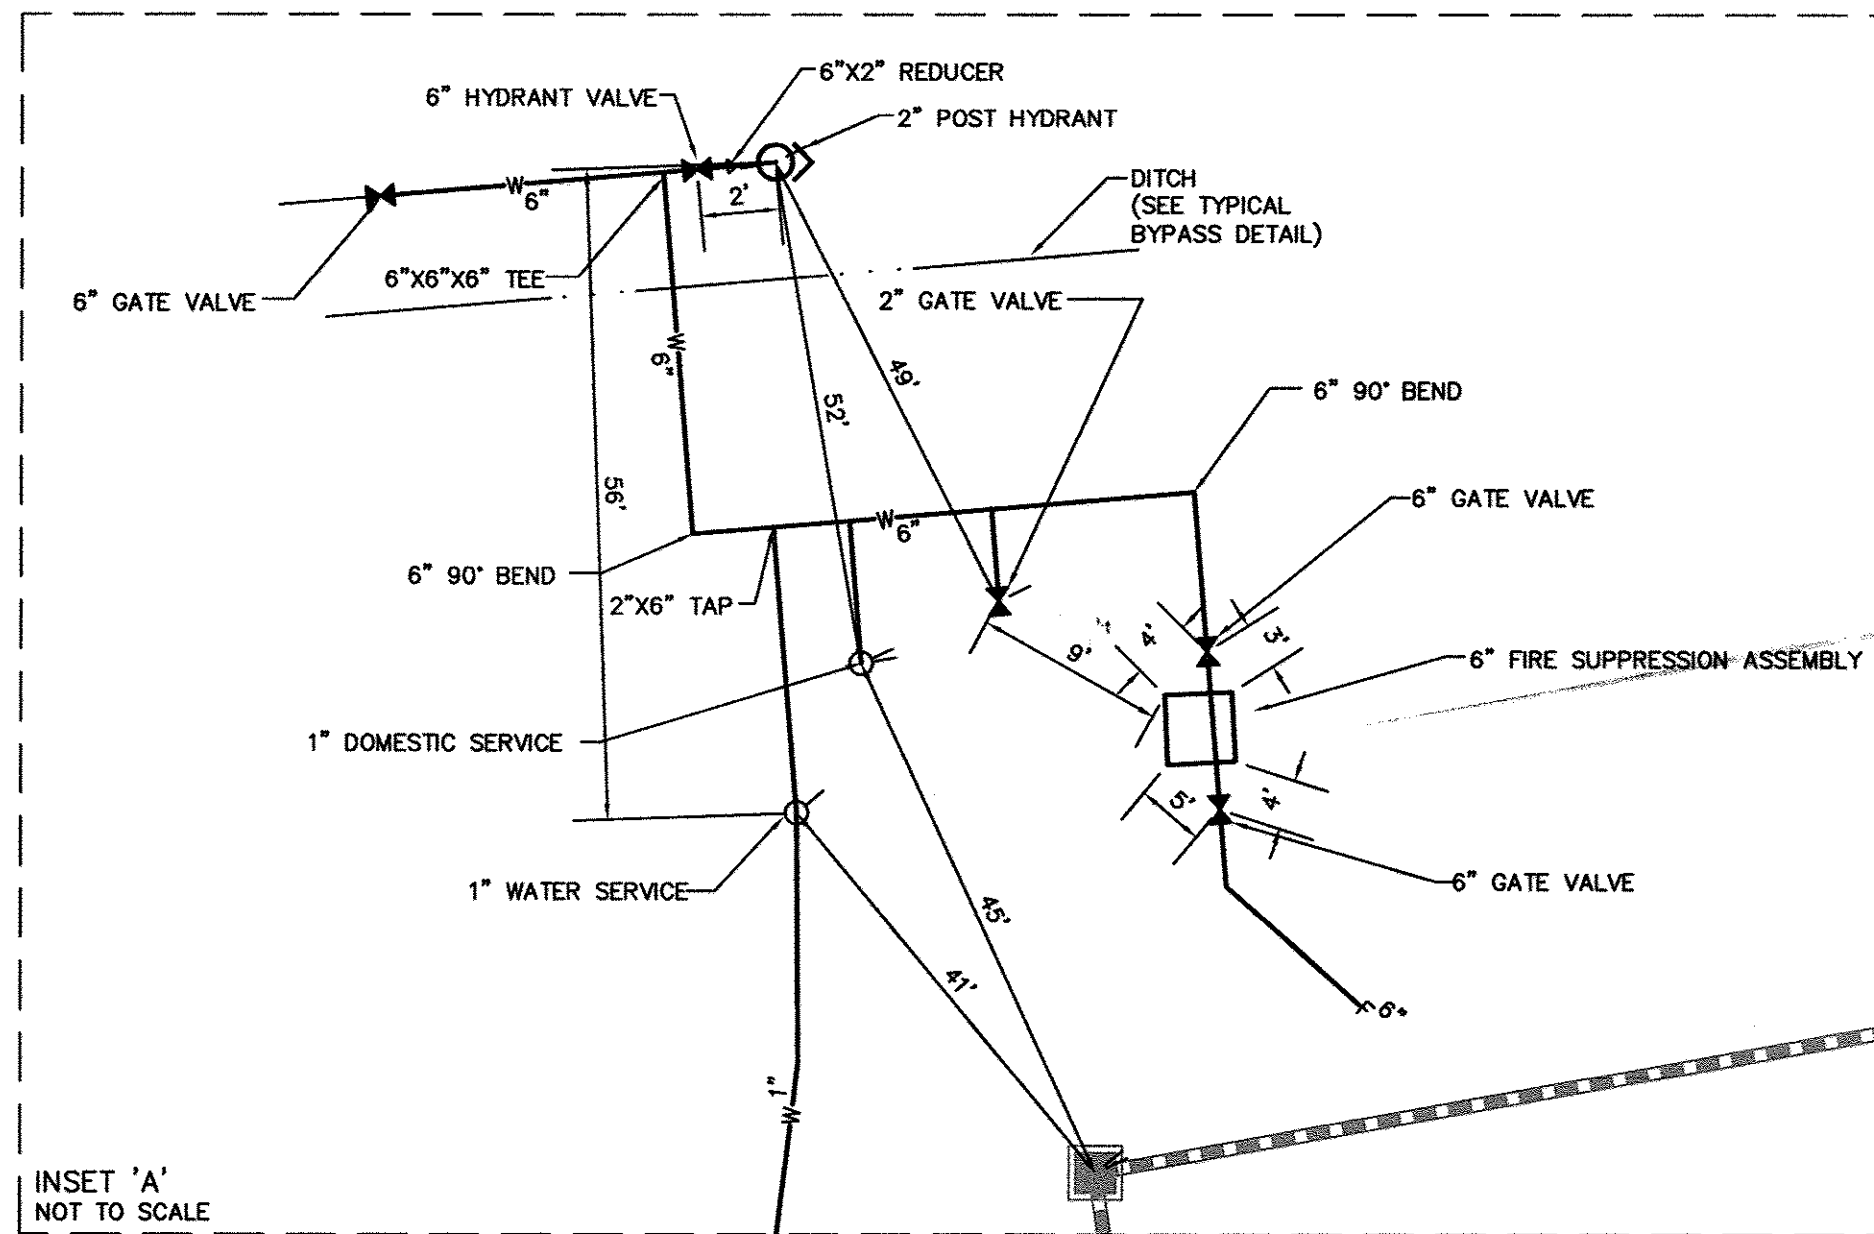
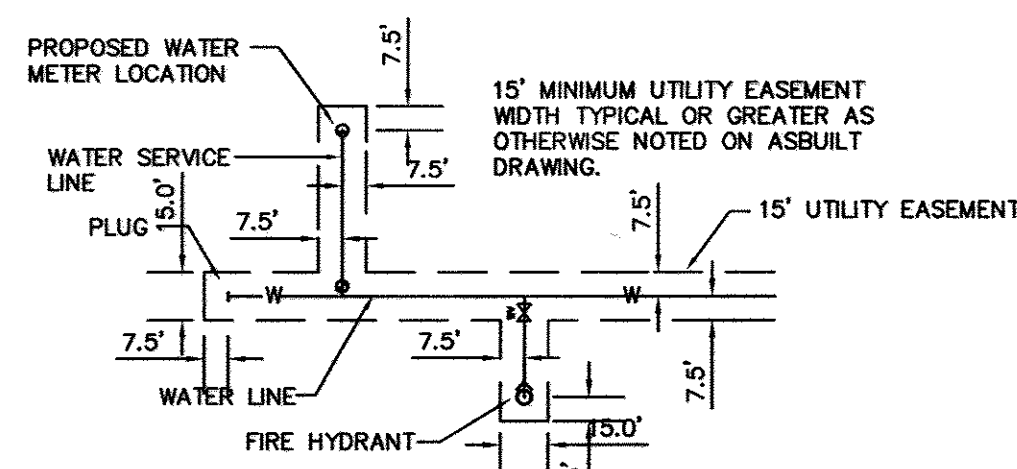


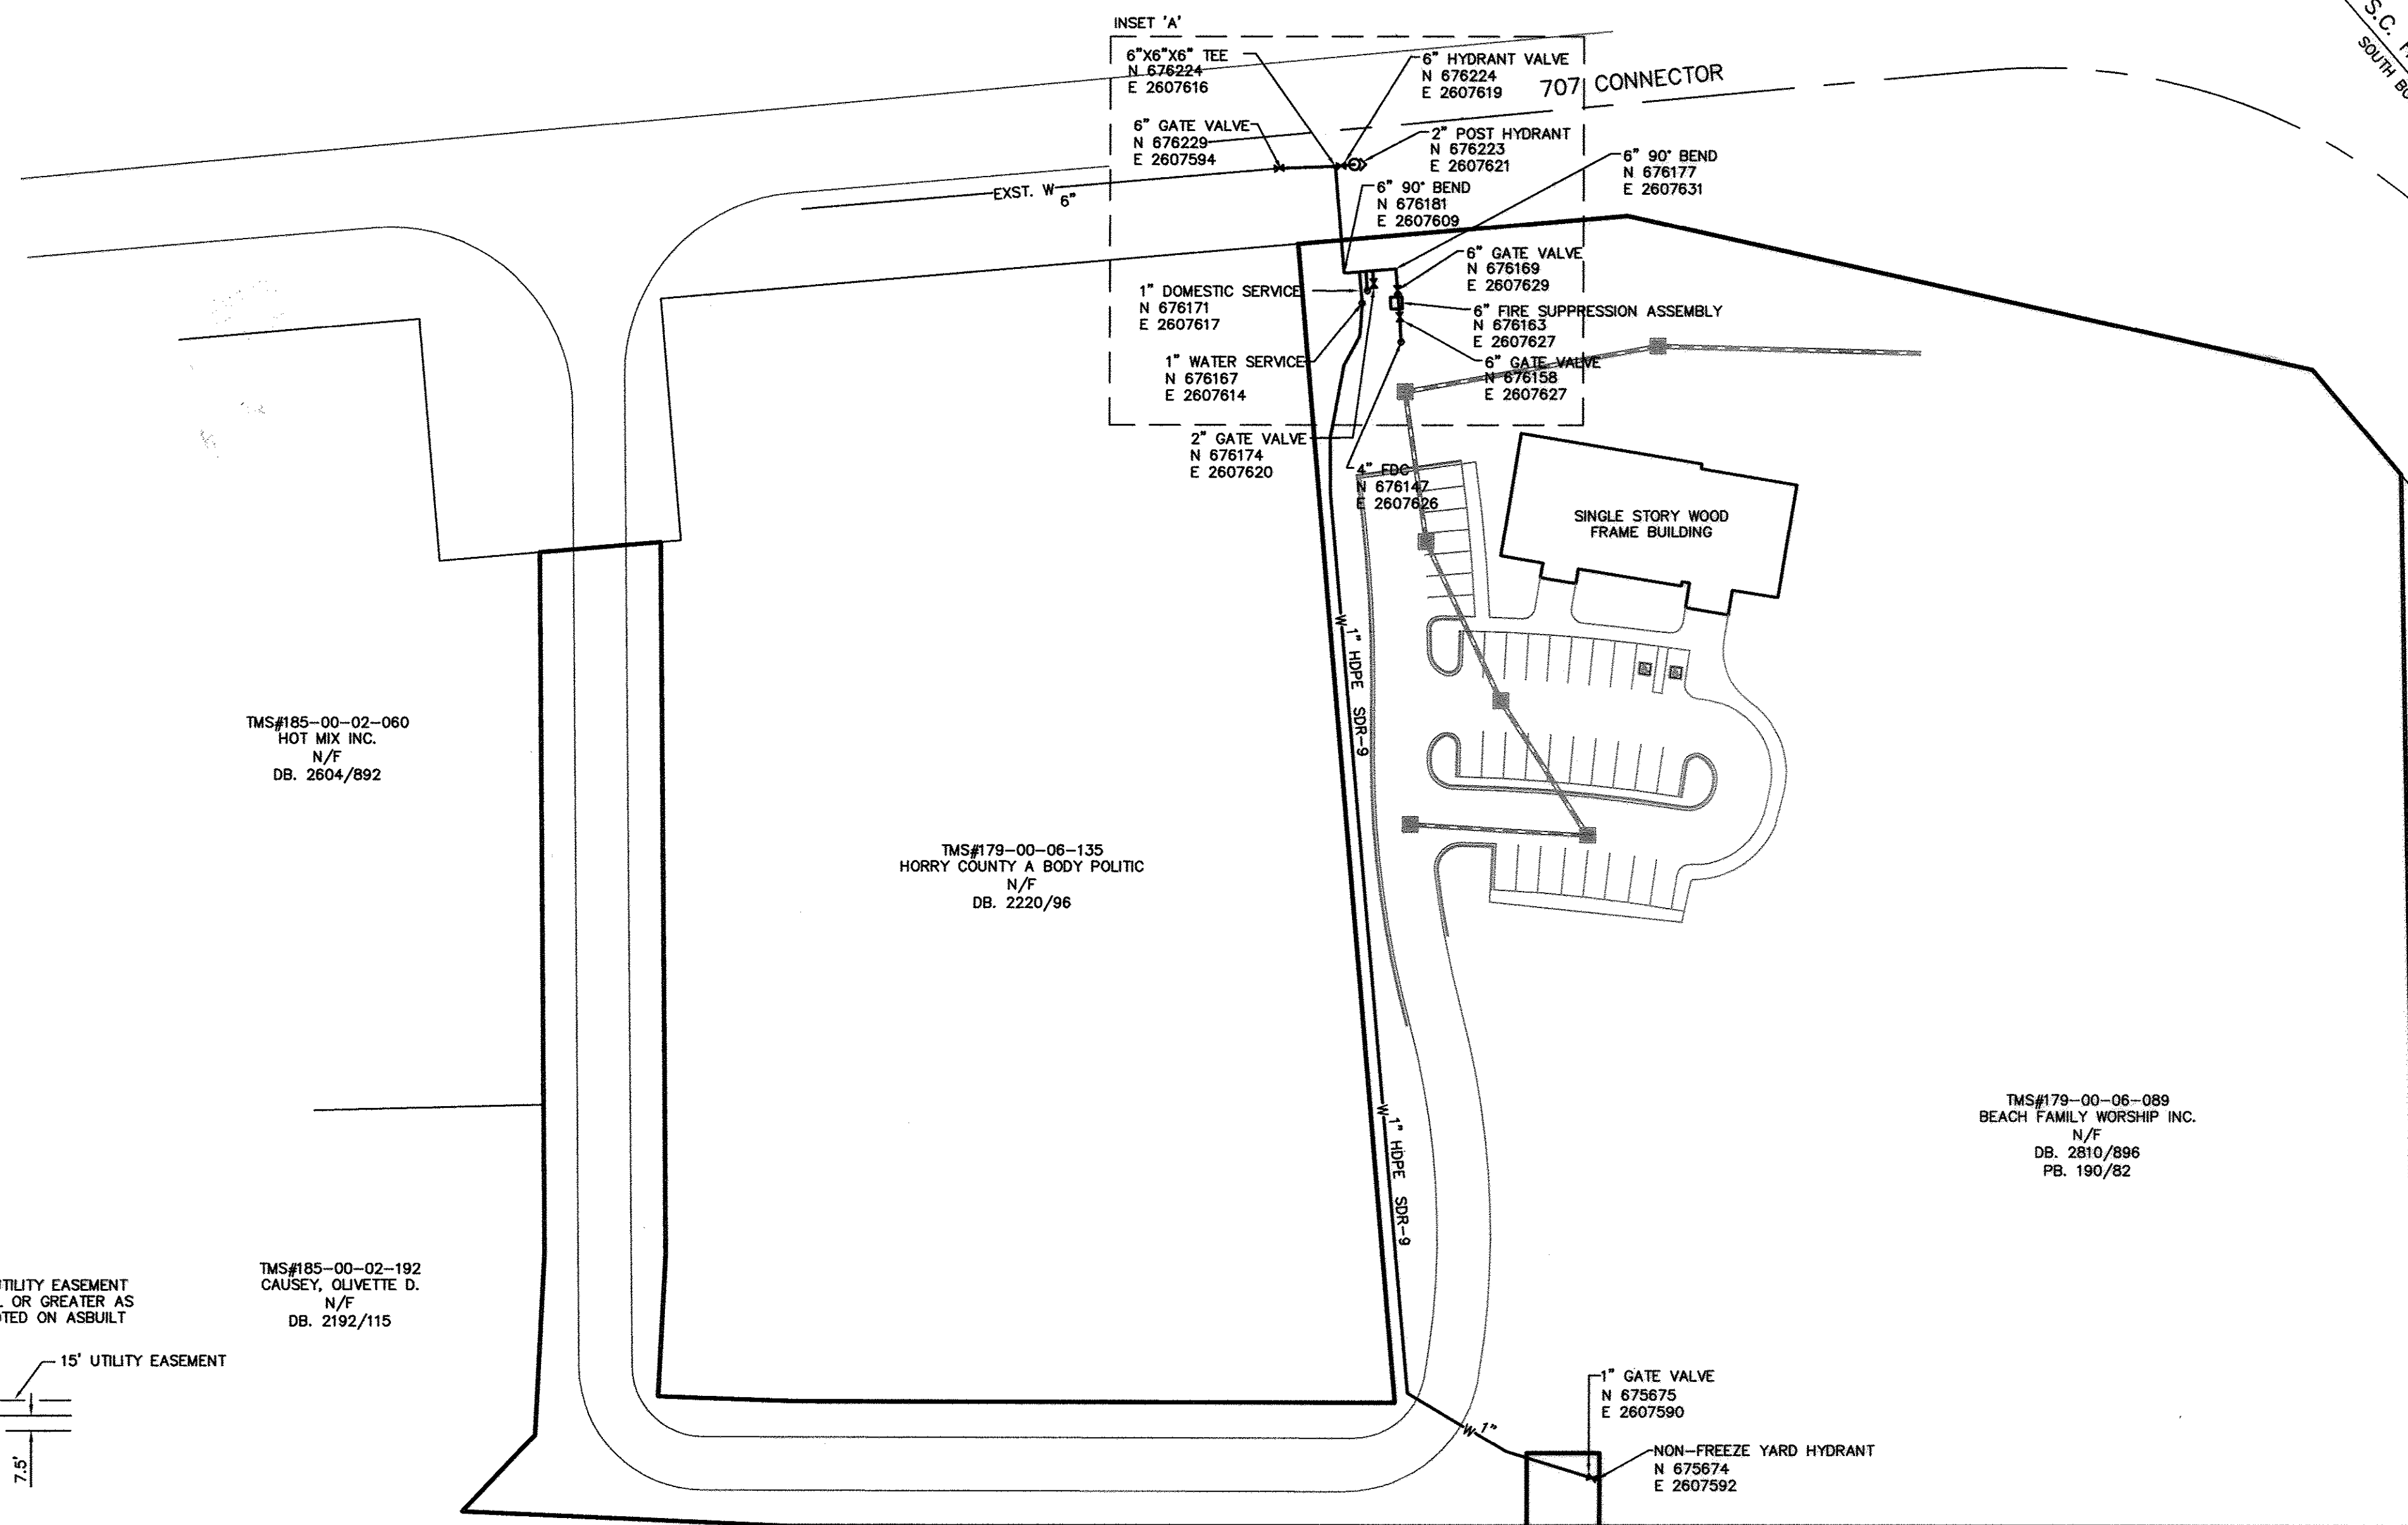

TYPICAL BYPASS DETAIL

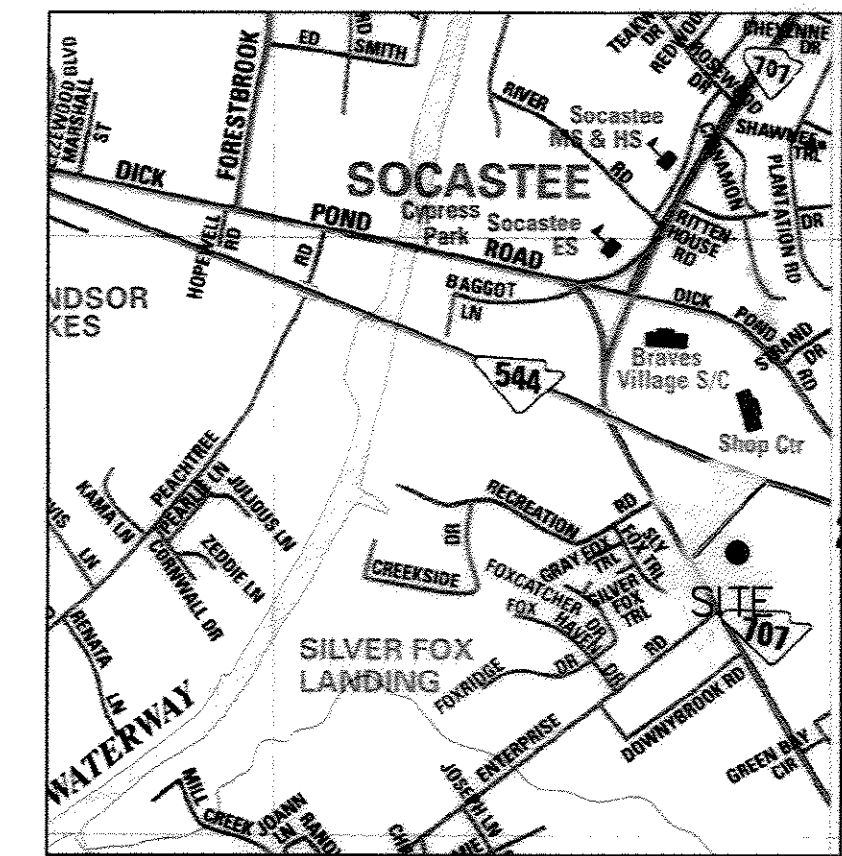

SODHEC CONSTRUCTION PERMITS:
WATER 25934-WS ISSUED JUNE 13, 2008
WASTEWATER 35192-WW ISSUED JUNE 13, 2008

APPROVED DATE NOV 24 2008
GRAND STRAND WATER & SEWER AUTHORITY
BY: *Michael A. Robinson*

WATER SYSTEM NOTES

1. PARCEL IS HORRY COUNTY TMS# 179-00-06-089.
2. OWNER IS: BEACH FAMILY WORSHIP INC.
3849 DICK POND ROAD
MYRTLE BEACH, S.C. 29588
(843) 215-7895
4. UTILITY CONTRACTOR IS: D&S SITEWORK INC.
4658 ELY TRAIL
MYRTLE BEACH, S.C. 29588
5. ENGINEER IS: DANIEL ENGINEERING, INC.
3338 KINGS RIVER ROAD
PAWLEYS ISLAND, S.C. 29958
(843) 235-6340

ENGINEER'S CERTIFICATION

I HEREBY CERTIFY THAT THE WATER UTILITIES SHOWN HAVE BEEN INSTALLED IN ACCORDANCE WITH THE APPROVED CONSTRUCTION DRAWINGS AND SPECIFICATIONS AND ARE, TO THE BEST OF MY KNOWLEDGE, AS SHOWN ON THESE PLANS.

HERBERT CRAIG DANIEL
DANIEL ENGINEERING, INC.


REGISTRATION NUMBER

SURVEYOR'S CERTIFICATION:

I HEREBY CERTIFY THAT THE INFORMATION SHOWN HEREON WAS OBTAINED FROM A FIELD SURVEY PERFORMED UNDER MY SUPERVISION AND IS, TO THE BEST OF MY KNOWLEDGE, INFORMATION AND BELIEF, CORRECT.

JEFFREY D. SOLAN, PE, PLS
SOLAN ASSOCIATES, P.C.

11-14-08
DATE

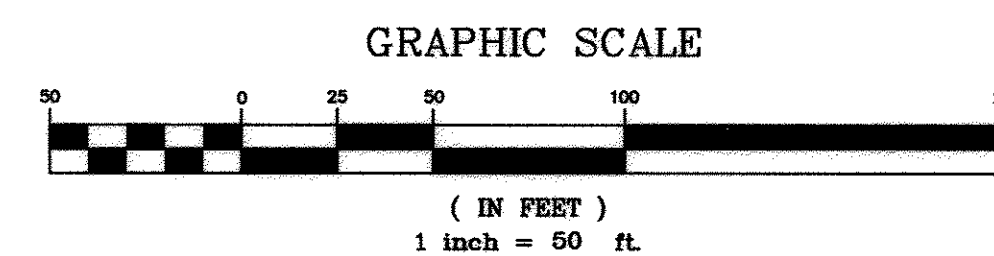

TMS#185-00-02-070
ERMAC PROPERTIES, LLC.
N/F
DB. 3279/158

TMS#185-00-02-060
HOT MIX INC.
N/F
DB. 2604/892

TMS#179-00-06-135
HORRY COUNTY A BODY POLITIC
N/F
DB. 2220/96



TMS#179-00-06-089
BEACH FAMILY WORSHIP INC.
N/F
DB. 2810/896
PB. 190/82

TMS#185-00-02-004
OWENS, CHARLES W.
N/F

TMS#185-00-02-192
CAUSEY, OLIVETTE D.
N/F
DB. 2192/115

SOLAN ASSOCIATES, P.C.
ENGINEERING, PLANNING & LAND SURVEYING
PO Box 870
Conway, SC 29528
Office: (843) 488-3400
Fax: (843) 488-3401

THIS DOCUMENT IS THE PROPERTY OF SOLAN ASSOCIATES, P.C., AND ALL COPYRIGHTS ARE RESERVED AS OF THE DATE SHOWN HEREON. COPIES OF THIS DOCUMENT WITHOUT ENGINEER'S/SURVEYOR'S SEAL AND SIGNATURE ARE INVALID.

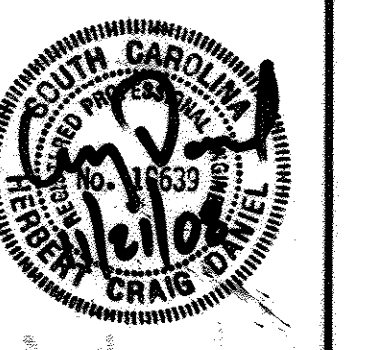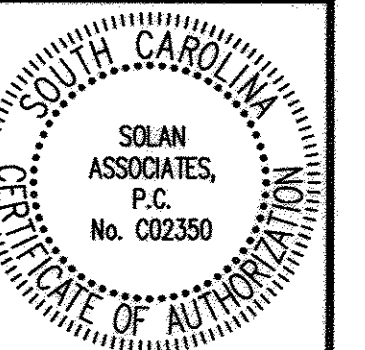


WATER SYSTEM RECORD DRAWING
BEACH FAMILY WORSHIP CENTER
TOWN OF SOCASTE
HORRY COUNTY, SOUTH CAROLINA
PREPARED FOR: BEACH FAMILY WORSHIP INC.

FILE NO. 08-033
SCALE As Noted
DATE 10-29-08
DRAWN BY NJP
CHECKED BY
DWG NO.

W1

SHEET 1 OF 3




14-361-001/3

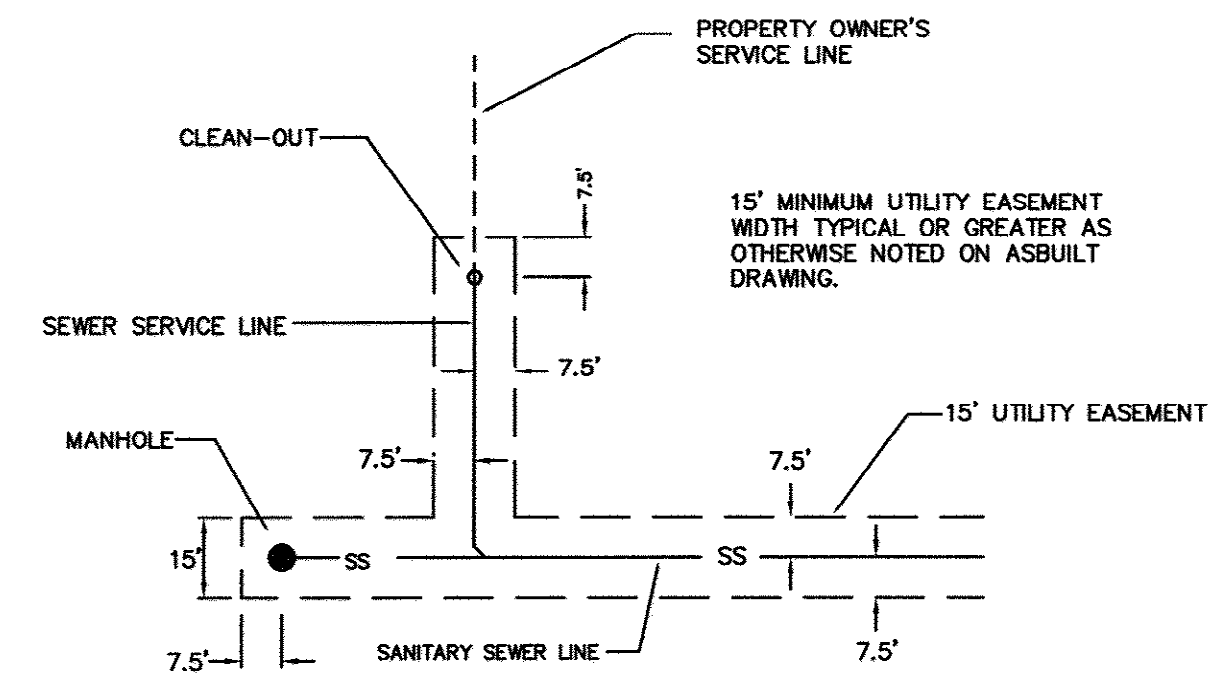


NOTE:
ALL WATER AND SEWER LINES INSTALLED AND TURNED OVER TO G.S.W.S.A. AS PART OF THIS PROJECT SHALL HAVE AN EASEMENT CENTERED OVER THE UTILITY LINE. THE WIDTH OF THE EASEMENT SHALL BE BASED ON A 1:1 SLOPE AS MEASURED FROM THE BOTTOM OF THE PIPE IN 5' INCREMENTS. FINISHED GRADE ELEVATION IS 15' MIN. EASEMENT WIDTH.

EASEMENT CHART:	EASEMENT WIDTH
UTILITY DEPTH	
0'-7.5'	15'
7.5'-10'	20'
10'-12.5'	25'
12.5'-15.0'	30'
15.0'-17.5'	35'
17.5'-20.0'	40'

GRAVITY SEWER EASEMENT TABLE
NOT TO SCALE

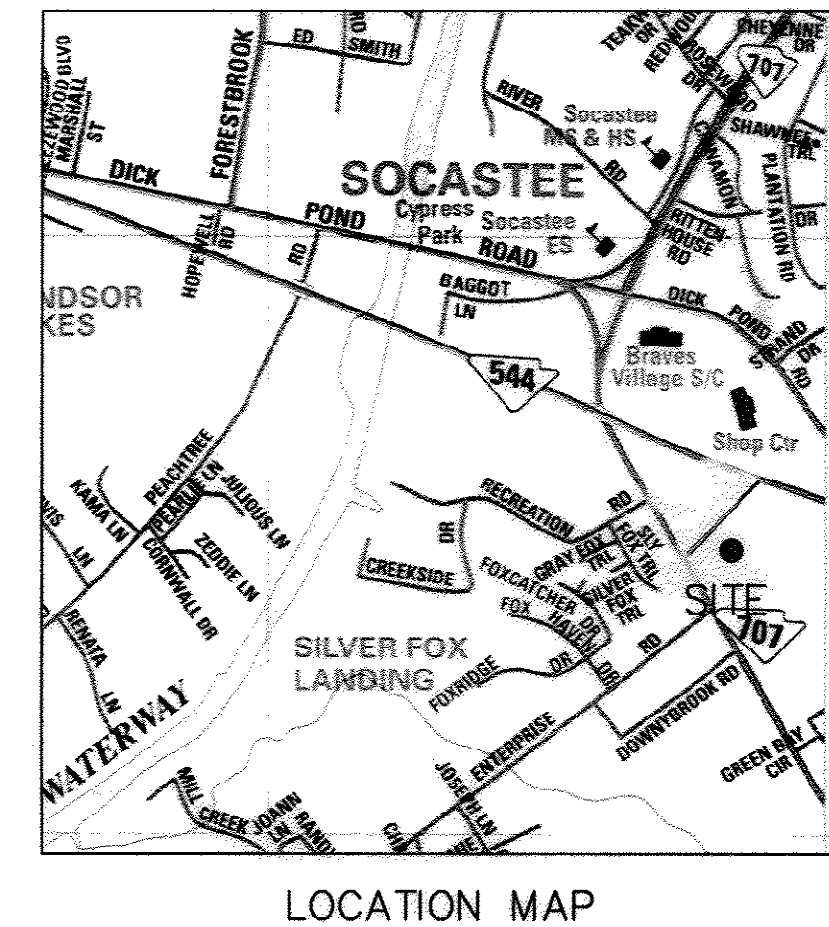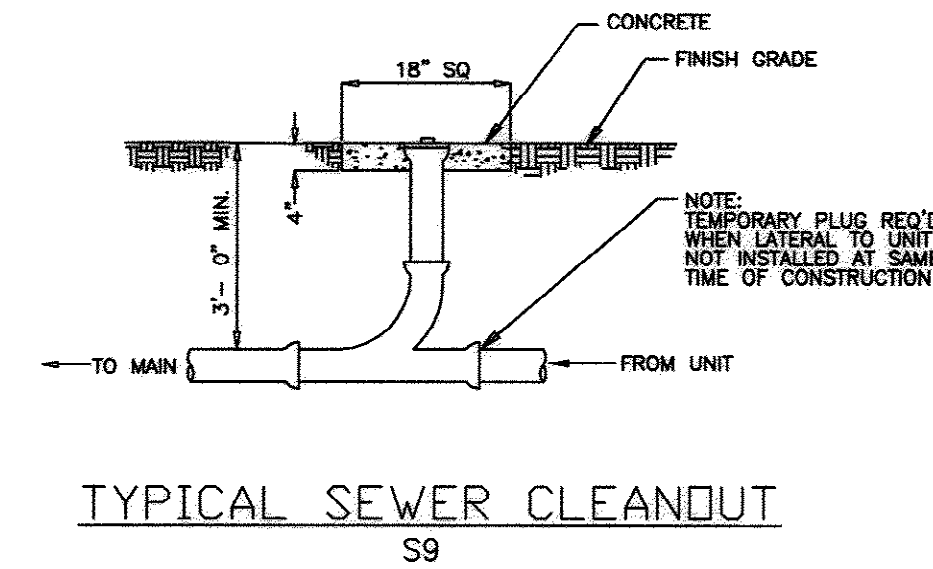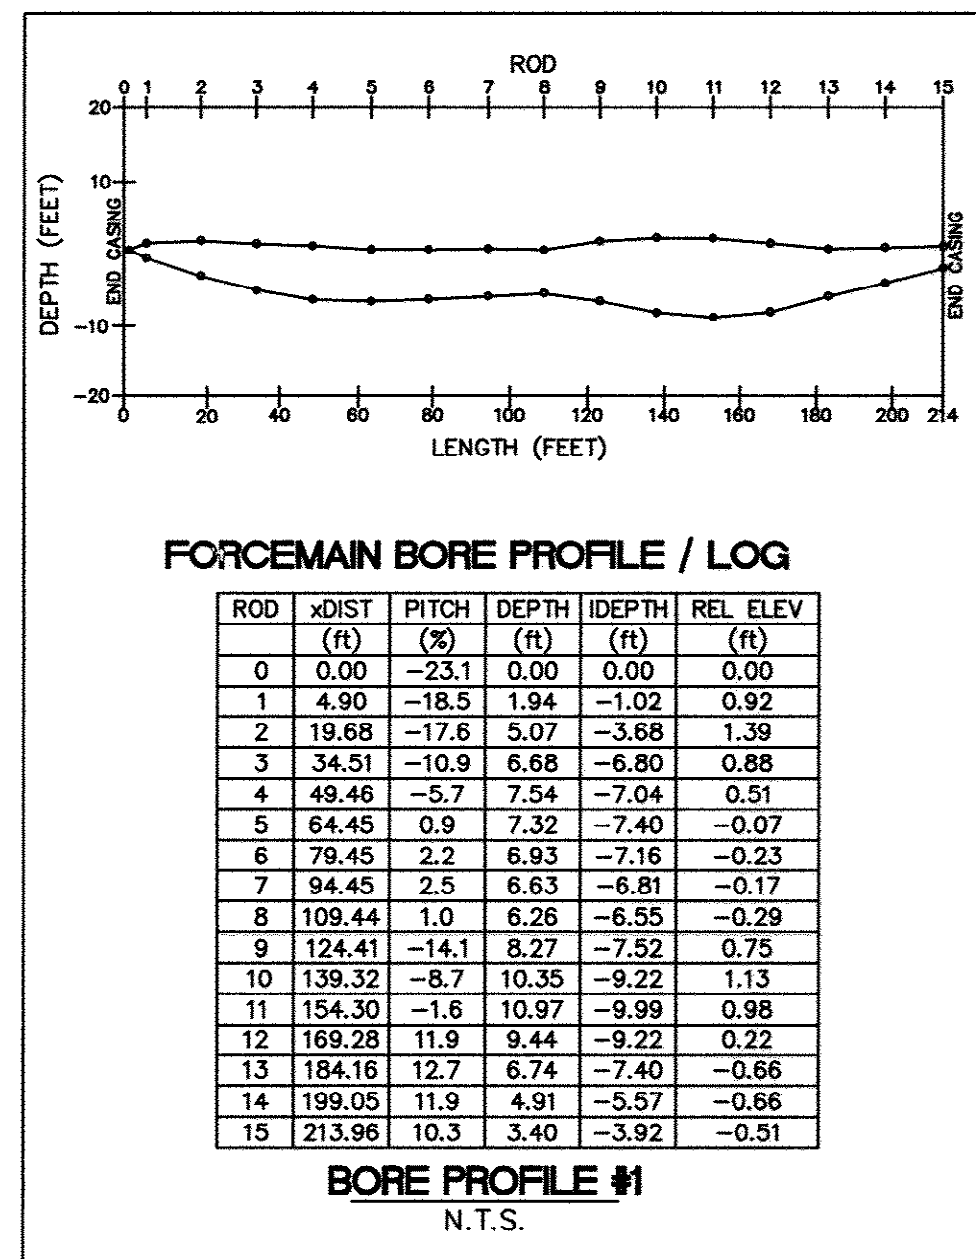

LOCATION MAP

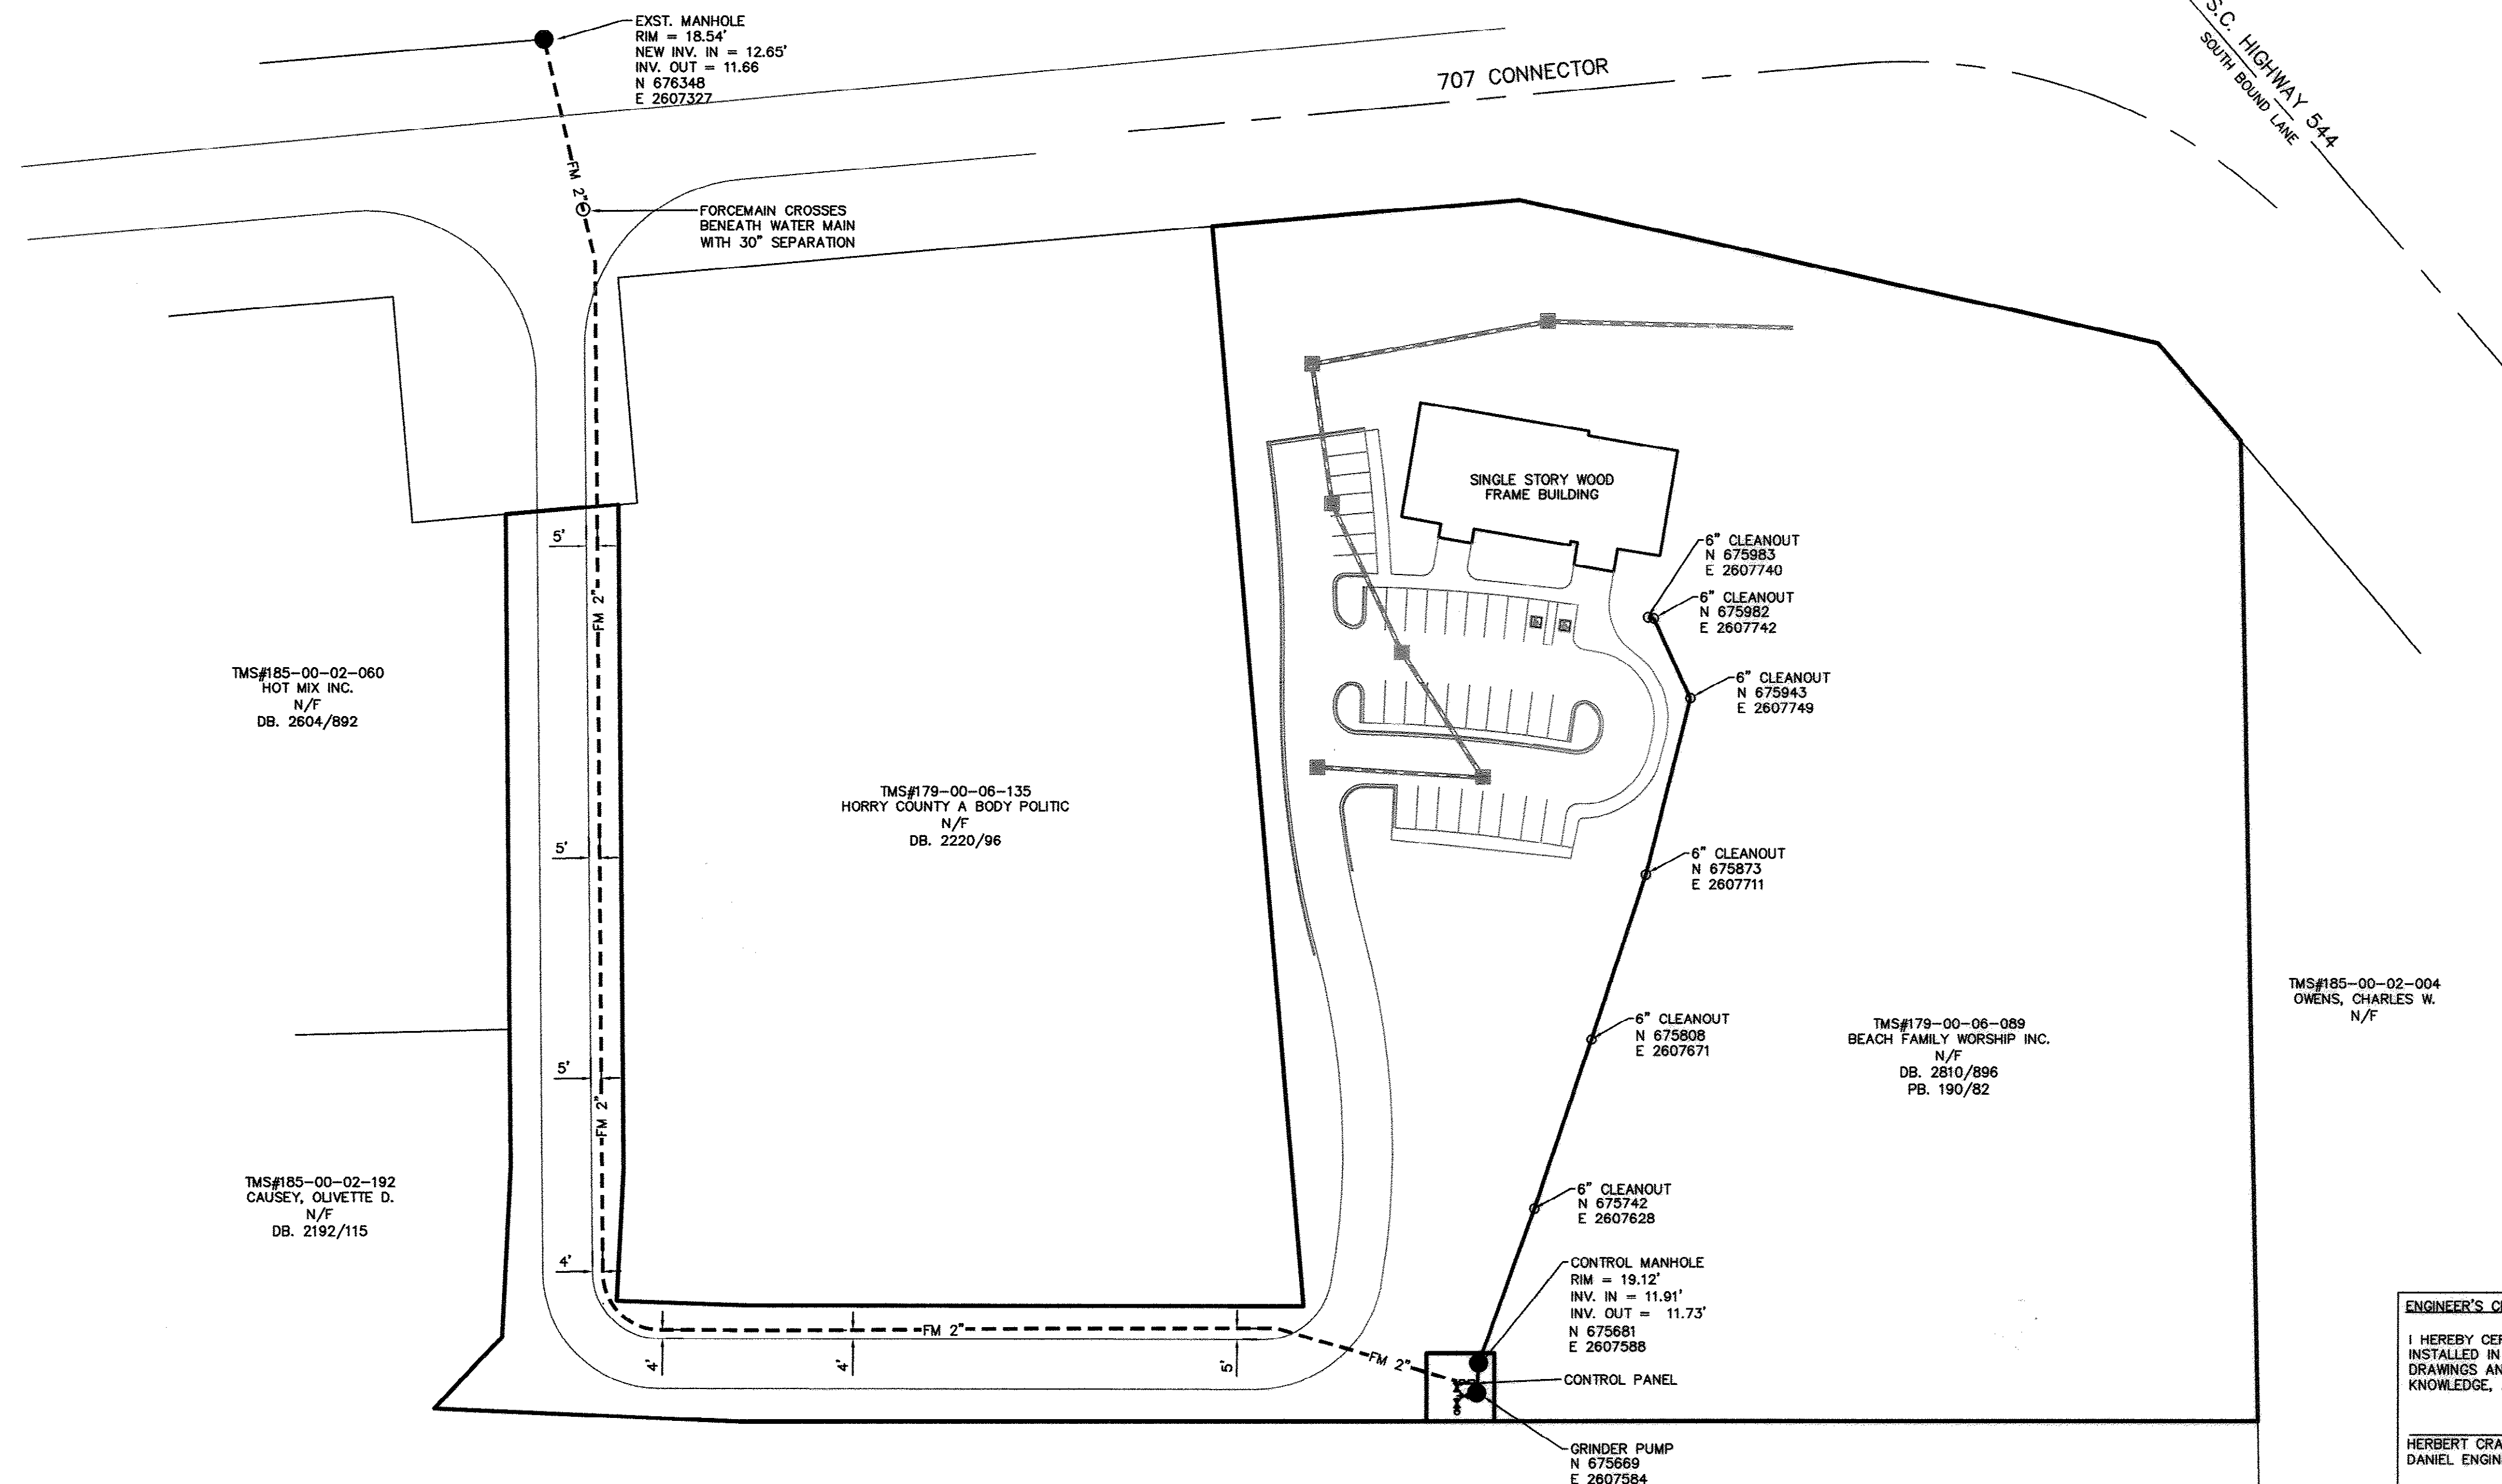

SODHEC CONSTRUCTION PERMITS:
WATER 25934-WS ISSUED JUNE 13, 2008
WASTEWATER 35192-WW ISSUED JUNE 13, 2008

APPROVED DATE **NOV 24 2003**
GRAND STRAND WATER & SEWER AUTHORITY
BY: *Michael A. Robinson*

SEWER SYSTEM NOTES

1. PARCEL IS HORRY COUNTY TMS# 179-00-06-089.
2. OWNER IS: BEACH FAMILY WORSHIP INC.
3949 DICK POND ROAD
MYRTLE BEACH, S.C. 29588
(843) 215-7895
3. UTILITY CONTRACTOR IS: D&S SITEWORK INC.
4658 ELY TRAIL
MYRTLE BEACH, S.C. 29588
4. ENGINEER IS: DANIEL ENGINEERING, INC.
3338 KINGS RIVER ROAD
PAWLEYS ISLAND, S.C. 29585
(843) 235-6340

ENGINEER'S CERTIFICATION

I HEREBY CERTIFY THAT THE SEWER UTILITIES SHOWN HAVE BEEN INSTALLED IN ACCORDANCE WITH THE APPROVED CONSTRUCTION DRAWINGS AND SPECIFICATIONS AND ARE, TO THE BEST OF MY KNOWLEDGE, AS SHOWN ON THESE PLANS.

HERBERT CRAIG DANIEL
DANIEL ENGINEERING, INC.


REGISTRATION NUMBER

SURVEYOR'S CERTIFICATION

I HEREBY CERTIFY THAT THE INFORMATION SHOWN HEREON WAS OBTAINED FROM A FIELD SURVEY PERFORMED UNDER MY SUPERVISION AND IS, TO THE BEST OF MY KNOWLEDGE, INFORMATION AND BELIEF, CORRECT.

JEFFREY D. SOLAN, P.E., PLS
SOLAN ASSOCIATES, P.C.

11-14-03
DATE

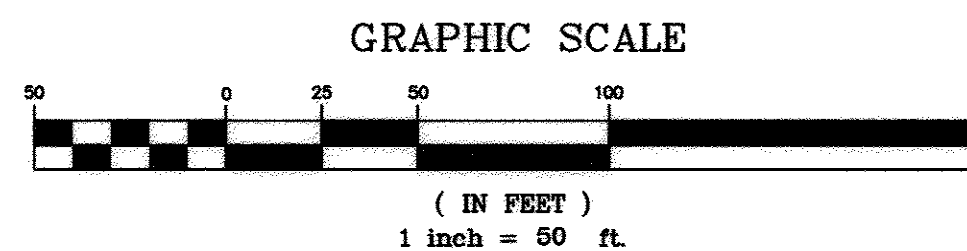

TMS#185-00-02-070
ERMAC PROPERTIES, LLC.
N/F
DB. 3279/158

SEWER SYSTEM RECORD DRAWING


BEACH FAMILY WORSHIP CENTER
TOWN OF SOCASTE
HORRY COUNTY, SOUTH CAROLINA
PREPARED FOR: BEACH FAMILY WORSHIP INC.

FILE NO. 08-033
SCALE As Noted
DATE 10-29-08
DRAWN BY NJP
CHECKED BY
DWG NO.



S1

SOLAN ASSOCIATES, P.C.
ENGINEERING, PLANNING & LAND SURVEYING
PO Box 870
Conway, SC 29528
Office: (843) 488-3400
Fax: (843) 488-3401


THIS DOCUMENT IS THE PROPERTY OF SOLAN ASSOCIATES, P.C., AND ALL COPYRIGHTS ARE RESERVED AS OF THE DATE SHOWN HEREON. COPIES OF THIS DOCUMENT WITHOUT ENGINEER'S/SURVEYOR'S SEAL AND SIGNATURE ARE INVALID.

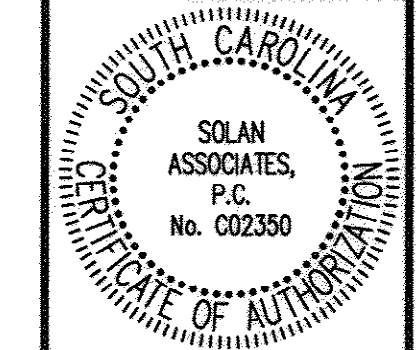


14-361-003/3 S

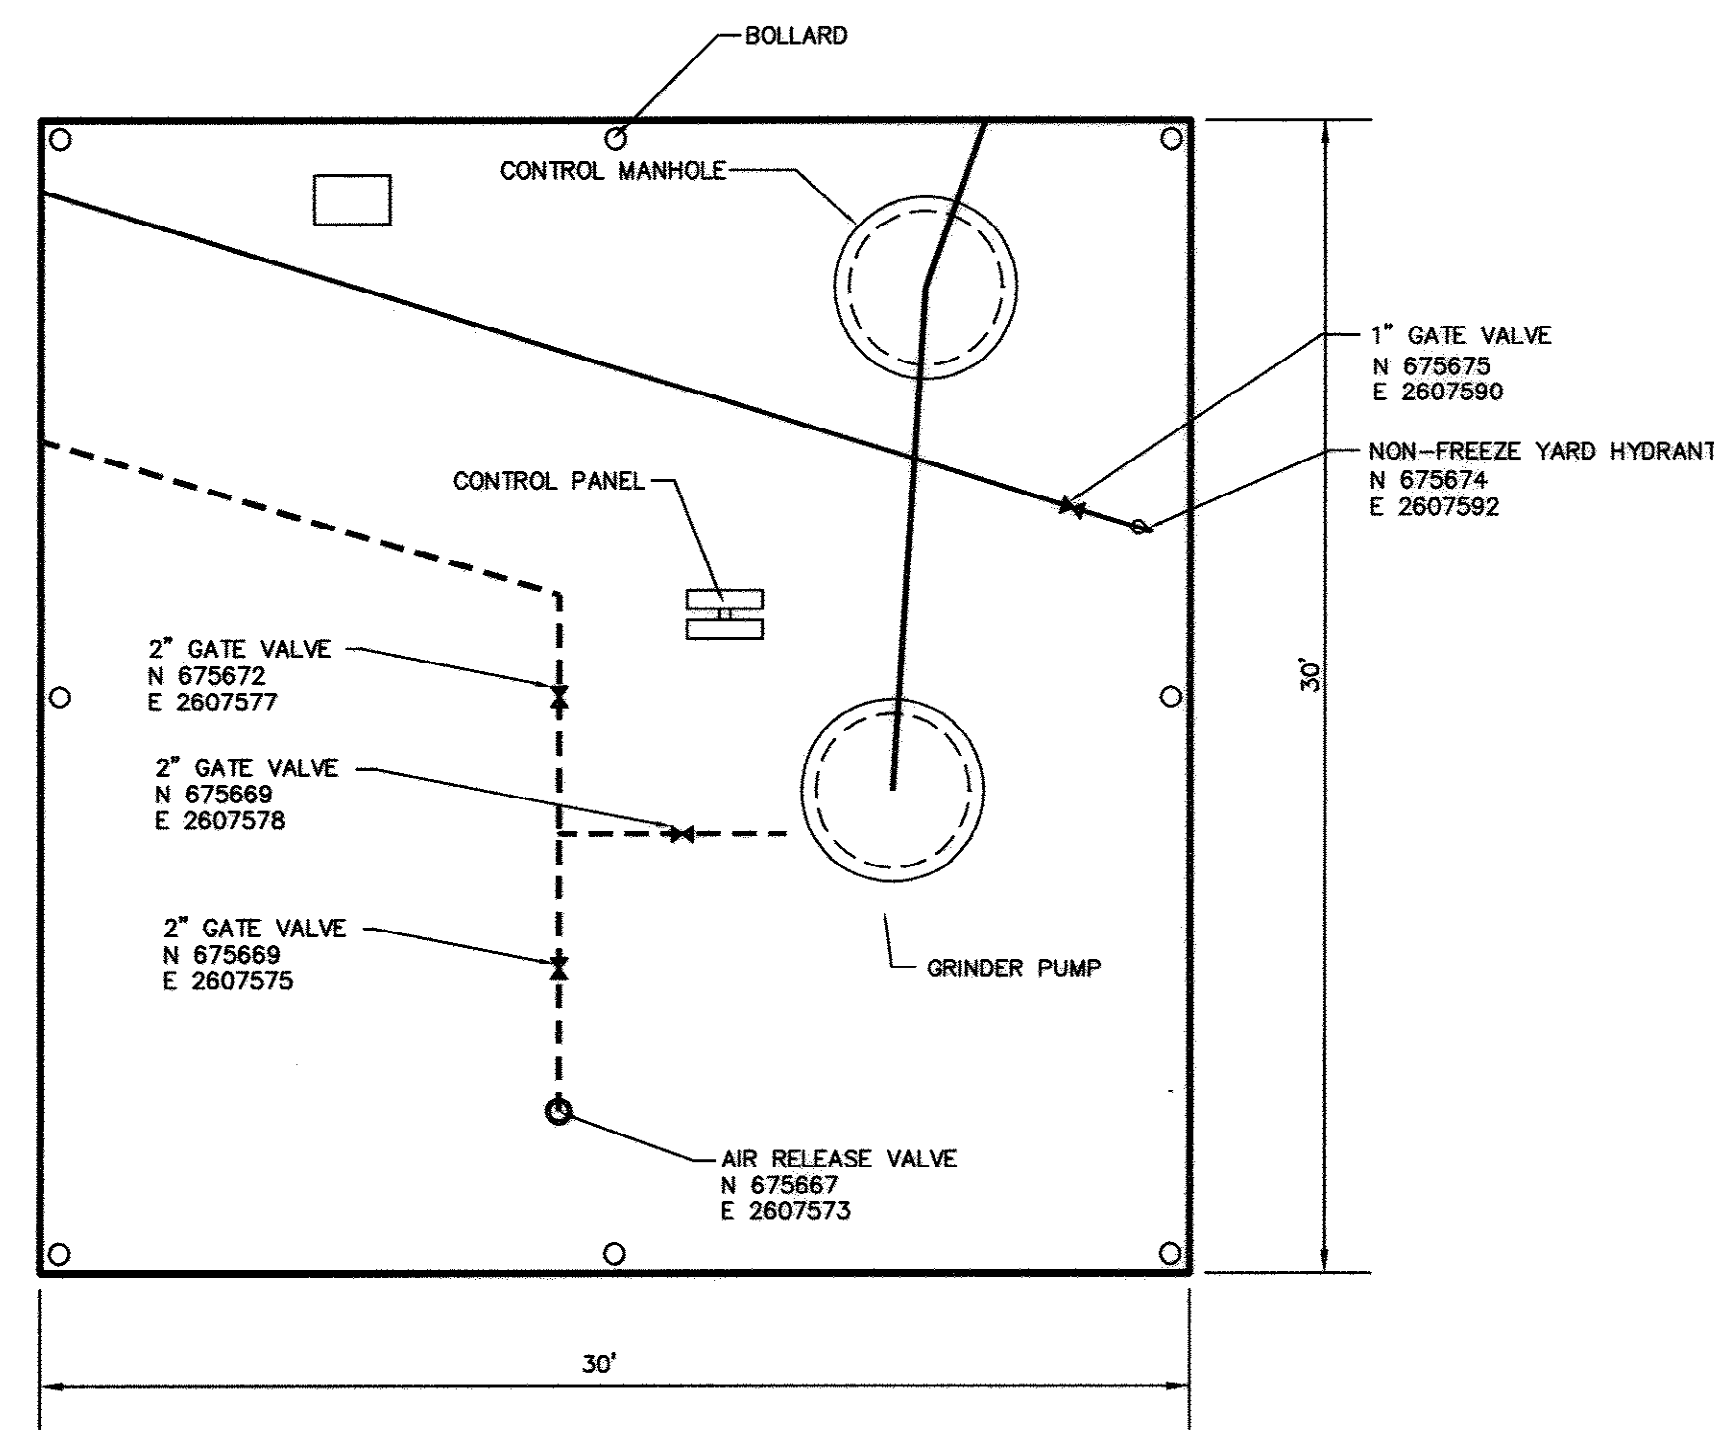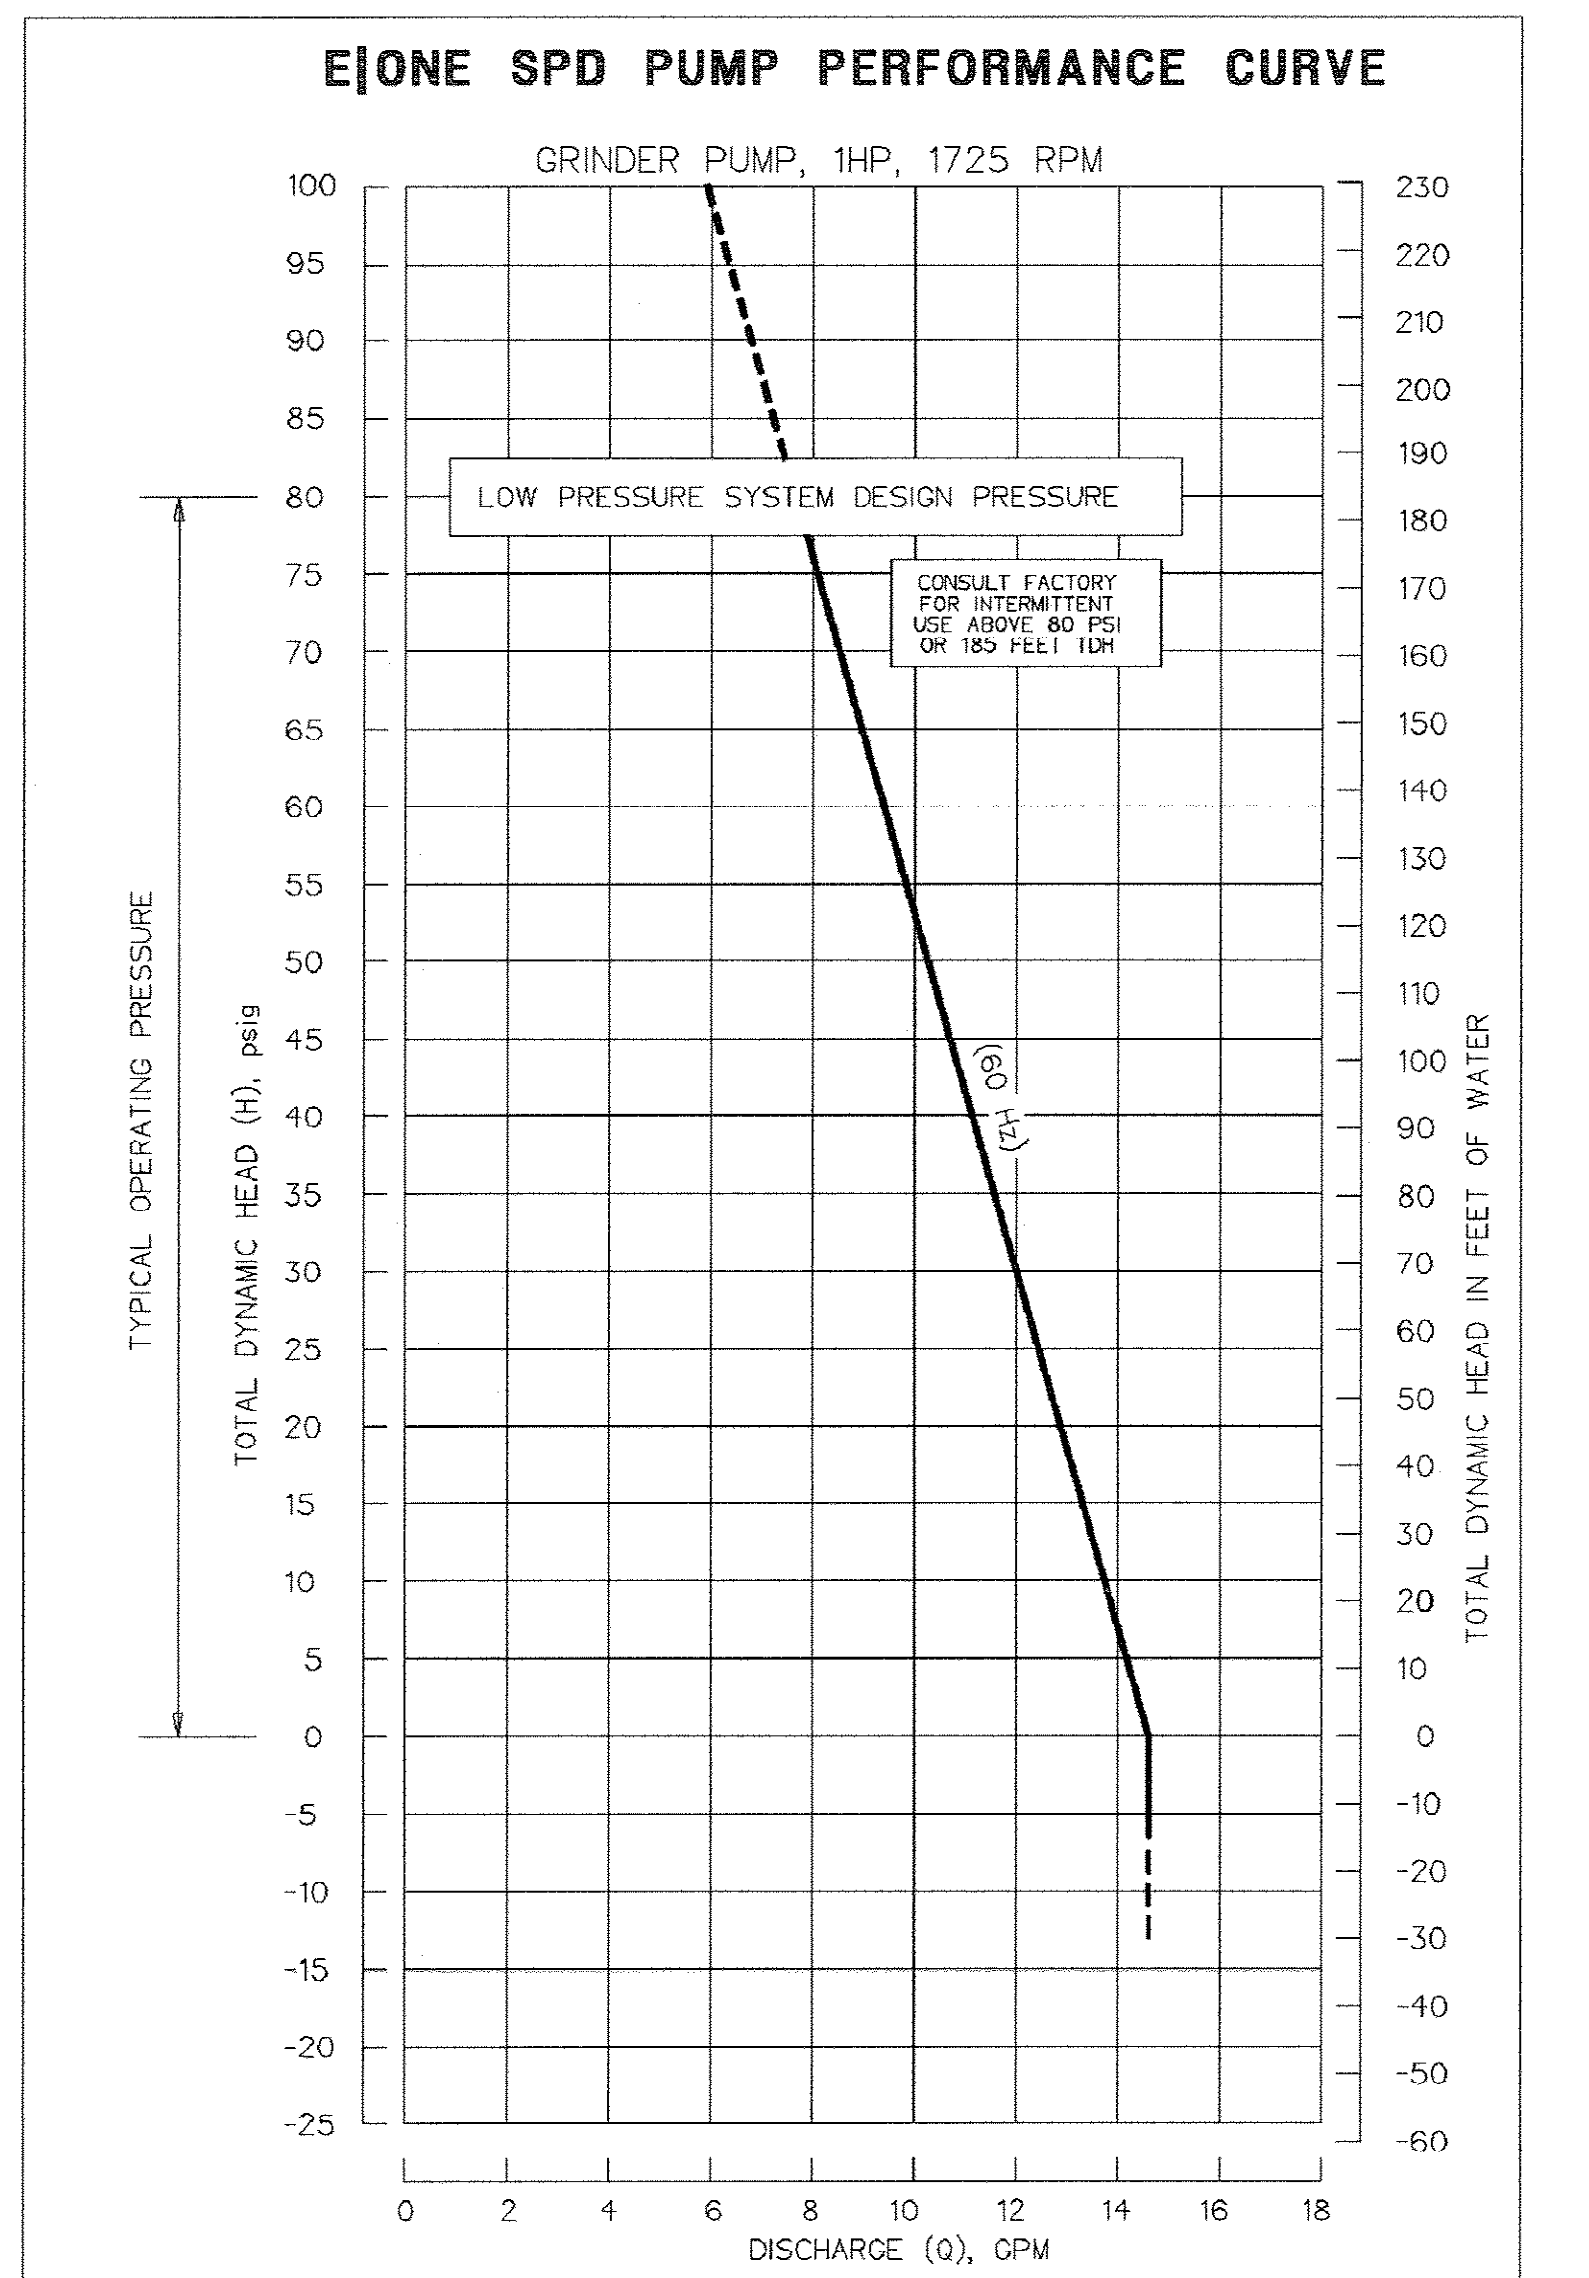


PUMP STATION SITE PLAN
SCALE: 1"=4'

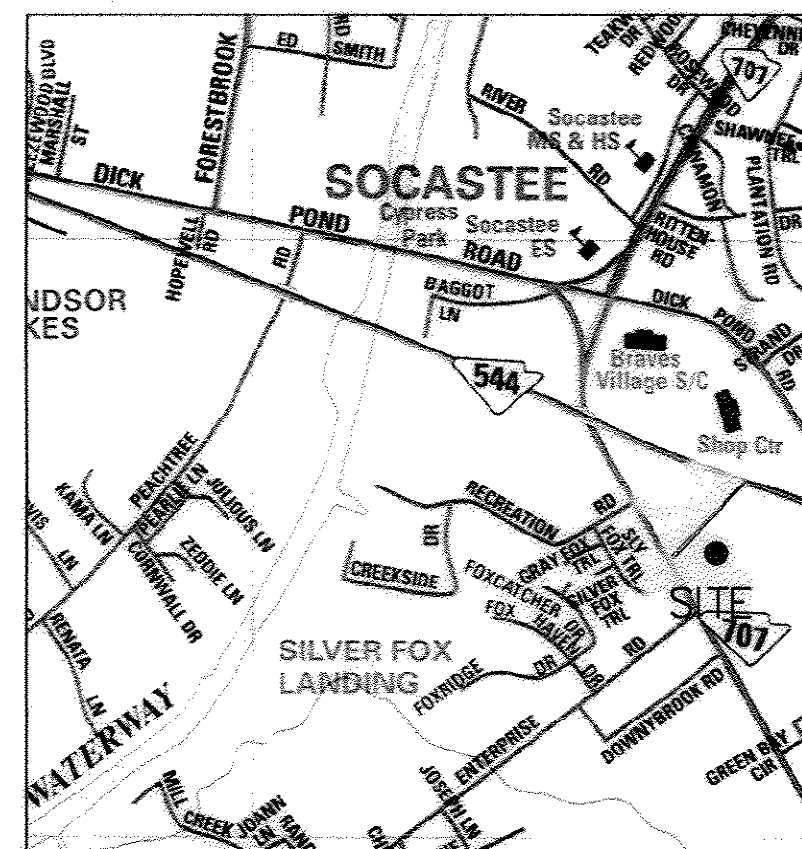

LOCATION MAP

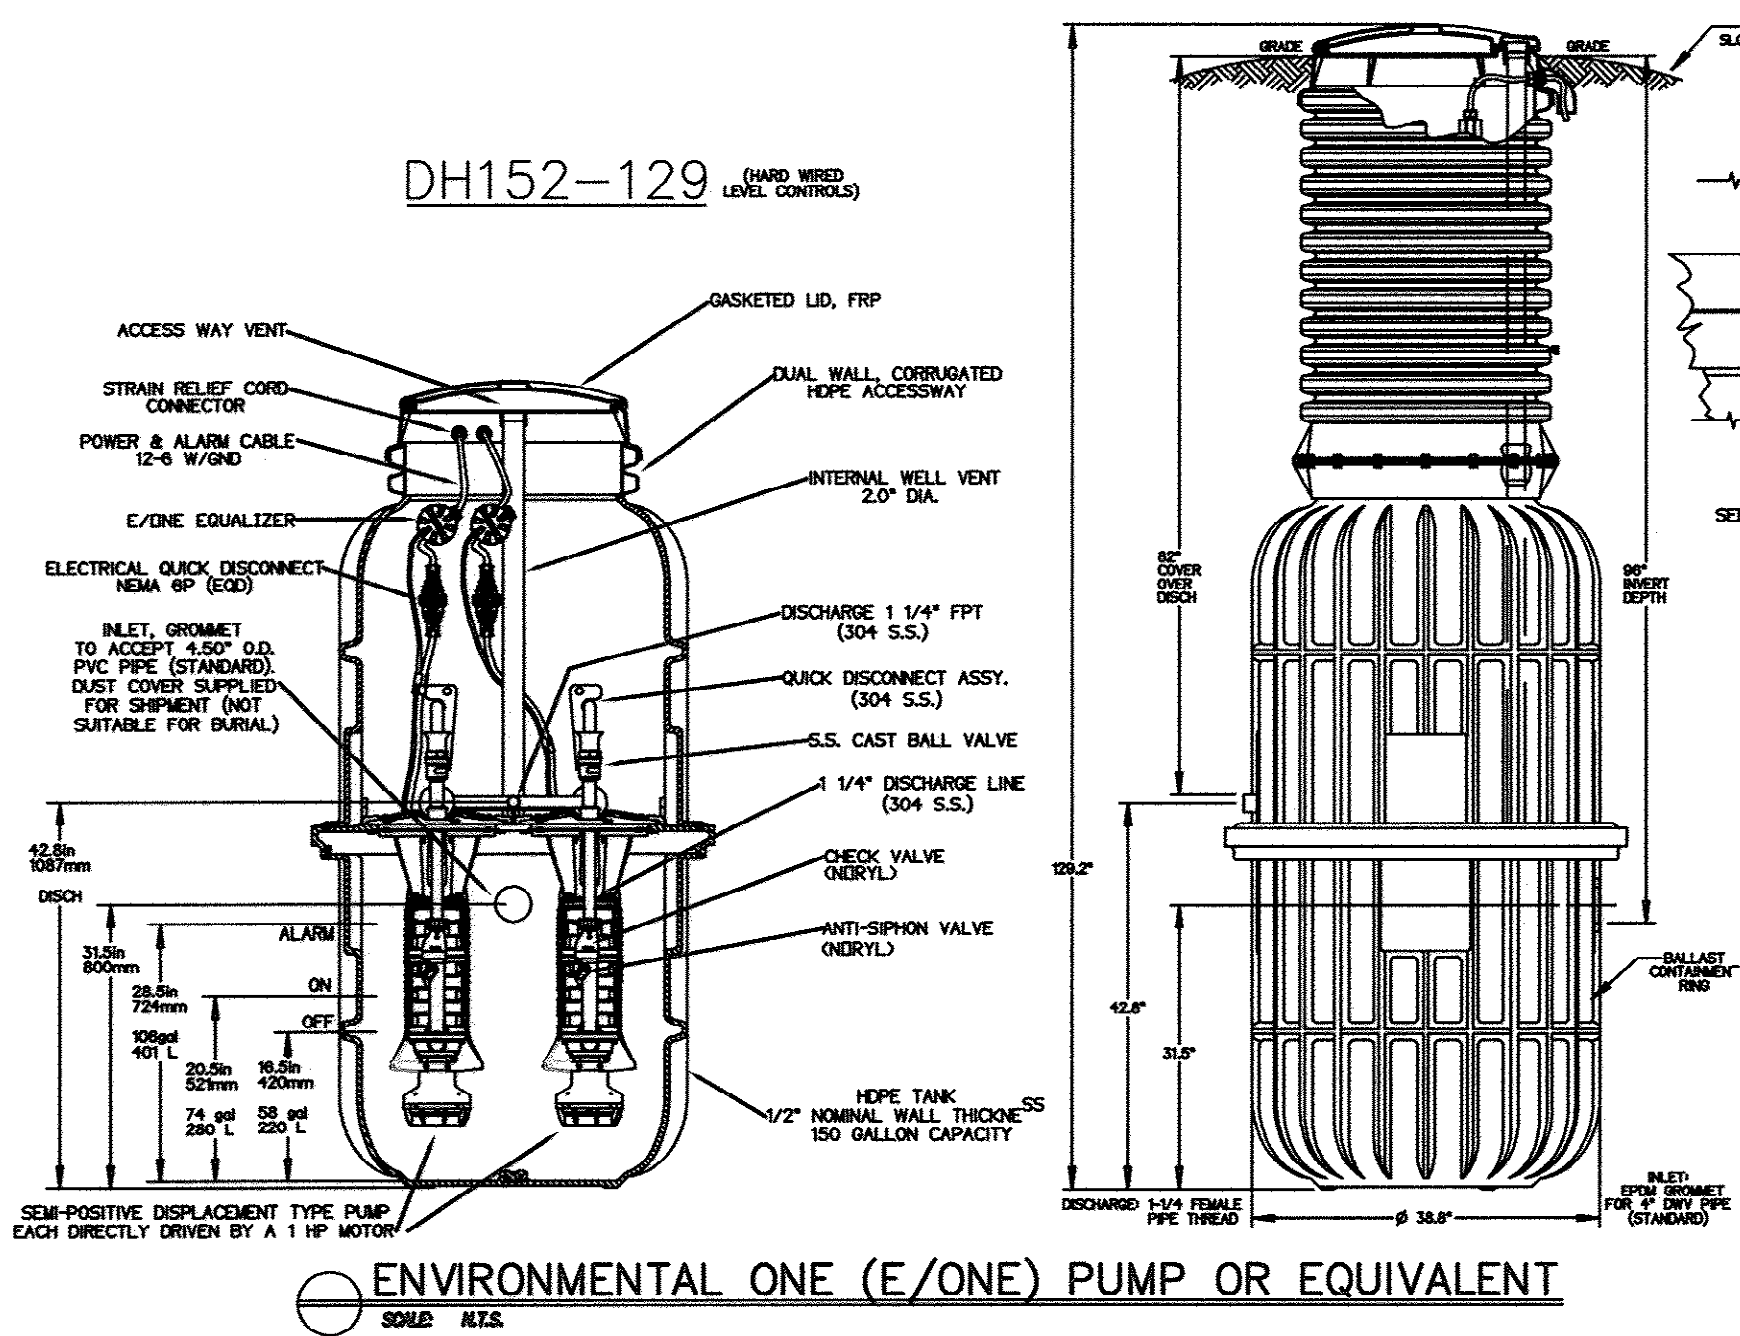

ENVIRONMENTAL ONE (E|ONE) PUMP OR EQUIVALENT
SCALE: N.T.S.

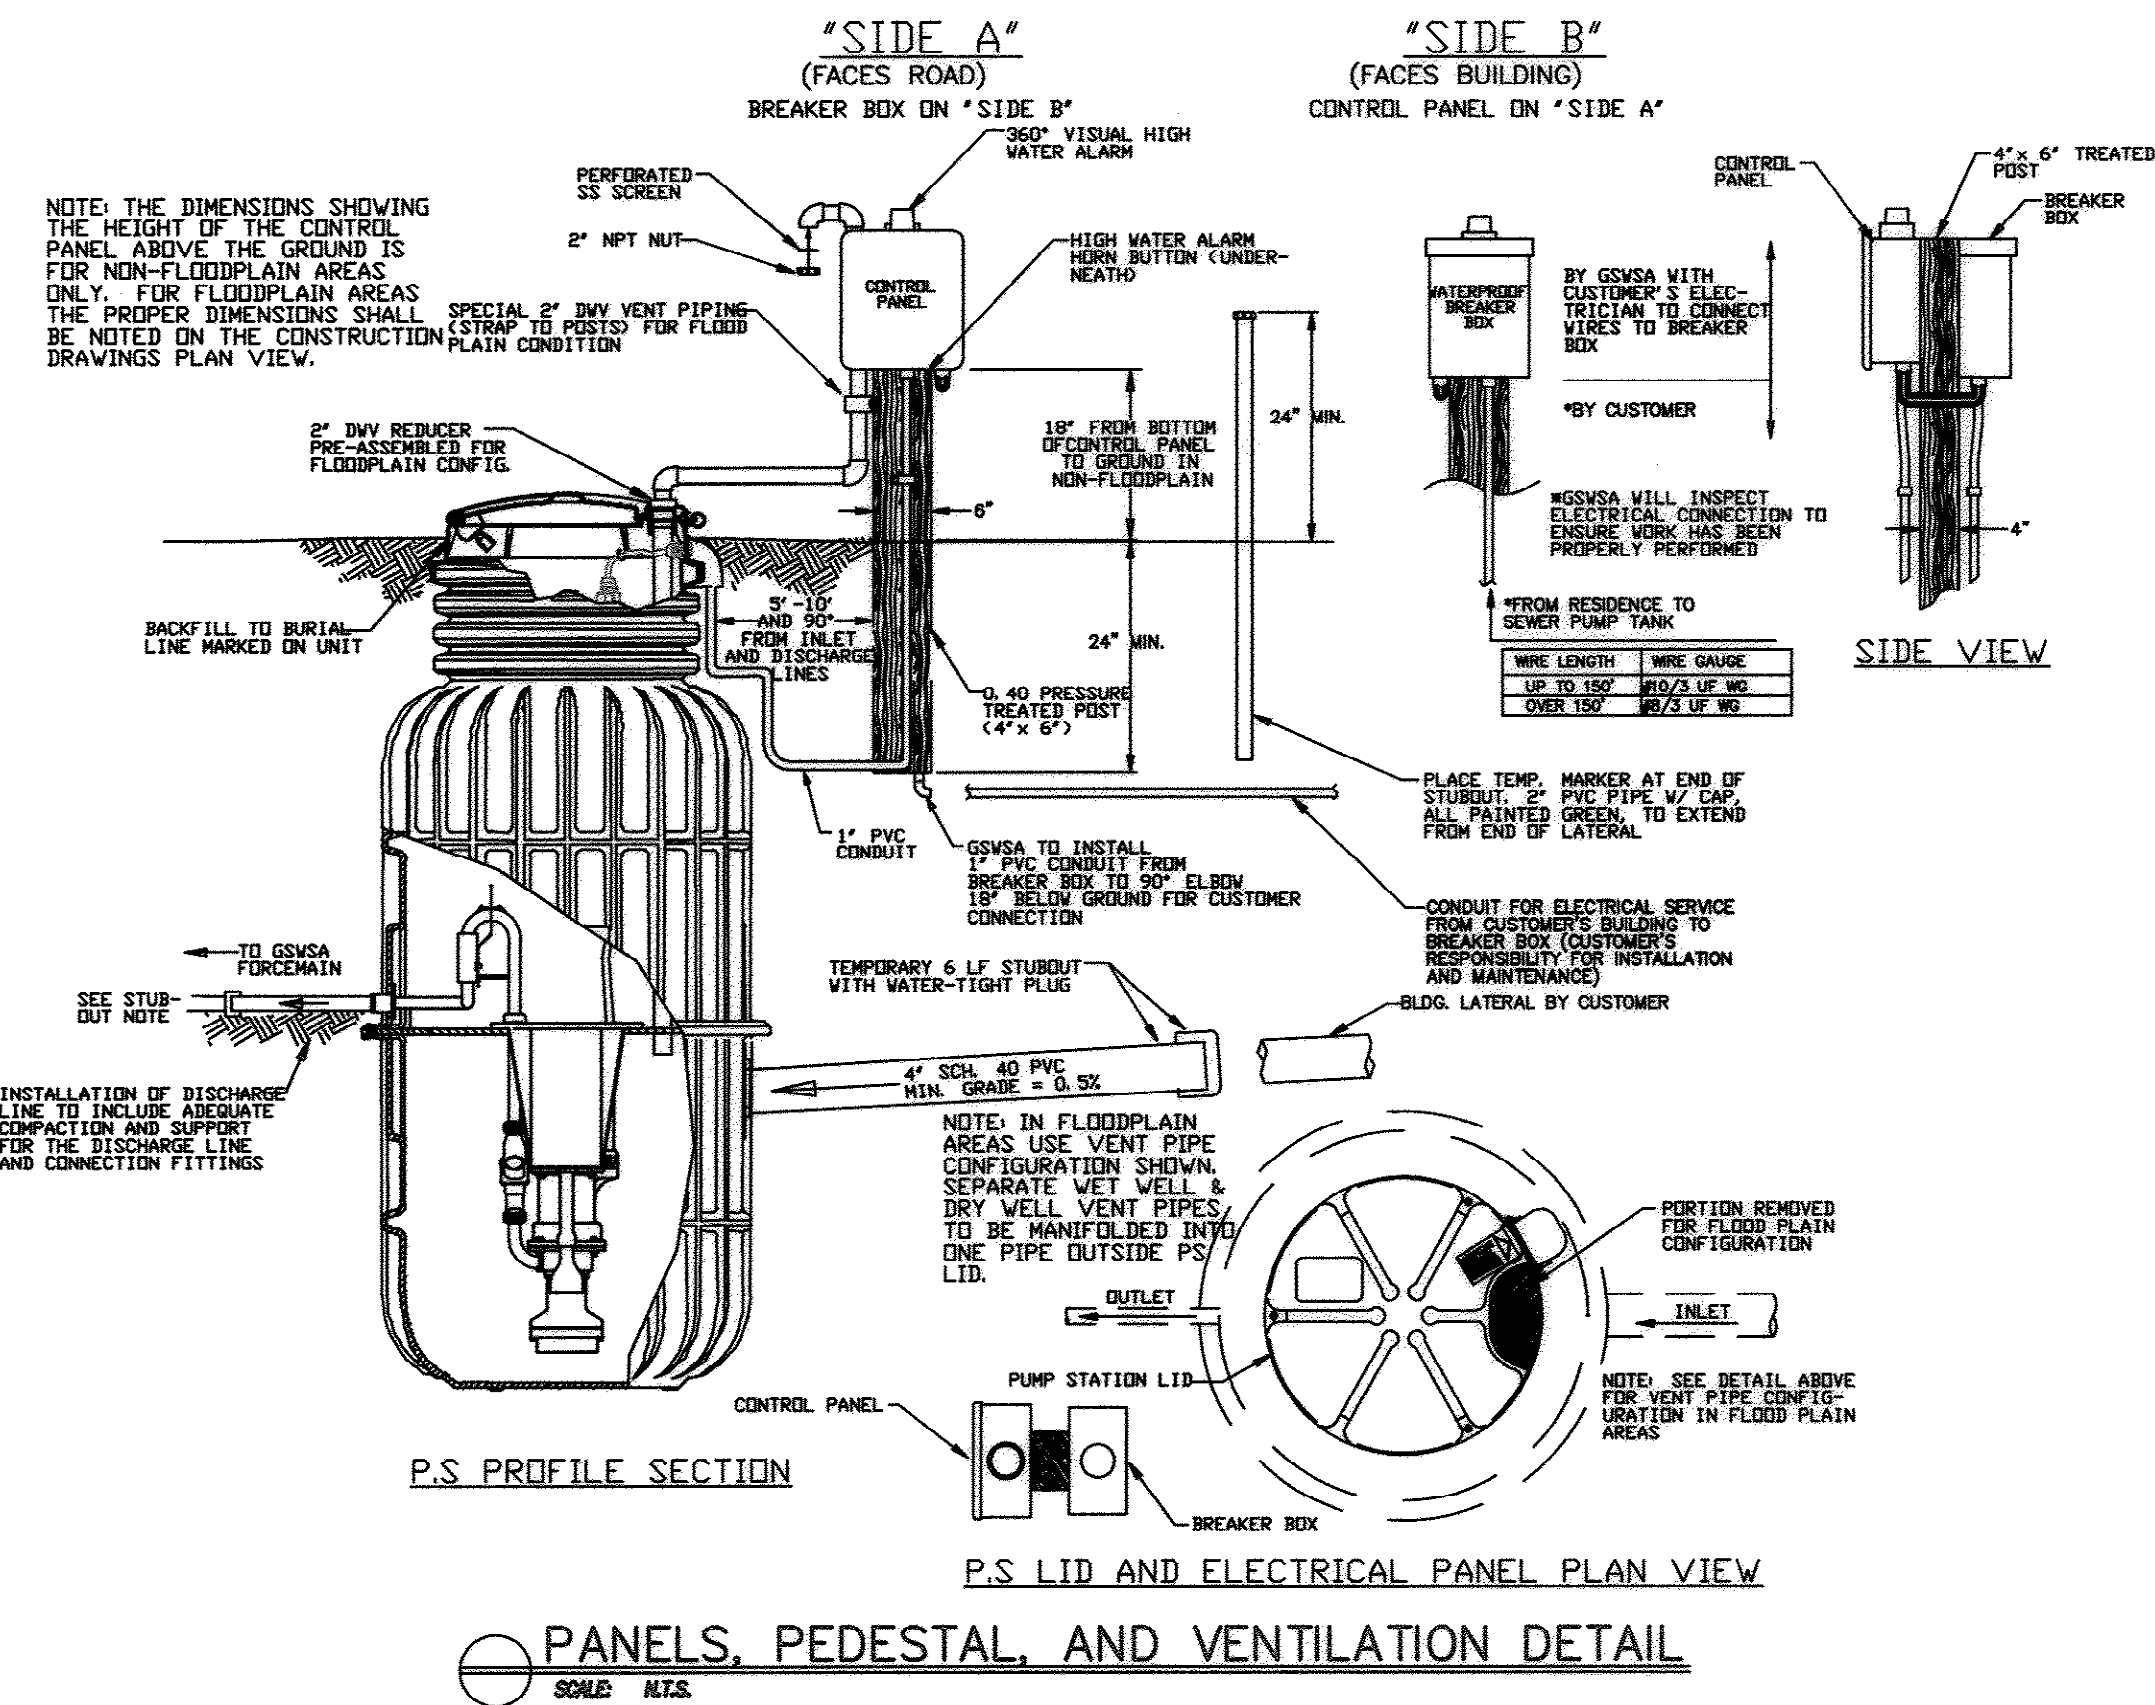

APPROVED DATE NOV 24 2008
GRAND STRAND WATER & SEWER AUTHORITY
BY: *Michael A. Edwards*

SEWER SYSTEM RECORD DRAWING
BEACH FAMILY WORSHIP CENTER
TOWN OF SOCASTEE
Horry County, South Carolina
PREPARED FOR: BEACH FAMILY WORSHIP INC.

FILE NO. 08-033
SCALE As Noted
DATE 10-29-08
DRAWN BY NJP
CHECKED BY
DWG NO.

S2