


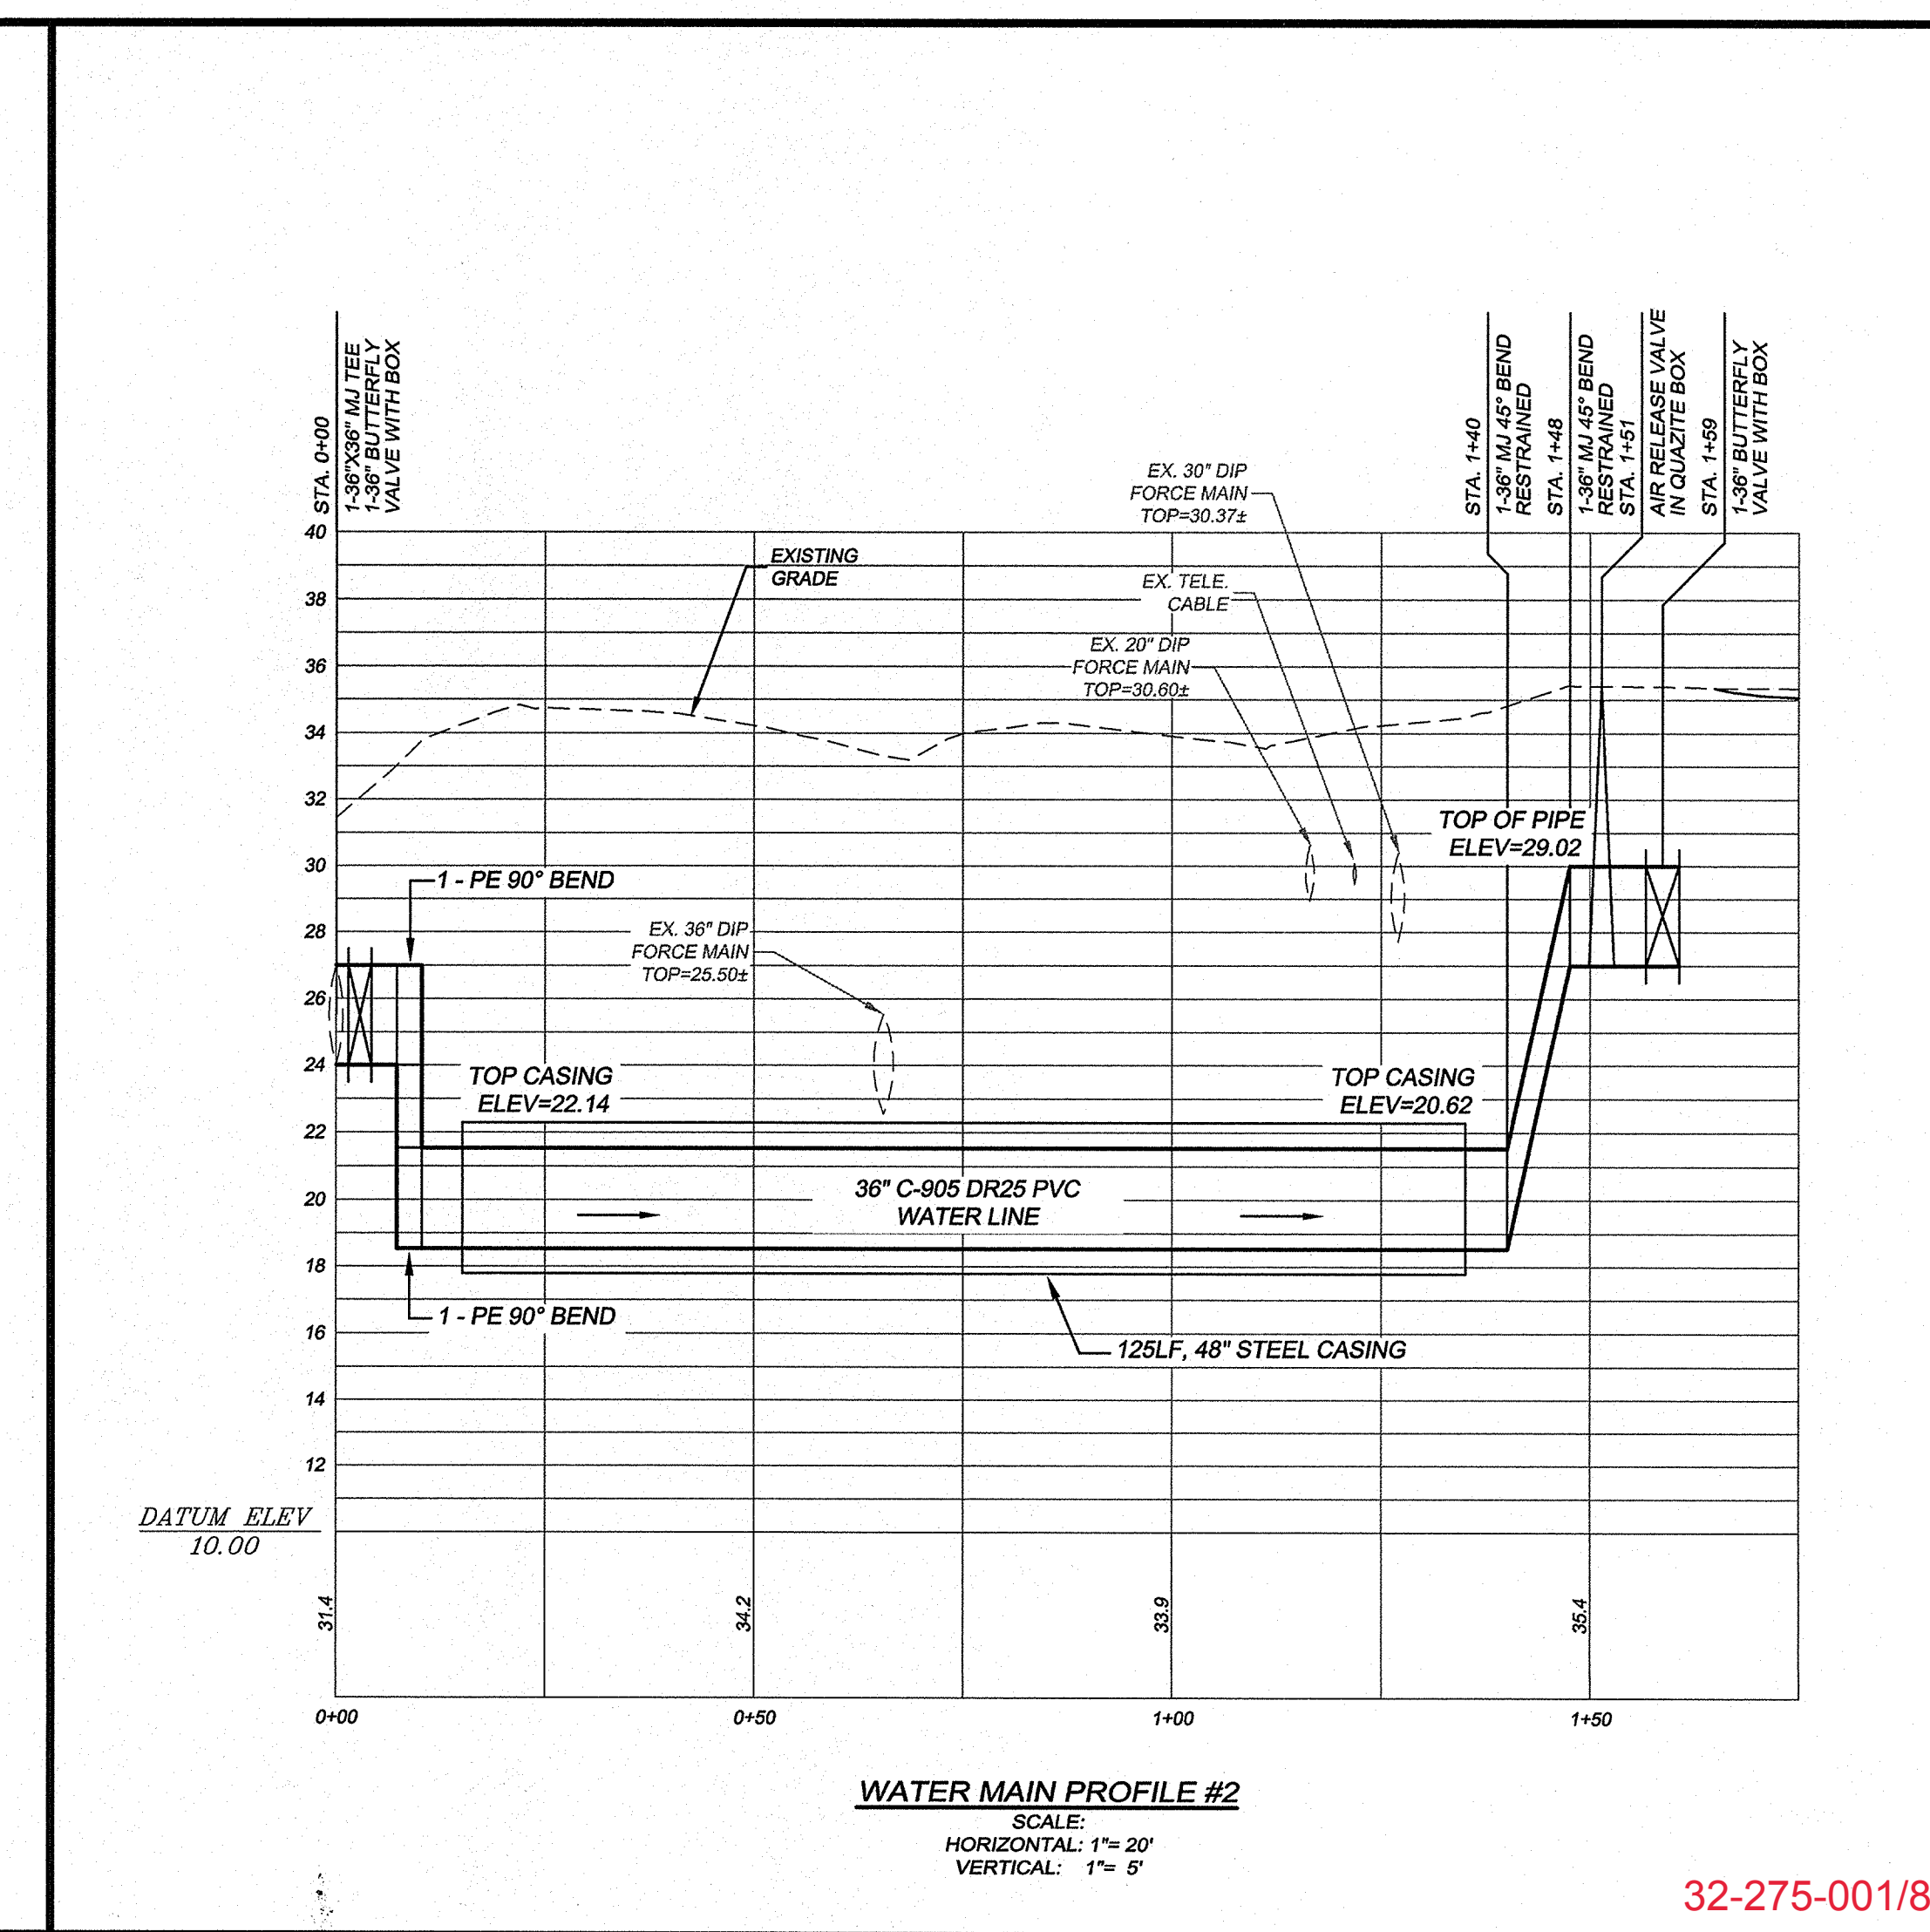

DDC
ENGINEERS
Consulting Engineers, Surveyors, Planners,
Landscape Architects & Environmentalists
1238 Professional Dr., Myrtle Beach, SC 29577
Phone: (843) 692-3200 Fax: (843) 692-3210

FILE NO.:

2 of 8

PROJECT NO.: 14937E

APPROV. BY: EKS

DRAWN BY: PES / KJG

DESIGNED BY: EKS

DATE: 8/9/17

SCALE: AS SHOWN

NOTIFICATION IS HEREBY GIVEN THAT THIS DOCUMENT IS THE PROPERTY OF DDC ENGINEERS, INC. AND ALL RIGHTS WITH REGARD TO COPYRIGHTS ARE RESERVED AS OF THE DATE OF THIS DOCUMENT. NO PART OF THIS DOCUMENT MAY BE REPRODUCED OR TRANSMITTED IN ANY FORM OR BY ANY MEANS, ELECTRONIC OR MECHANICAL, INCLUDING PHOTOCOPYING, RECORDING, OR BY ANY INFORMATION STORAGE AND RETRIEVAL SYSTEM, WITHOUT PERMISSION IN WRITING FROM DDC ENGINEERS, INC.

REVISION DESCRIPTION

BY

NO.

DATE

REVISION

DESCRIPTION

NO.

DATE

REVISION

DESCRIPTION

NO.

DATE



REVISION

DESCRIPTION





NO.

<

REMAINDER OF
N/F
MYRTLE BEACH FARMS COMPANY, INC.
TMS NO. 165-00-01-074

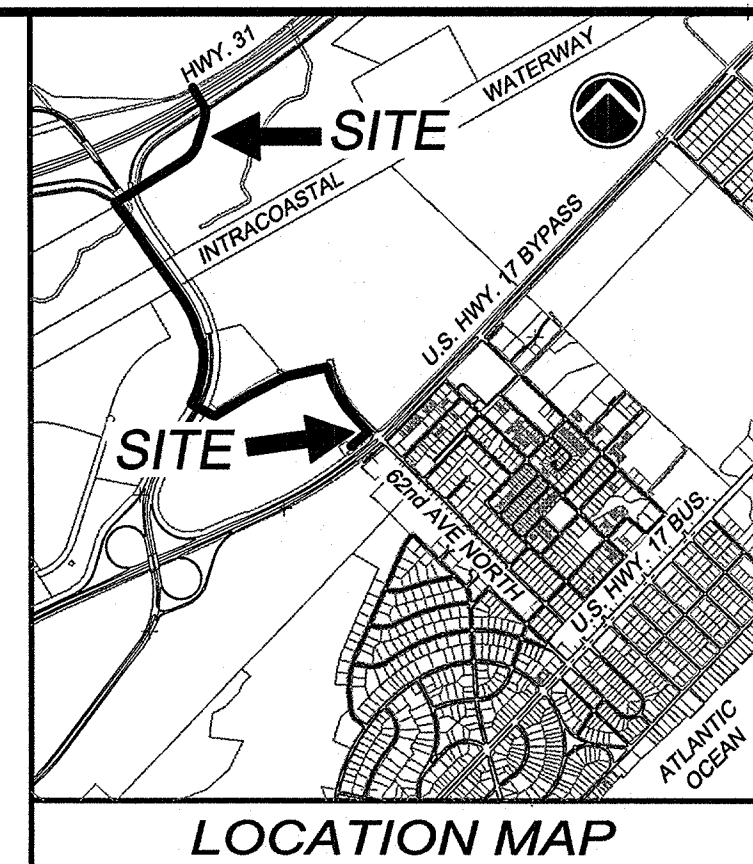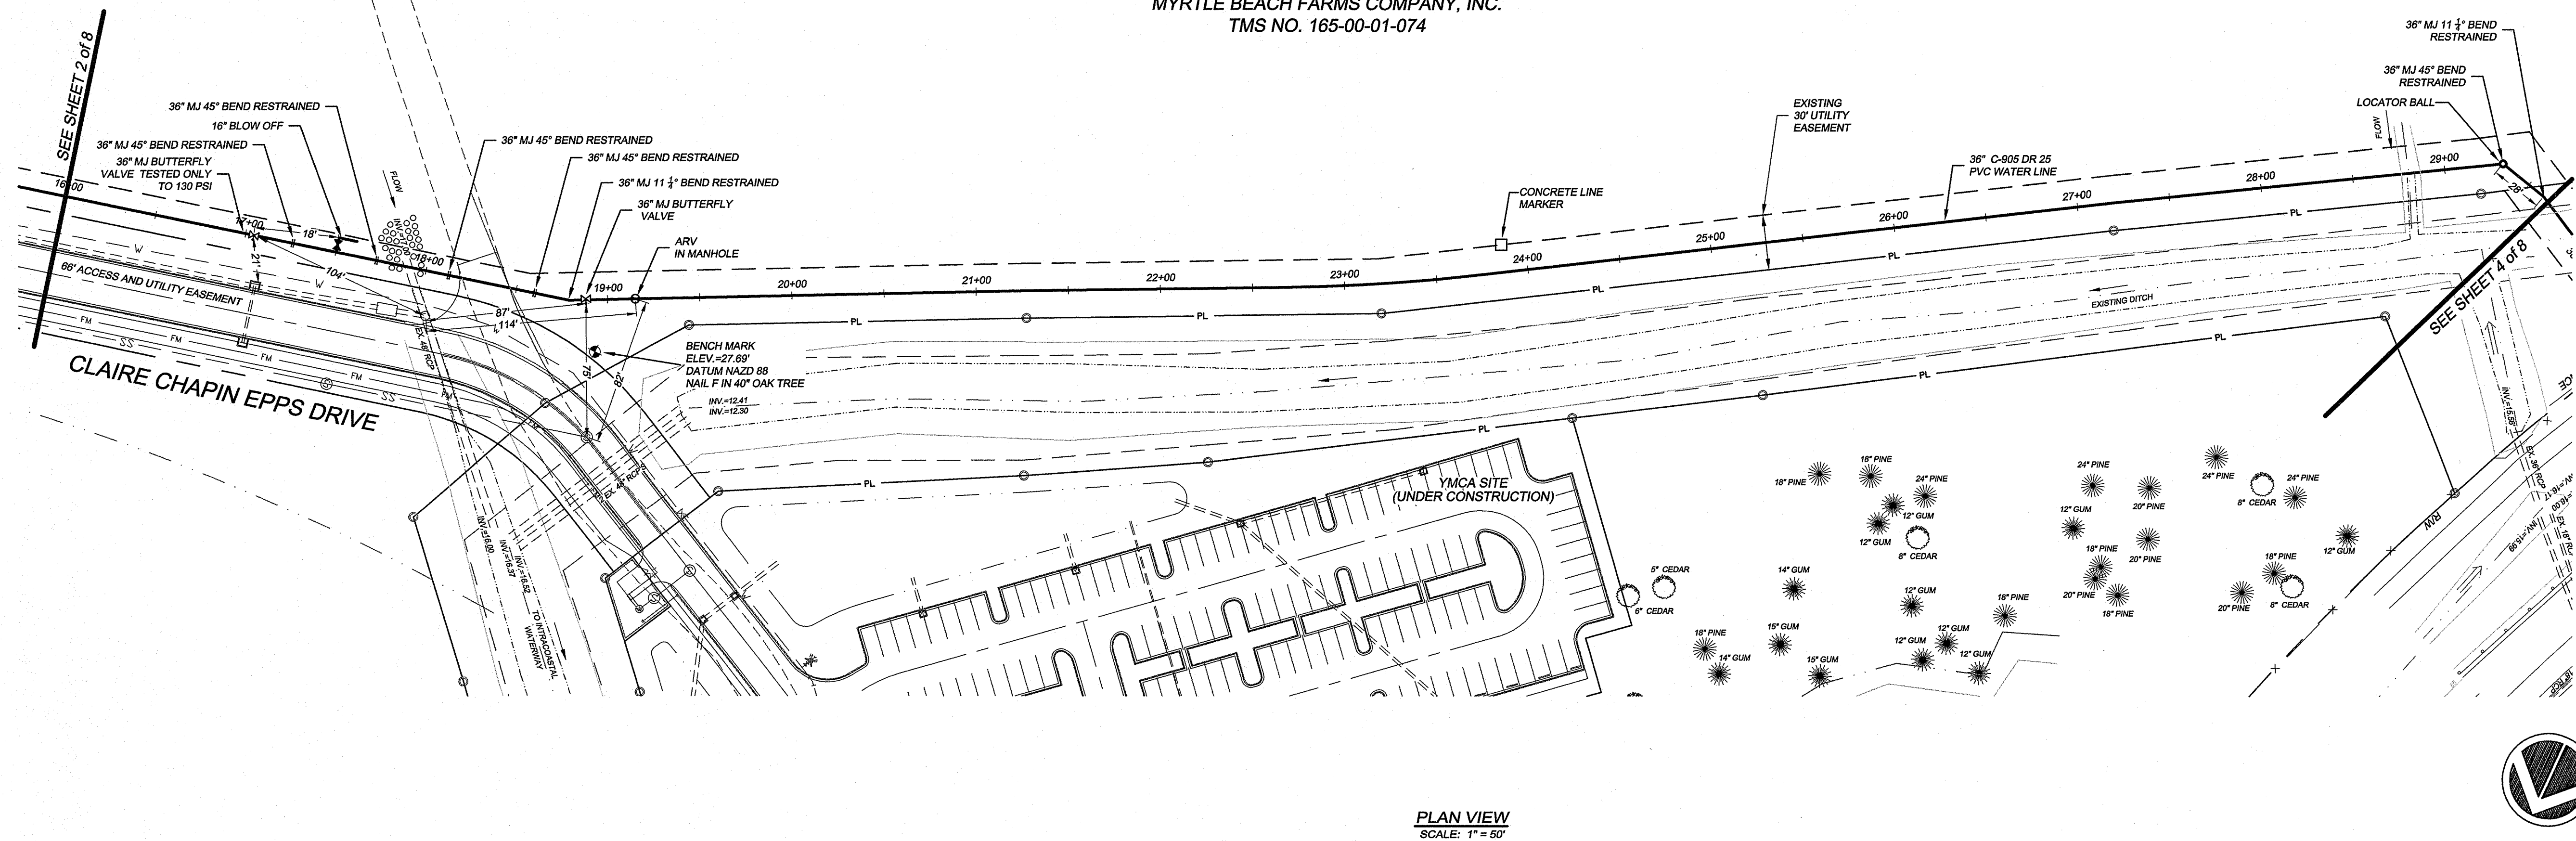

CERTIFICATION
I HEREBY CERTIFY THAT THE WATER AND/OR SEWER UTILITIES AS SHOWN HAVE BEEN INSTALLED IN ACCORDANCE WITH THE APPROVED CONSTRUCTION DRAWINGS AND SPECIFICATIONS AND ARE, TO THE BEST OF MY KNOWLEDGE, AS SHOWN ON THESE PLANS.

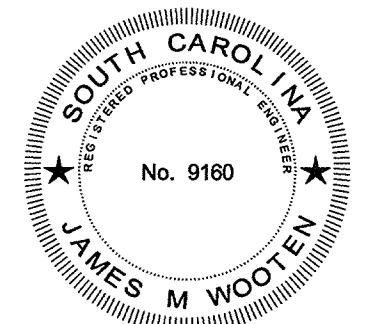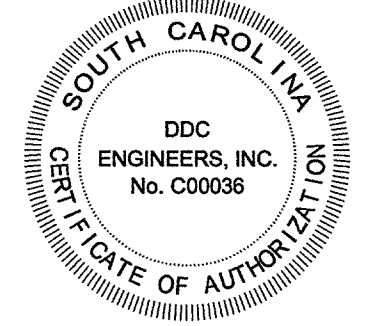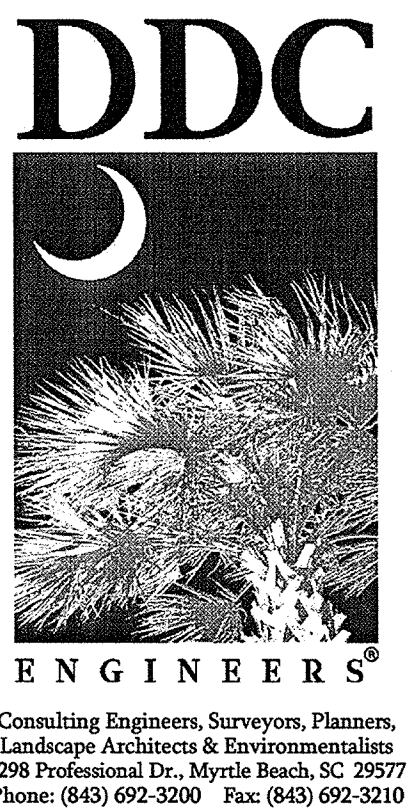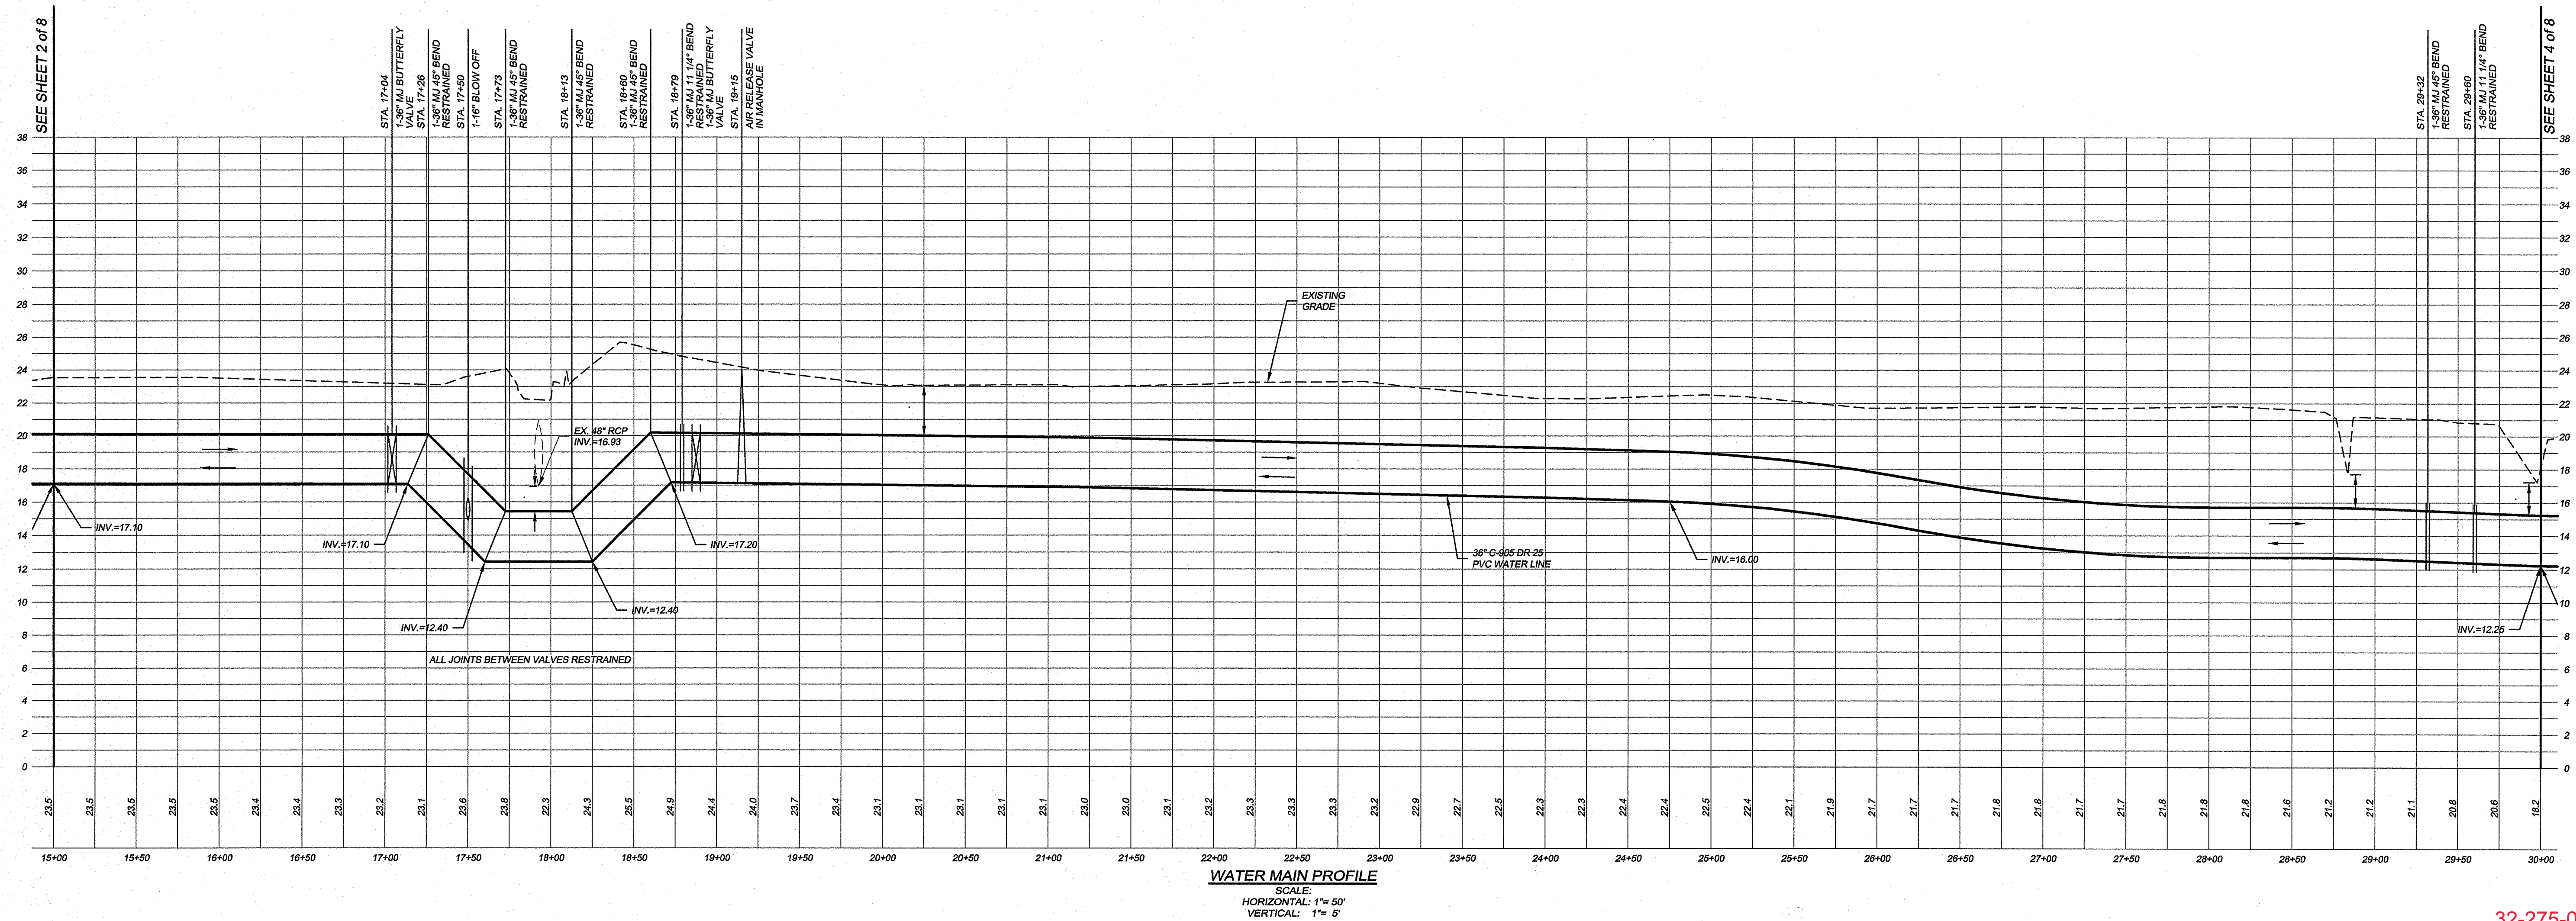[illegible]



WATER MAIN PLAN & PROFILE
RECORD DRAWING
GG&SA / MB WATER LINE INTERCONNECTION PROJECT
Horry County, South Carolina
PREPARED FOR: GRAND STRAND WATER & SEWER AUTHORITY

SCALE:	AS SHOWN
DATE:	8/9/17
DESIGNED BY:	EKS
DRAWN BY:	PES / K/JG
APPROV. BY:	EKS
PROJECT NO.:	14937E

3 of 8



FILE NO.:

32-275-003/8

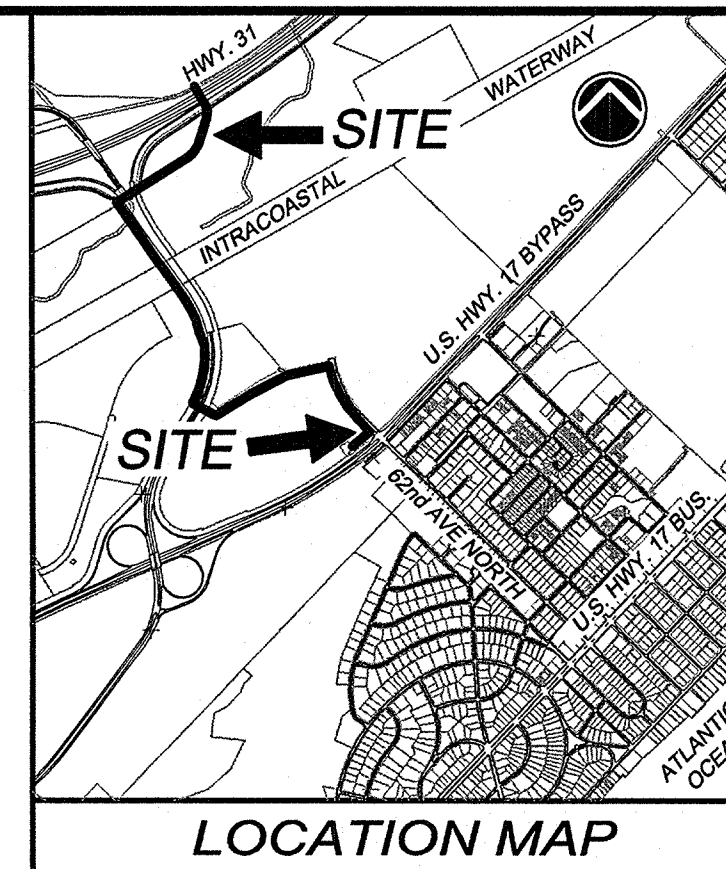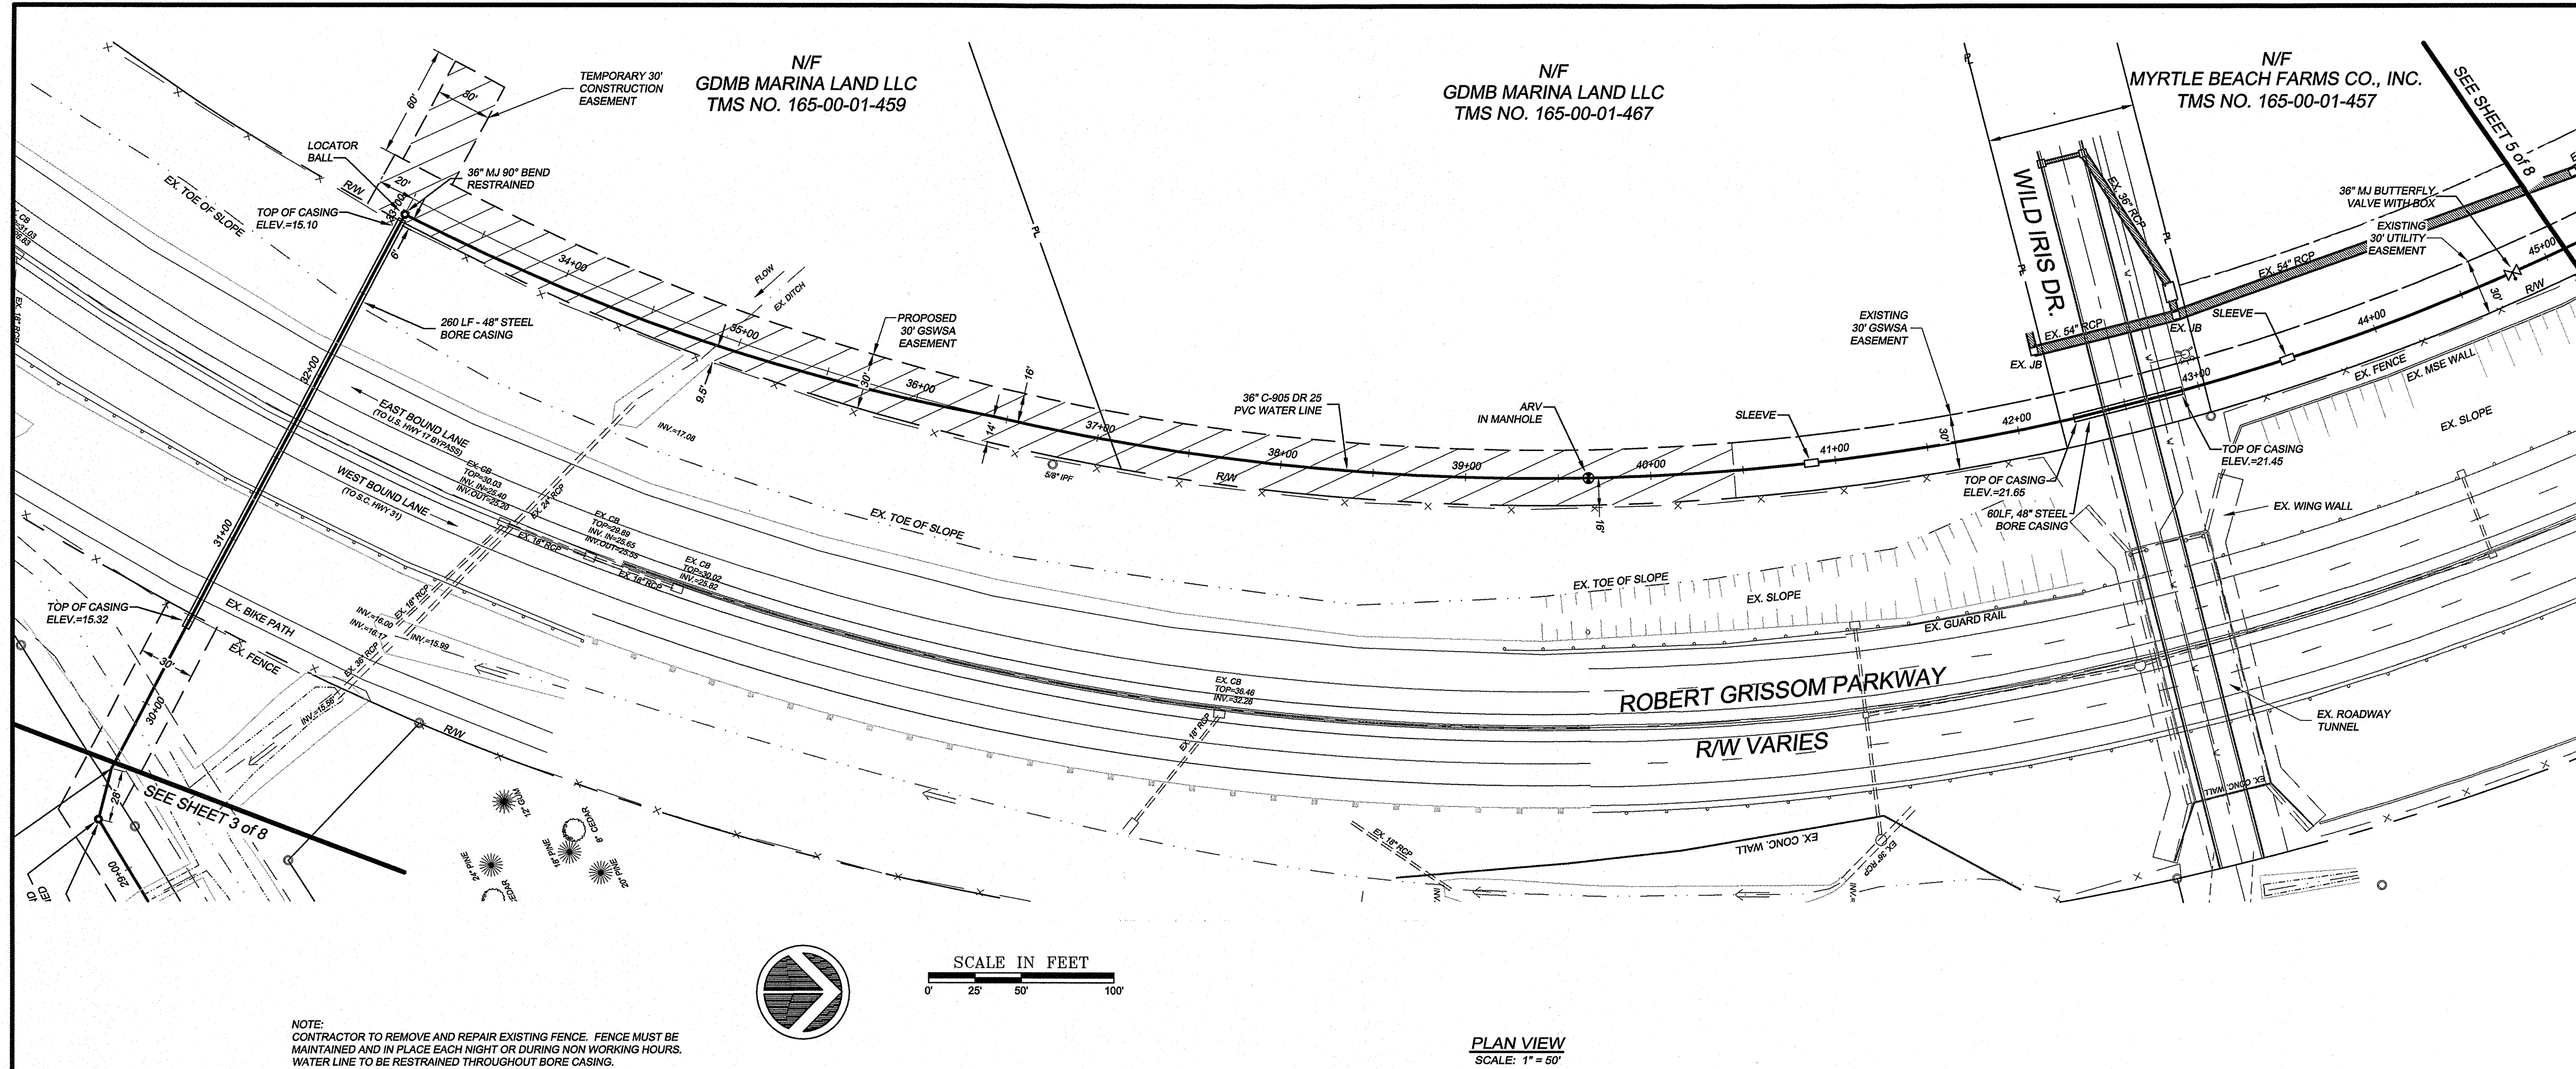


CERTIFICATION
I HEREBY CERTIFY THAT THE WATER AND/OR SEWER UTILITIES AS SHOWN ON THESE PLANS WERE LOCATED AND DEPTH MEASURED IN ACCORDANCE WITH THE STANDARD CONSTRUCTION PRACTICES AND SPECIFICATIONS AND ARE, TO THE BEST OF MY KNOWLEDGE, AS SHOWN ON THESE PLANS.

JAMES M. WOOTEN, P.E. SOUTH CAROLINA #9160

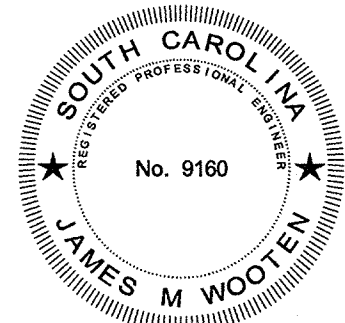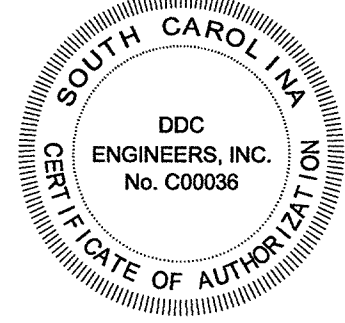

NO.	DATE	REVISION DESCRIPTION	BY

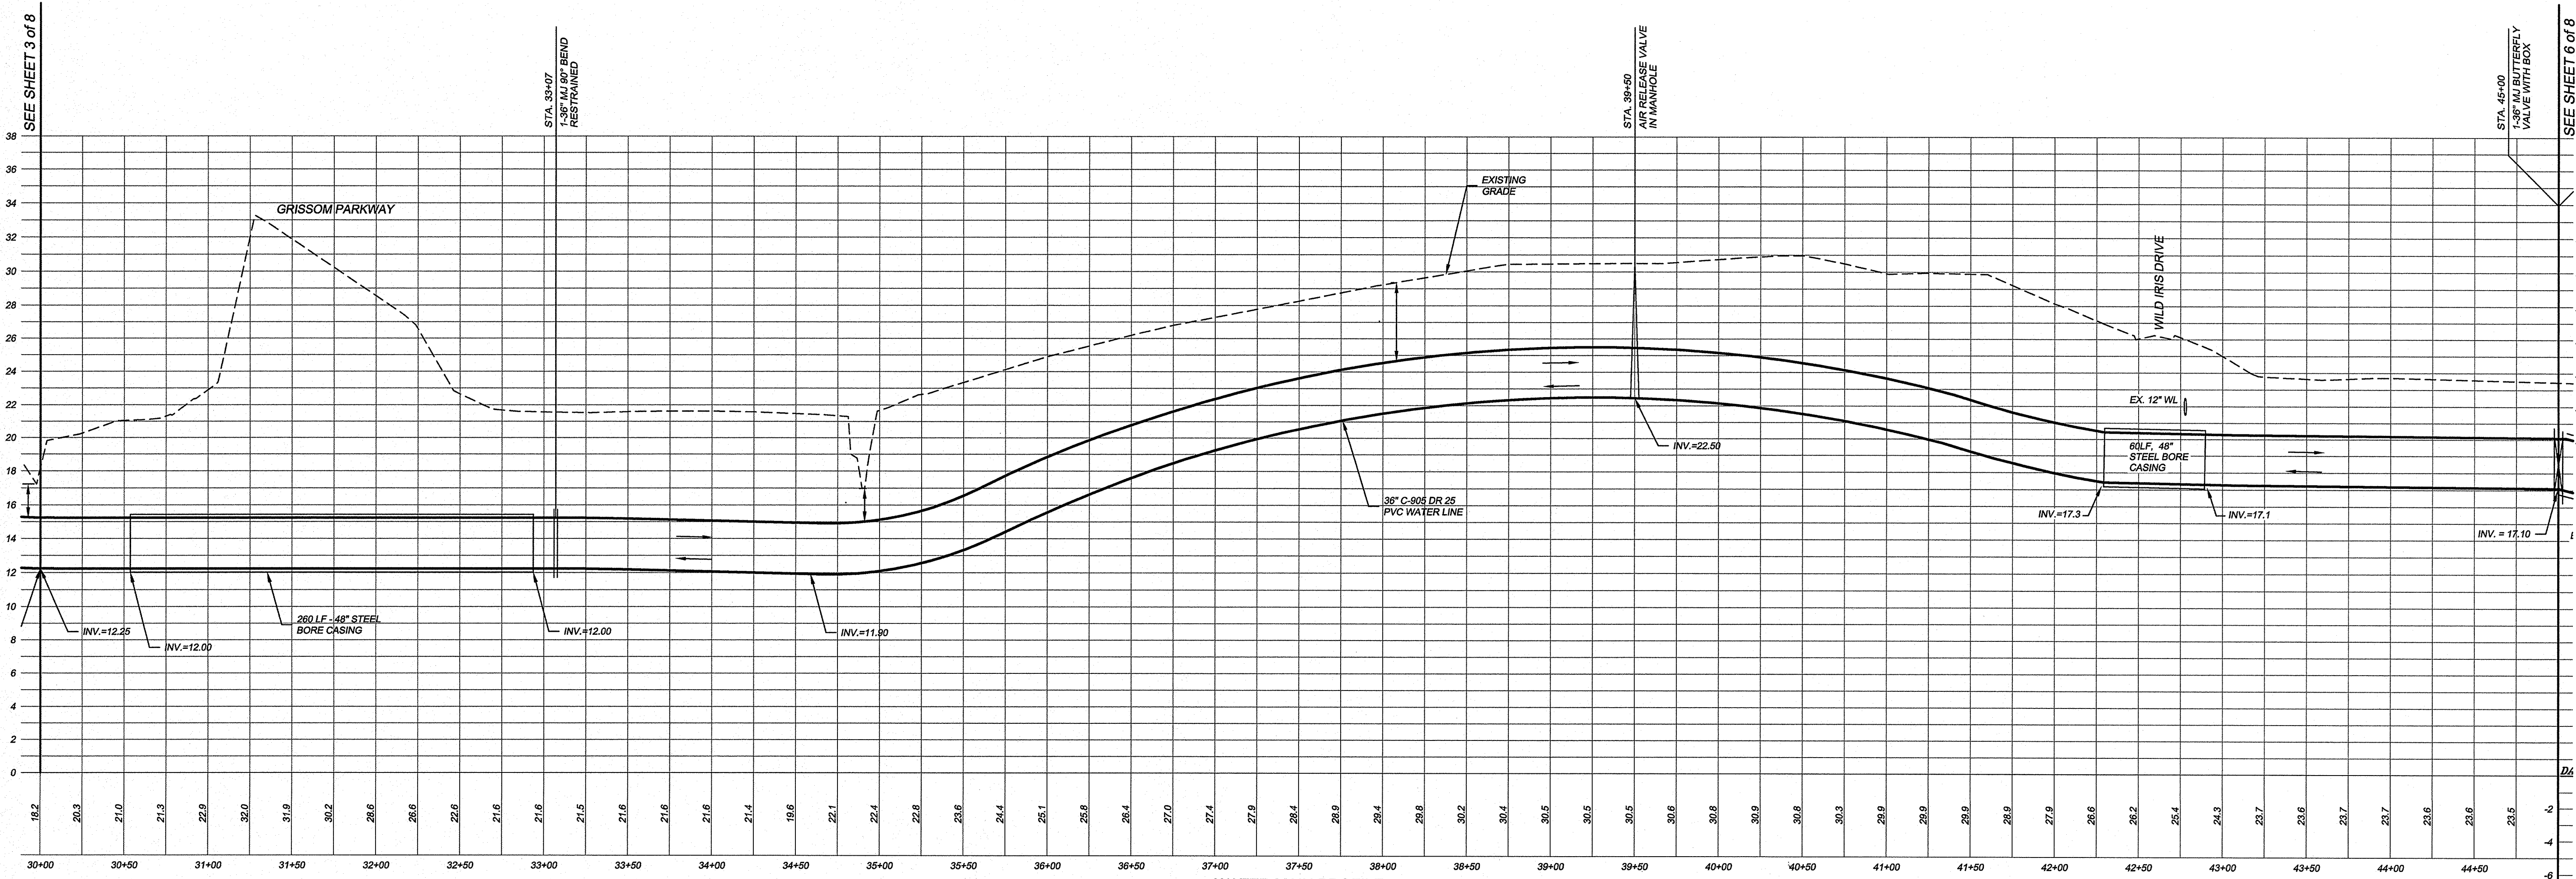

**WATER MAIN PLAN & PROFILE
RECORD DRAWING**

GSW&SA / MB WATER LINE INTERCONNECTION PROJECT
HORRY COUNTY, SOUTH CAROLINA

PREPARED FOR: GRAND STRAND WATER & SEWER AUTHORITY

SCALE: AS SHOWN
DATE: 8/9/17
DESIGNED BY: EKS
DRAWN BY: PES / KJG
APPROV. BY: EKS
PROJECT NO.: 14937E

4 of 8

 

 

FILE NO.:




 
DDC
ENGINEERS®

Consulting Engineers, Surveyors, Planners,
Landscape Architects & Environmentalists
1298 Professional Dr., Myrtle Beach, SC 29577
Phone: (843) 692-3200 Fax: (843) 692-3210

PLOT SCALE: 1" = 1'



32-275-004/8

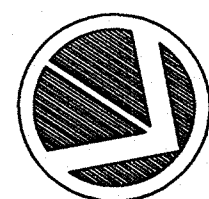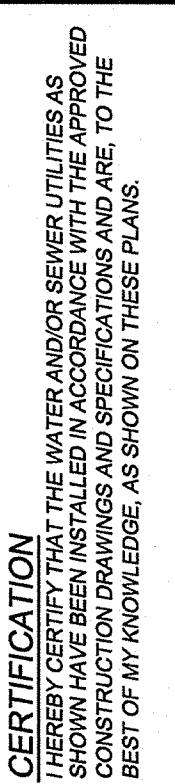

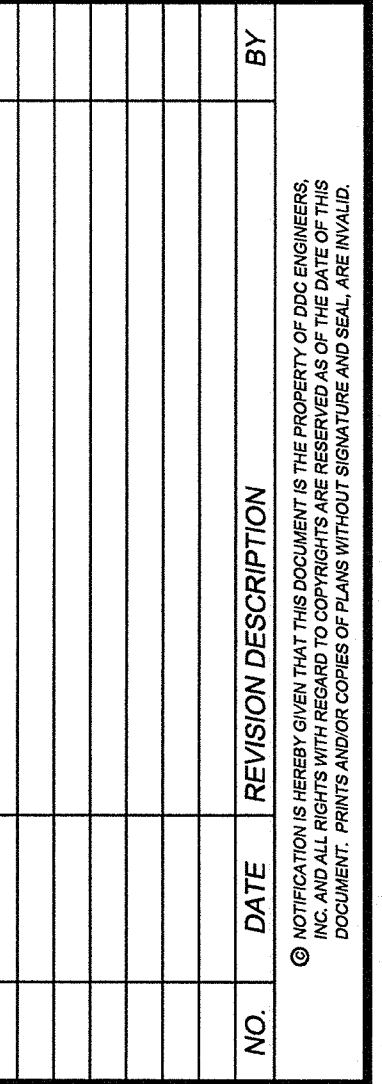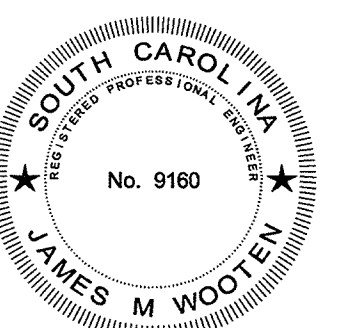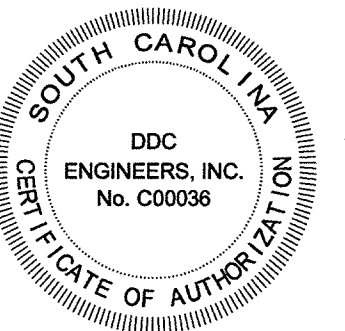


WATER MAIN, LEAK & TROUBLE RECORD DRAWING	GSW&SA / MB WATER LINE INTERCONNECTION PROJECT HORRY COUNTY, SOUTH CAROLINA
PREPARED FOR: GRAND STRAND WATER & SEWER AUTHORITY	

DATE:	AS SHOWN
DATE:	8/9/17
SIGNED BY:	EKS
DRAWN BY:	PES / KJG
APPROV. BY:	EKS
PROJECT NO.:	14937E


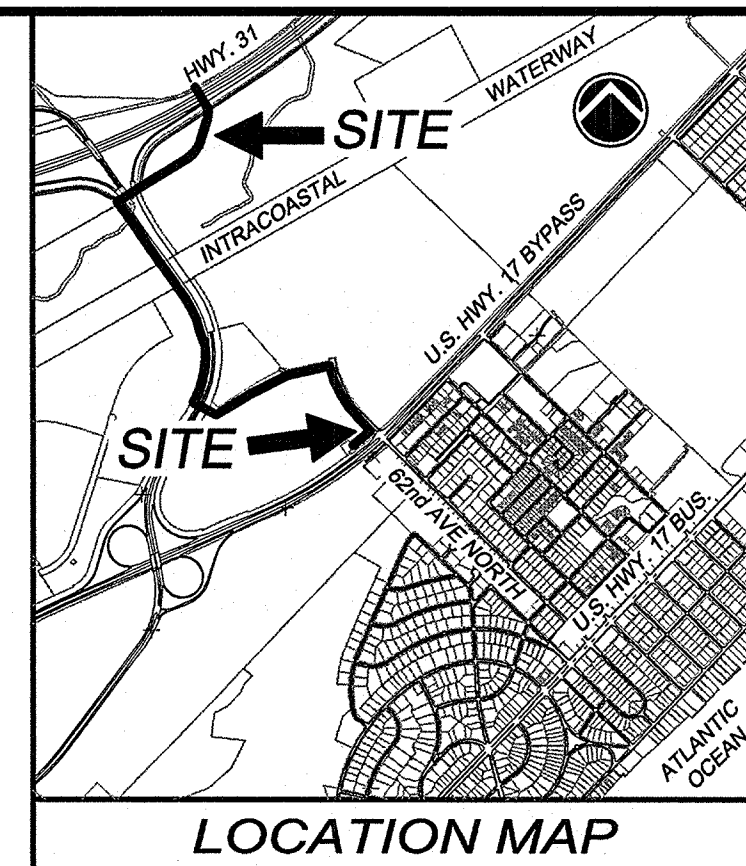
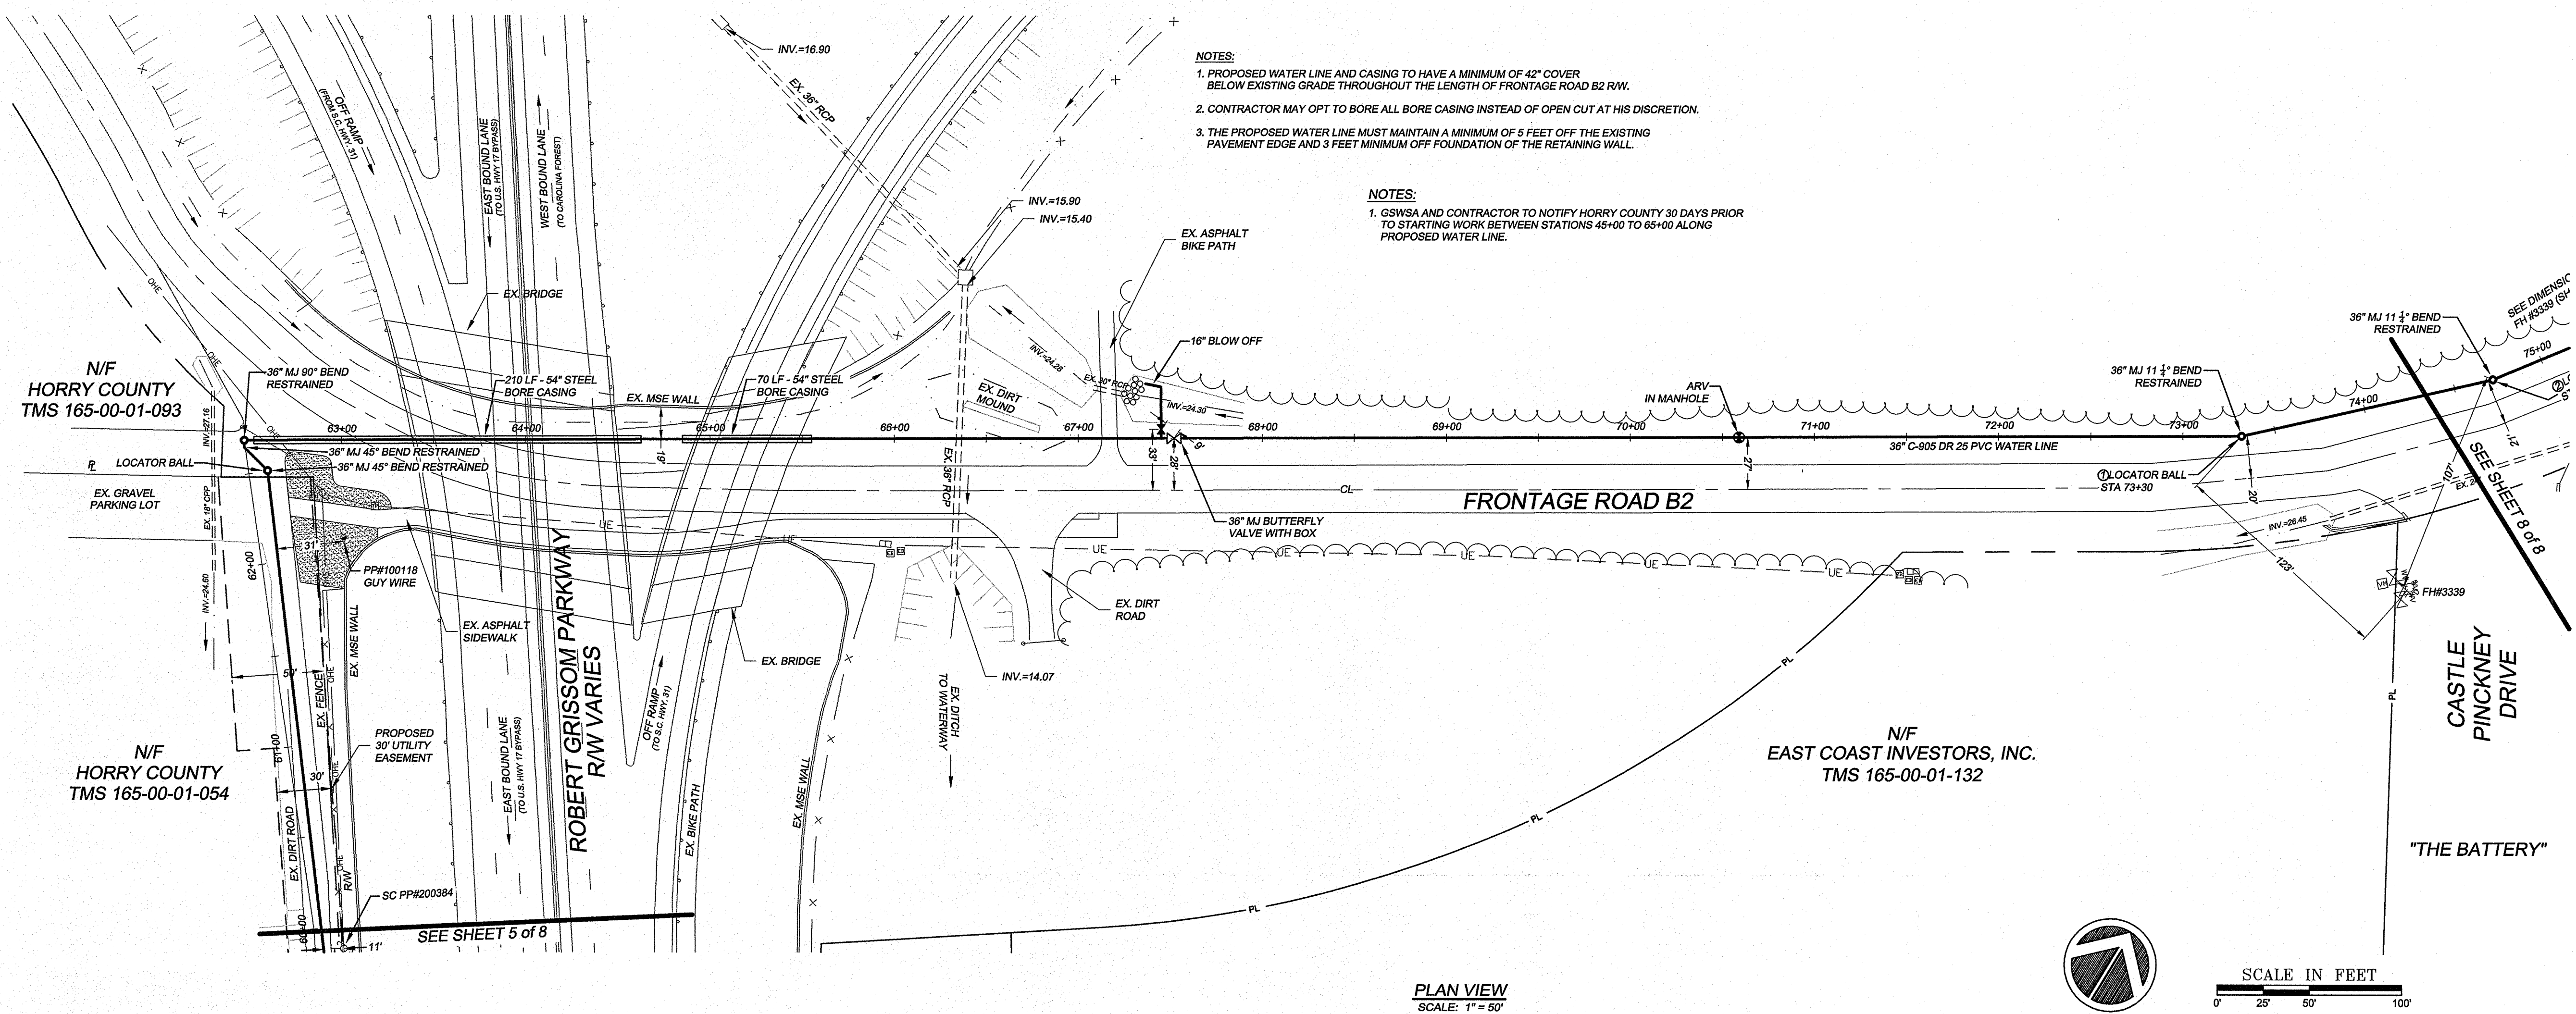


CERTIFICATION
I HEREBY CERTIFY THAT THE WATER AND/OR SEWER UTILITIES AS SHOWN HAVE BEEN INSTALLED IN ACCORDANCE WITH THE APPROVED CONSTRUCTION DRAWINGS AND SPECIFICATIONS AND ARE, TO THE BEST OF MY KNOWLEDGE, AS SHOWN ON THESE PLANS.

JAMES M. WOOTEN, P.E., SOUTH CAROLINA, #9160

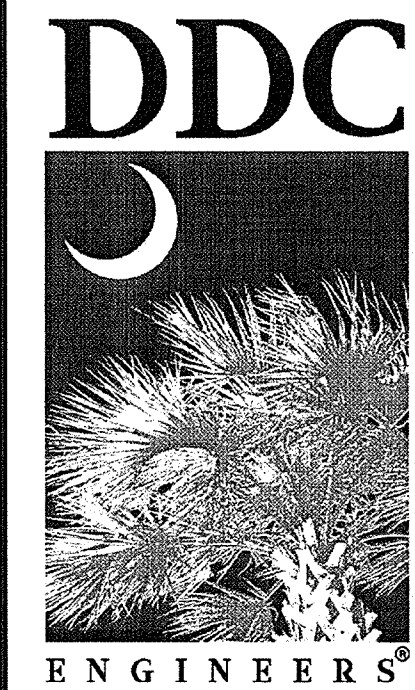

Consulting Engineers, Surveyors, Planners,
Landscape Architects & Environmentalists
1298 Professional Dr., Myrtle Beach, SC 29577
Phone: (843) 692-3200 Fax: (843) 692-3210

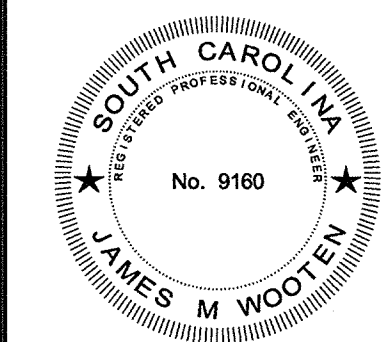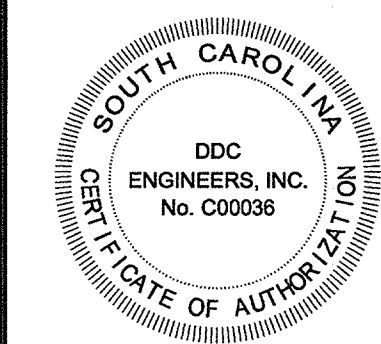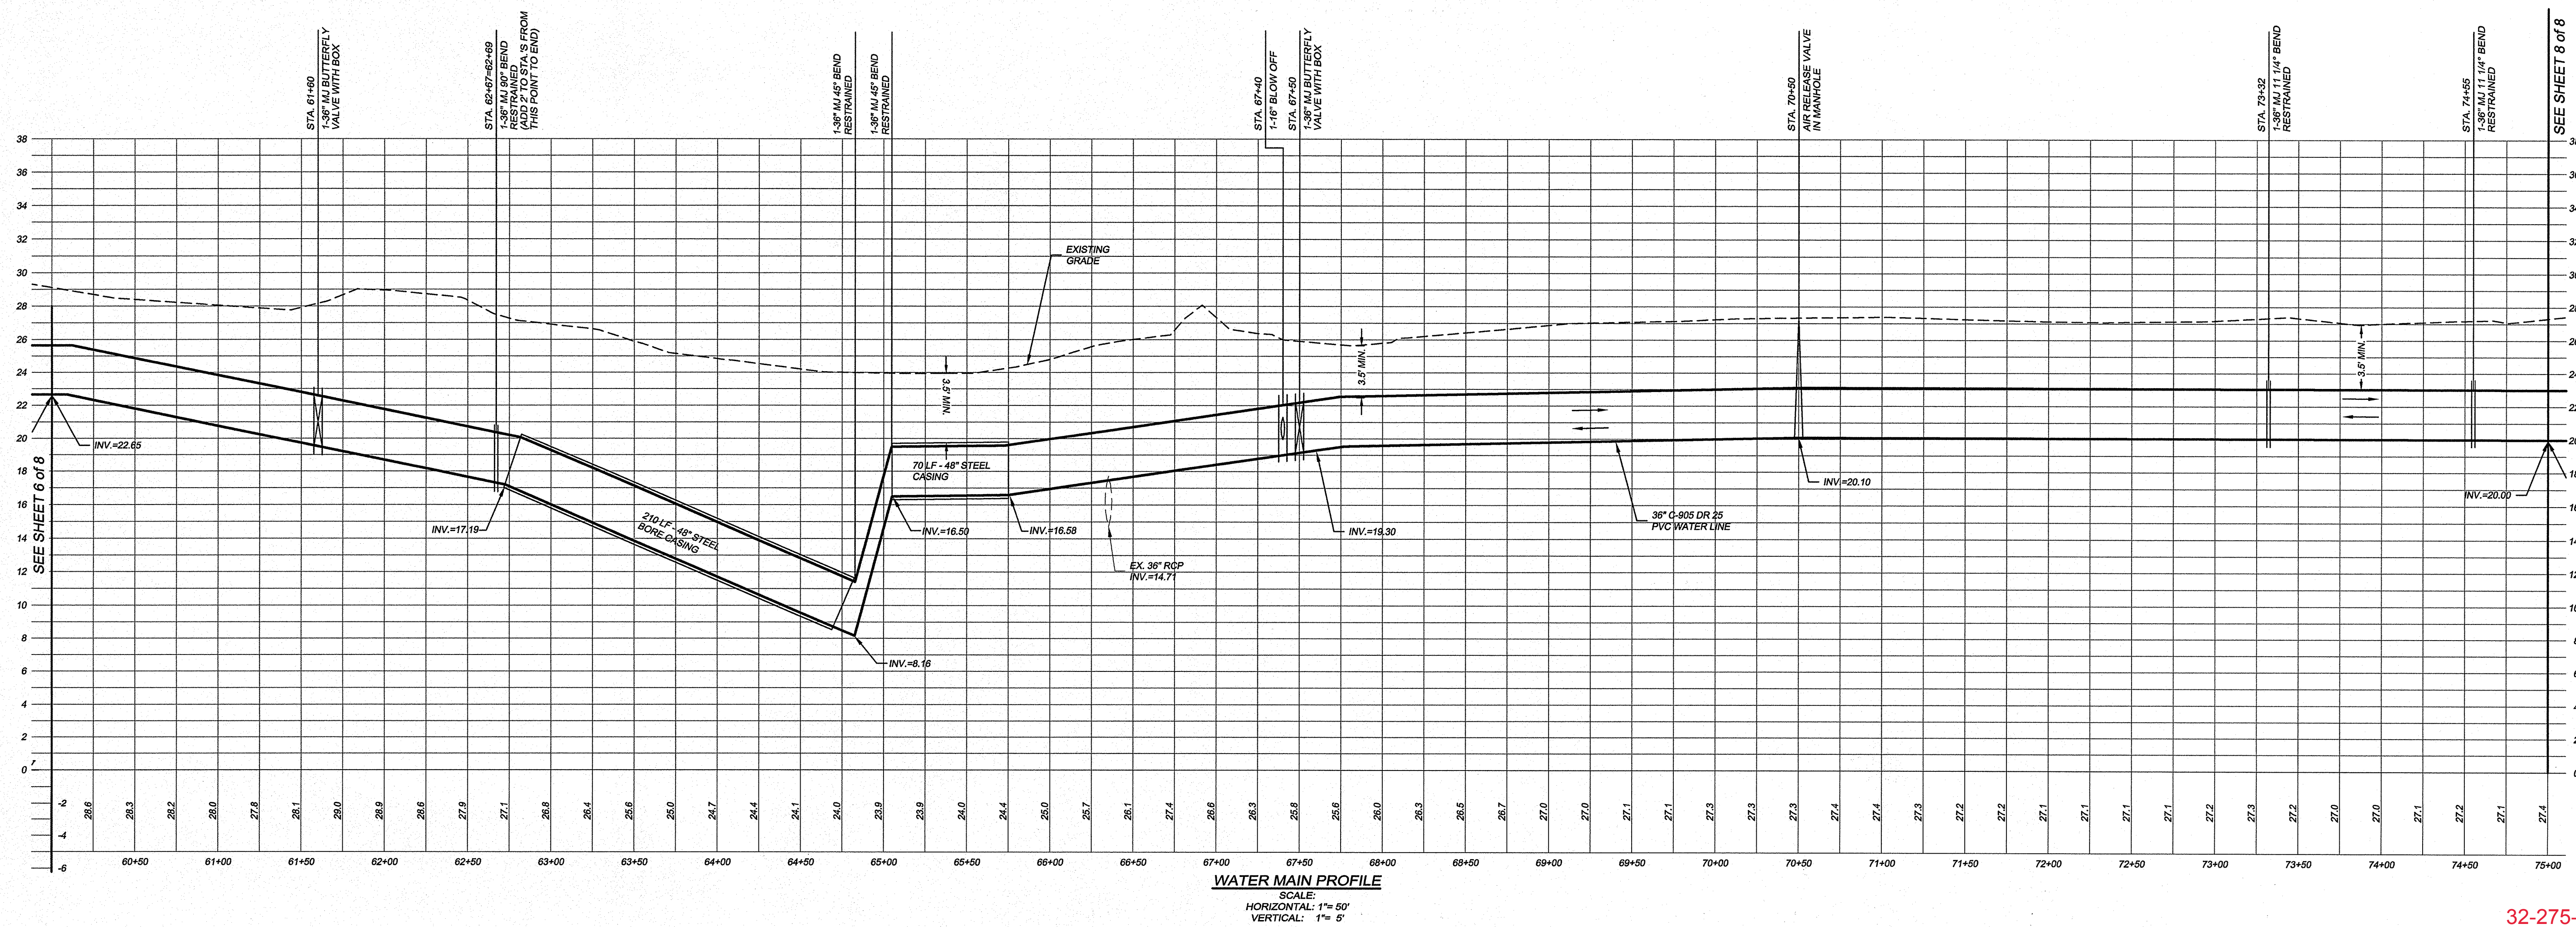[illegible]

**WATER MAIN PLAN & PROFILE
RECORD DRAWING**

GSW&SA / MB WATER LINE INTERCONNECTION PROJECT
Horry County, South Carolina

PREPARED FOR: GRAND STRAND WATER & SEWER AUTHORITY

SCALE:	AS SHOWN
DATE:	8/9/17
DESIGNED BY:	EKS
DRAWN BY:	PES / KJG
APPROV. BY:	EKS
PROJECT NO.:	14937E

