




MODIFICATIONS TO THE J. LAMBERT SCHWARTZ WASTEWATER TREATMENT PLANT

CONWAY, SOUTH CAROLINA
THE GRAND STRAND WATER AND SEWER AUTHORITY

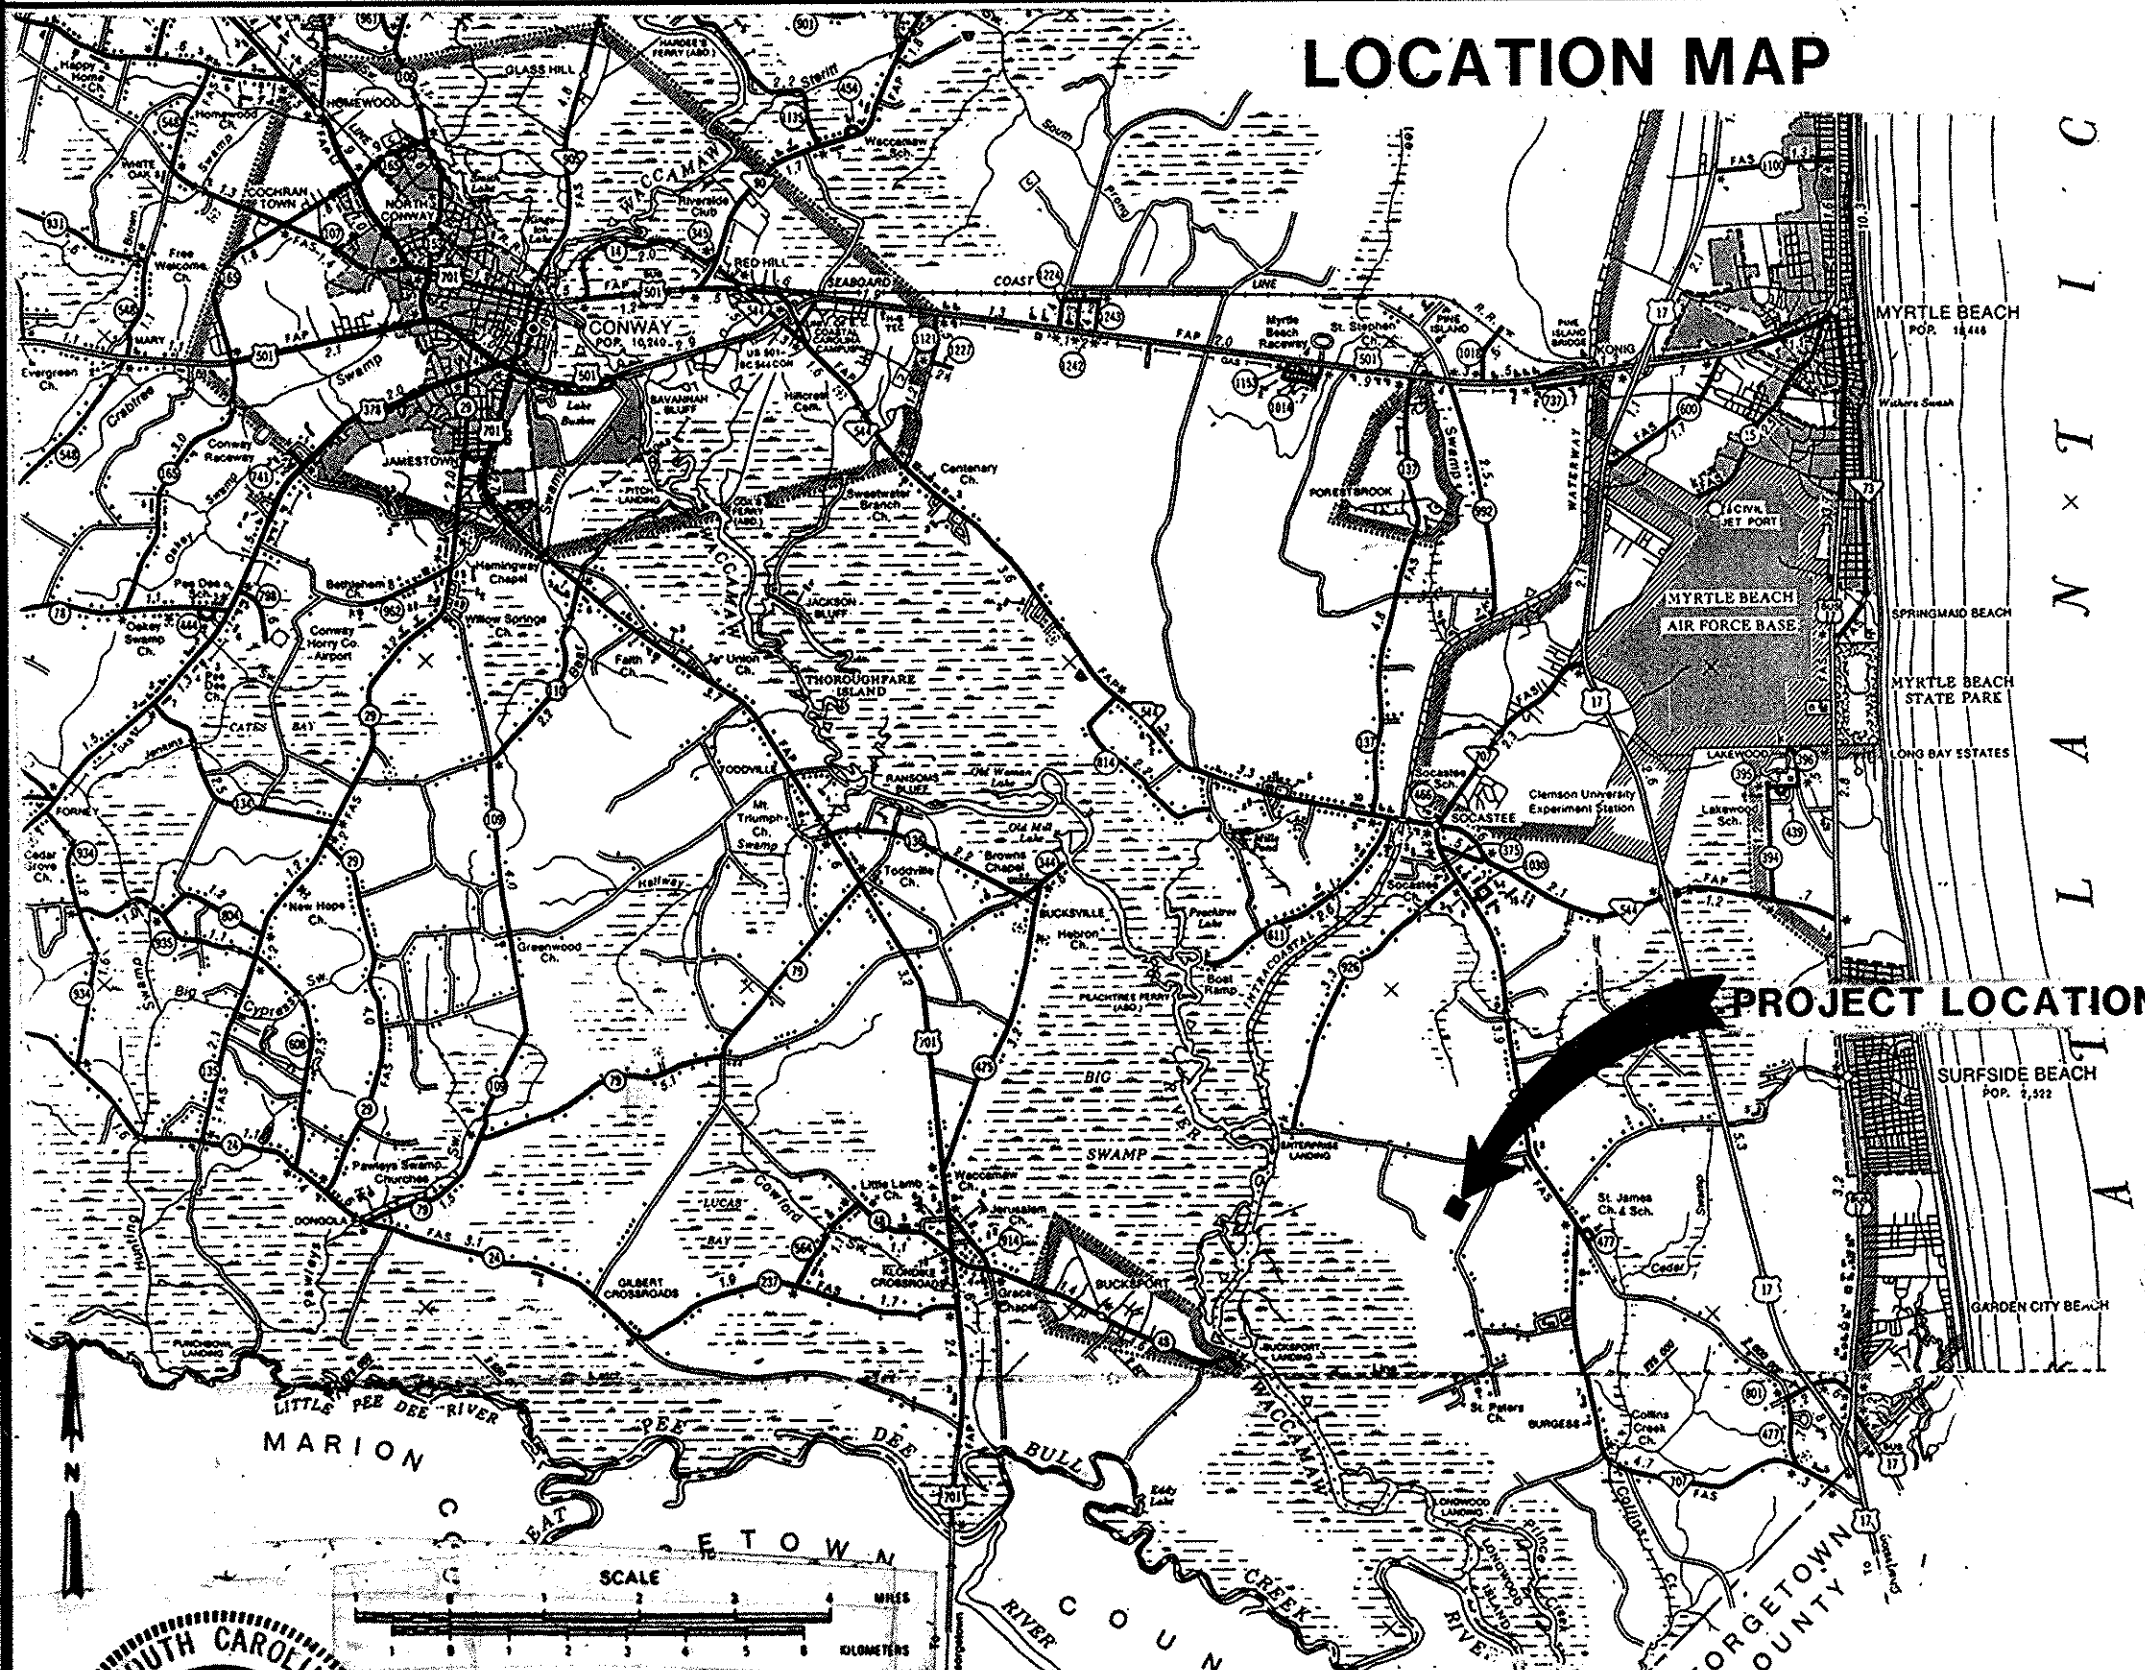

ABBREVIATIONS			
ALP	LOW PRESSURE AIR	H ₂ O ₂	HYDROGEN PEROXIDE
BM	BEAM	INV (INVT)	INVERT
BOT (BOTT)	BOTTOM	LG	LONG
CHKR	CHECKERED	MAX	MAXIMUM
CL	CENTER LINE	MC	MEDIUM CURE
Cl ₂	CHLORINE	MFR	MANUFACTURER
CLR	CLEAR	MGD	MILLION GALLONS PER DAY
CMU	CONCRETE MASONRY UNIT	MIN	MINIMUM
COL	COLUMN	MJ	MECHANICAL JOINT
CONC	CONCRETE	OC	ON CENTER
CONT	CONCRETE	OPNG	OPENING
COR	CORNER	PE	PLAIN END
CS	CHLORINE SOLUTION	PL	PLATE
CTR	CENTER	PVC	POLYVINYL CHLORIDE PIPE
CTRSK	COUNTERSUNK	RBC	ROTATING BIOLOGICAL CONTACTOR
DET	DETAIL	RC	RAPID CURE
DIA (d)	DIAMETER	RDCR	REDUCER
DIAG	DIAGONAL	REINF	REINFORCING STEEL
DIM	DIMENSION	REQD	REQUIRED
DIP	DUCTILE IRON PIPE	SCRW	SCREW
DWG	DRAWING	SIM	SIMILAR
EA	EACH	SPA (SPG)	SPACING
ECC	ECCENTRIC	SST	STAINLESS STEEL
EF	EACH FACE	STL	STEEL
EJ	EXPANSION JOINT	TS	TUBE STEEL
EL (ELEV)	ELEVATION	TYP	TYPICAL
EQL	EQUAL	VERT	VERTICAL
EW	EACH WAY	W/	WITH
EXST	EXISTING	WL	WATER LEVEL
FIG	FIGURE	WS	WATER STOP
GA	Gauge		
GALV	GALVANIZED		
GPM	GALLONS PER MINUTE		

DRAWING INDEX	
DRAWING NO.	TITLE
G-1	TITLE SHEET, LOCATION MAP, DRAWING INDEX, AND ABBREVIATIONS
G-2	PROCESS SCHEMATIC, HYDRAULIC PROFILE
G-3	MECHANICAL LEGEND
C-1	SITE PLAN
S-1	PREAERATION BASIN FOUNDATION PLAN
S-2	PREAERATION BASIN TOP PLAN
S-3	PREAERATION BASIN SECTIONS AND DETAILS
S-4	PREAERATION BASIN SECTIONS AND DETAILS
M-1	PREAERATION BASIN PLAN
M-2	PREAERATION BASIN SECTIONS AND DETAILS
M-3	ROTATING BIOLOGICAL CONTACTOR/HEADWORKS MODIFICATIONS
M-4	CHLORINATION BUILDING MODIFICATIONS
E-1	ELECTRICAL DETAILS AND LEGEND
E-2	SINGLE LINE AND MOTOR CONTROL DIAGRAMS
E-3	PREAERATION BASIN AND BLOWER FACILITY ELECTRICAL PLAN
E-4	ELECTRICAL PLAN AND EQUIPMENT ELEVATIONS
E-5	WIRING DIAGRAMS AND SCHEDULES
D-1	STRUCTURAL STANDARD DETAILS
D-2	STRUCTURAL STANDARD DETAILS
D-3	MECHANICAL STANDARD DETAILS

DSGN
R.J. PUCCIA

DR
THOMPSON/R. GILKESON

CHK
T.L. BELSER

APVD
R.A. HIRBEKORN

NO.

DATE

REVISION

BY

APVD

CH2M HILL

REUSE OF DOCUMENTS

THIS DOCUMENT, AND THE IDEAS AND DESIGNS INCORPORATED HEREIN, AS AN INSTRUMENT OF PROFESSIONAL SERVICE, IS THE PROPERTY OF CH2M HILL AND IS NOT TO BE USED, IN WHOLE OR IN PART, FOR ANY OTHER PROJECT WITHOUT THE WRITTEN AUTHORIZATION OF CH2M HILL.

VERIFY SCALES

BAR IS ONE INCH ON ORIGINAL DRAWING.

0 1"

IF NOT ONE INCH ON THIS SHEET, ADJUST SCALES ACCORDINGLY.

MODIFICATIONS TO THE J. LAMBERT SCHWARTZ WWTP

THE GRAND STRAND WATER AND SEWER AUTHORITY


TITLE SHEET, LOCATION MAP, DRAWING INDEX, AND ABBREVIATIONS

7-05-001-S


DWG NO. G-1

DATE AUG 1988

PROJ NO. SA 19793.A0

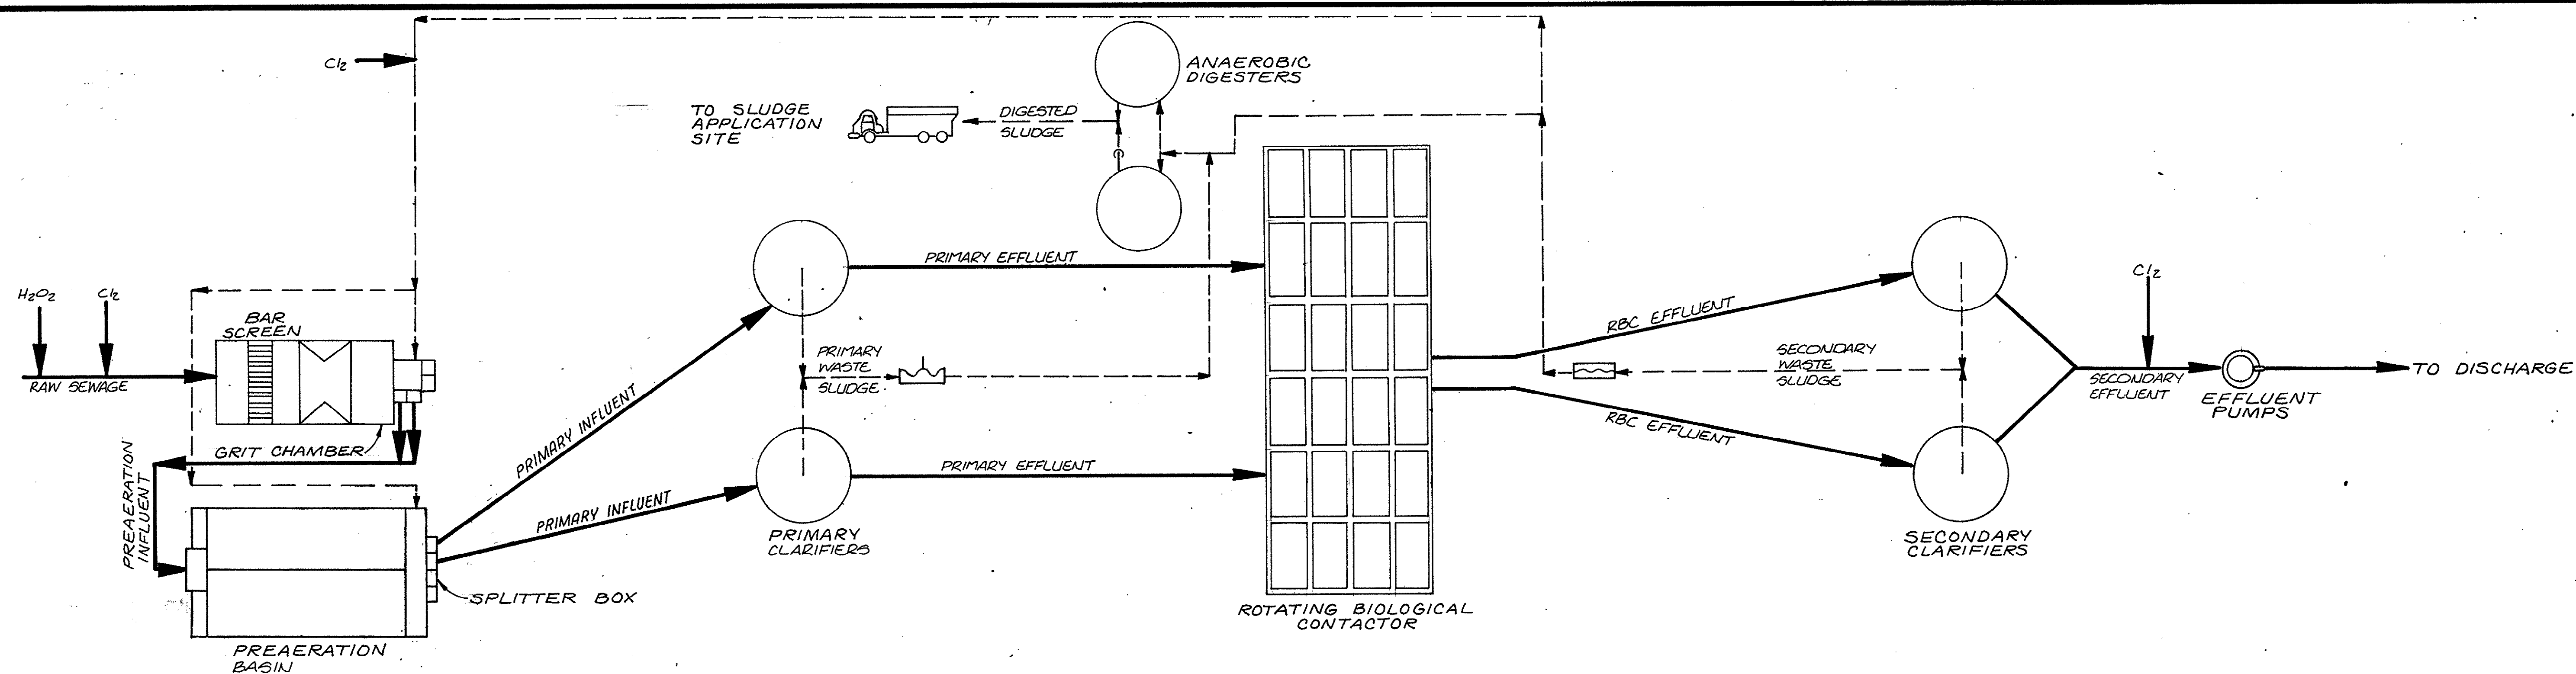


PROCESS SCHEMATIC

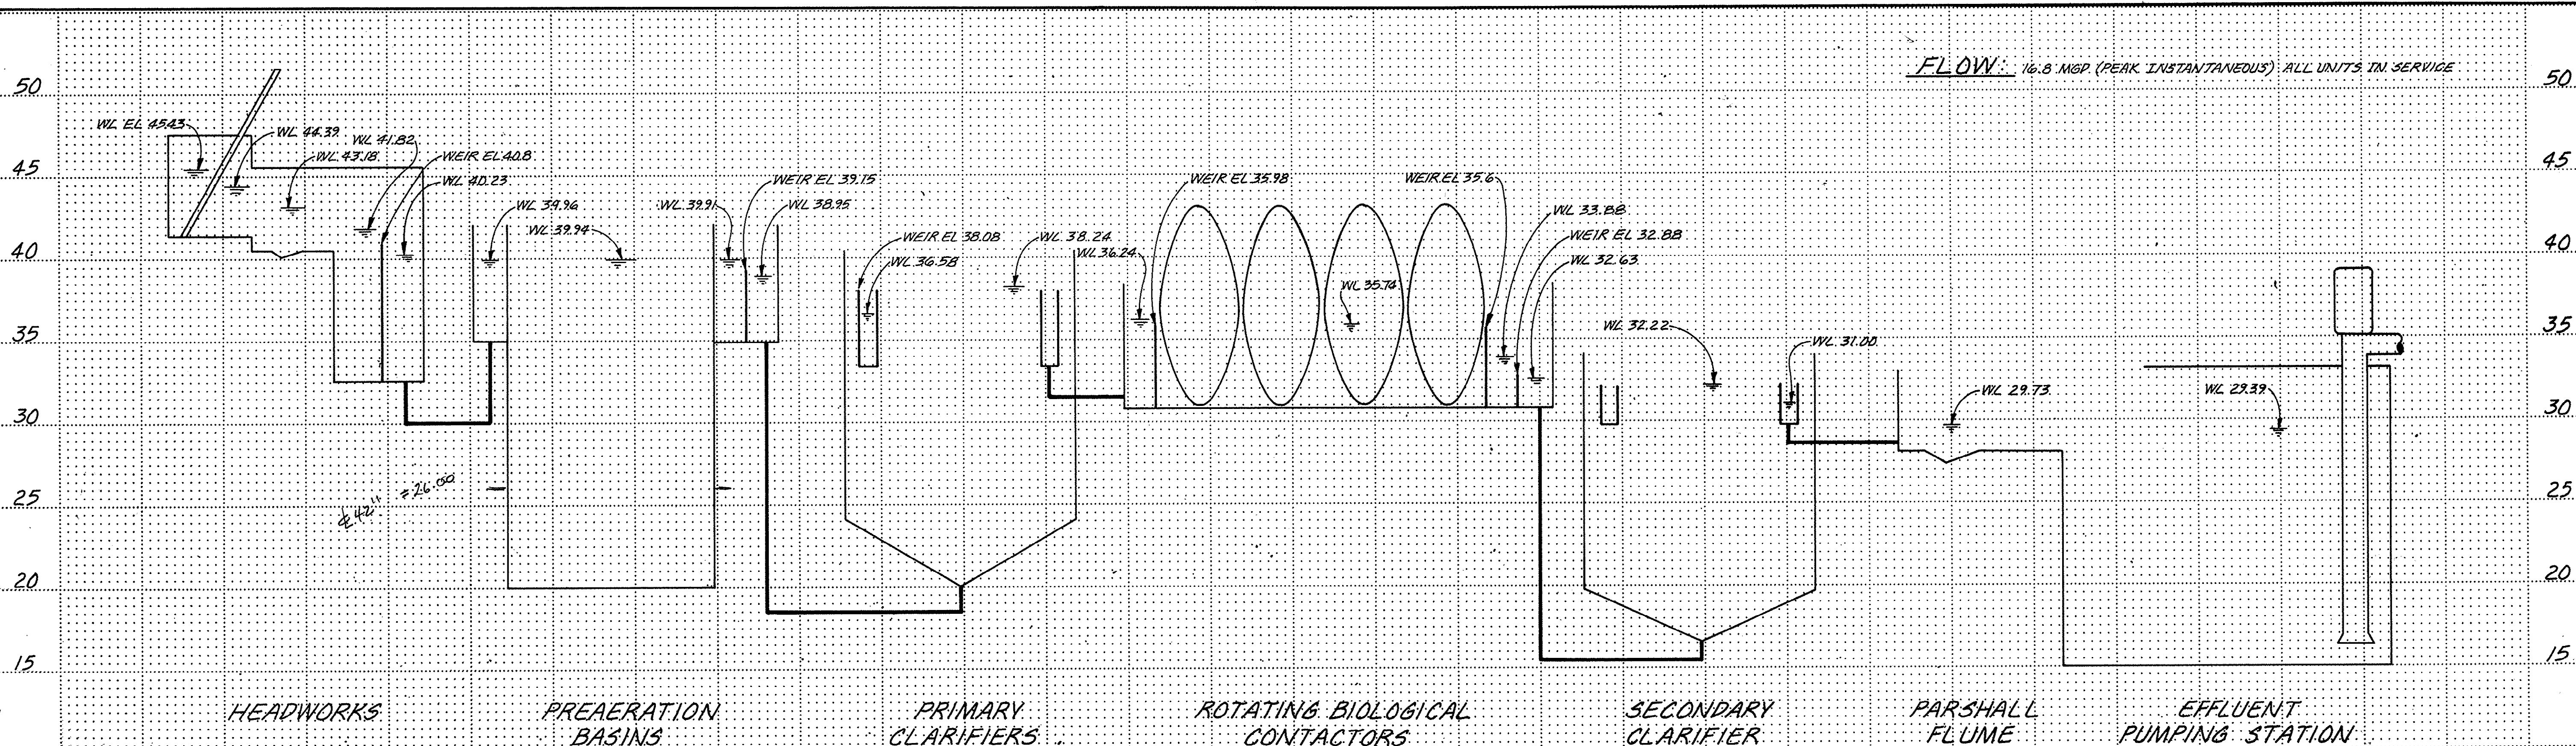

HYDRAULIC PROFILE

7-05-002-S

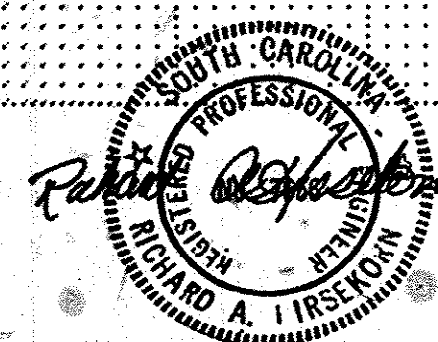

DSGN
R.J. PUCCIA
DR
R.A. GILKESON
CHK
L.L. BELSER
APVD
R.A. HIRSEKORN

NO.	DATE	REVISION	BY	APVD

REUSE OF DOCUMENTS
THIS DOCUMENT, AND THE IDEAS AND DESIGNS INCORPORATED HEREIN, AS AN INSTRUMENT OF PROFESSIONAL SERVICE, IS THE PROPERTY OF CH2M HILL AND IS NOT TO BE USED, IN WHOLE OR IN PART, FOR ANY OTHER PROJECT WITHOUT THE WRITTEN AUTHORIZATION OF CH2M HILL.

VERIFY SCALES
BAR IS ONE INCH ON ORIGINAL DRAWING.
0 1"
IF NOT ONE INCH ON THIS SHEET, ADJUST SCALES ACCORDINGLY.

MODIFICATIONS TO THE
J. LAMBERT SCHWARTZ WWTP
THE GRAND STRAND WATER AND SEWER AUTHORITY

PROCESS SCHEMATIC, HYDRAULIC PROFILE

DATE **AUG 1988**
PROJ NO. **SA19793.A0**

PIPE AND FITTING SYMBOLS

DOUBLE LINE	SINGLE LINE	
		EXISTING PIPE
		NEW PIPE
		EXISTING PIPE TO BE ABANDONED
		EXISTING PIPE TO BE REMOVED
		WELDED JOINT
		FLANGED JOINT
		MECHANICAL JOINT
		BELL & SPIGOT JOINT
		HUB & SPIGOT JOINT (RUBBER GASKET)
		BALL JOINT
		FLANGE COUPLING ADAPTOR
		FLEXIBLE COUPLING
		FLEXIBLE COUPLING WITH THRUST TIES
		STEEL BELLOWS EXP JOINT
		ELASTOMER BELLOWS EXP JOINT
		ELBOW UP
		ELBOW DOWN
		TEE UP
		TEE DOWN
		LATERAL UP
		LATERAL DOWN
		CONCENTRIC REDUCER
		ECCENTRIC REDUCER
		UNION

	CAP
	ANCHOR
	ELBOW, 90 DEGREE
	CROSS
	TEE
	ELBOW, 45 DEGREE
	LATERAL

NOTES:

1. ONLY FLANGED END CONNECTIONS ARE SHOWN HERE FOR DOUBLE LINE FITTINGS. FITTINGS WITH OTHER END PATTERNS ARE SHOWN SIMILARLY ON THE CONSTRUCTION DRAWINGS. ALSO SEE PIPING SPECIFICATIONS.

2. SYMBOLS SHOWN HERE FOR SINGLE LINE FITTINGS ARE GENERIC ONLY. REFER TO PIPING SPECIFICATIONS FOR SPECIFIC END CONNECTIONS FOR SINGLE LINE PIPE AND FITTINGS.

3. EXISTING PIPING AND EQUIPMENT IS SHOWN LIGHT-LINED AND/OR SCREENED AND IS ALWAYS NOTED AS EXISTING. NEW PIPING AND EQUIPMENT IS SHOWN HEAVY-LINED.

GATE SYMBOLS

EL. VIEW	PLAN VIEW	
		SLUICE
		FABRICATED SLIDE

SITE LEGEND

	FENCE
	EXISTING STRUCTURE TO BE REMOVED
	EXISTING A.C. PAVEMENT
	NEW A.C. PAVEMENT
	CONCRETE WALK (EXISTING SCREENED)
	EXISTING CONTOUR
	NEW CONTOUR
	EXISTING EMBANKMENT - SLOPE AS INDICATED
	NEW EMBANKMENT - SLOPE AS INDICATED
	EXISTING GRADE
	FINISH GRADE

NOTE: IN GENERAL, EXISTING STRUCTURES AND FACILITIES ARE NOTED AS "EXISTING" AND ARE SHOWN IN LIGHT LINE WEIGHTS, OR AS SCREENED BACKGROUND. NEW STRUCTURES ARE SHOWN IN HEAVY LINE WEIGHTS.


VALVE SYMBOLS

	GATE
	BUTTERFLY
	GLOBE
	BALL
	SEAT PORT
	ECCENTRIC PLUG
	PLUG OR COCK
	DIAPHRAGM
	PINCH
	SWING CHECK
	BALL CHECK
	HOSE VALVE (HV- X) OR (V- X) X = NO. IN SPECS
	MUD
	PRESSURE RELIEF
	AIR AND/OR VACUUM RELEASE
	REGULATED SIDE
	PRESSURE CONTROL
	MULTI-PORT VALVE (BALL VALVE SHOWN. FOR OTHER VALVE TYPES, APPROPRIATE VALVE SYMBOL SHOWN.) ARROWS INDICATE FLOW PATTERN. SEAT PORTS ARE IMPLIED BY INDICATED FLOW PATTERN.
	NON-FREEZE HOSE VALVE (V-X) X = NO. IN SPECIFICATIONS
	NON-FREEZE HOSE VALVE WITH HOSE RACK (V-X) X = NO. IN SPECIFICATIONS
	KNIFE GATE

SELF CONTAINED VALVE & EQUIPMENT TAG NUMBERS


D-W-X-Y	D: P = PUMP T = TANK M = MECHANICAL EQUIPMENT G = GATE E = EJECTOR PSE = RUPTURE DISK ARV = AIR RELEASE VALVE AVRV = AIR AND VACUUM RELEASE VALVE PSV = PRESSURE RELIEF VALVE PCV = PRESSURE CONTROL VALVE LCV = LEVEL CONTROL VALVE TCV = TEMPERATURE CONTROL VALVE VRV = VACUUM RELEASE VALVE
	W = UNIT PROCESS NUMBER X = LOOP NUMBER Y = UNIT NUMBER

PIPING DESIGNATION

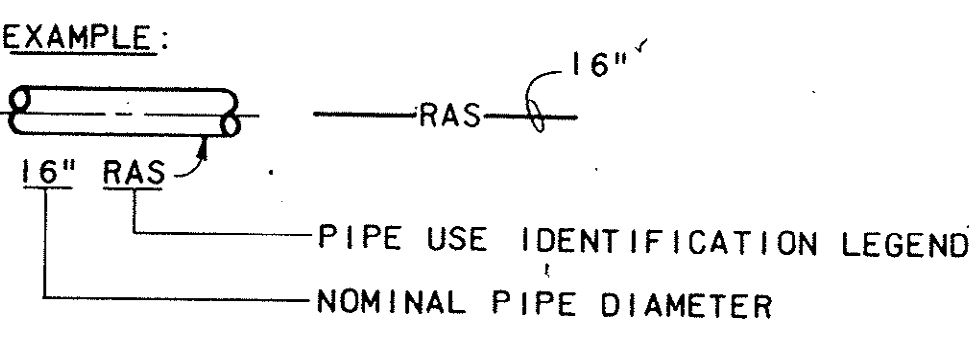


VALVE DESIGNATIONS

MANUAL VALVES AND CHECK VALVES

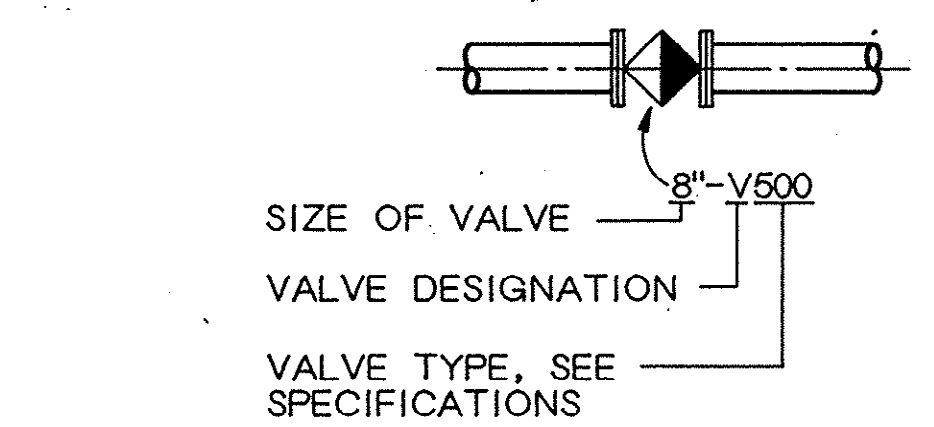

CONTROL VALVES

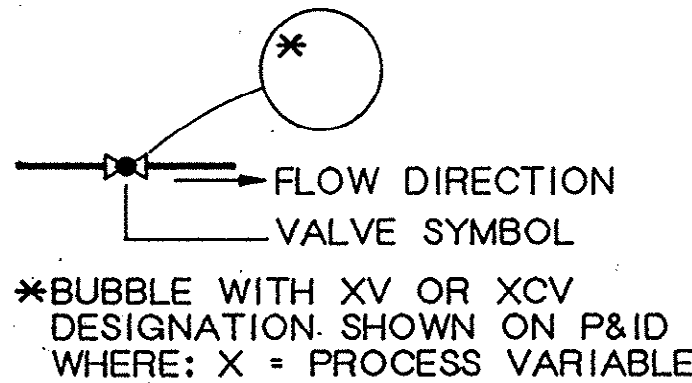

SECTION (LETTER) OR DETAIL (NUMERAL) DESIGNATION	ON DRAWING WHERE SECTION OR DETAIL IS TAKEN:
A	SHEET NUMBER WHERE SHOWN
21-M-2	ON DRAWING WHERE SECTION OR DETAIL IS SHOWN:
	SHEET NUMBER(S) WHERE TAKEN

DETAIL AND SECTION DESIGNATION

7-05-003-S

THIS IS A STANDARD LEGEND. THEREFORE, NOT ALL OF THIS INFORMATION MAY BE USED ON THIS PROJECT.



DSGN	V. BATES				
DR	H. HOLLOWAY				
CHK	V. BATES				
APVD	R.A. HIRSEKORN	NO.	DATE	REVISION	BY

REUSE OF DOCUMENTS

THIS DOCUMENT, AND THE IDEAS AND DESIGNS INCORPORATED HEREIN, AS AN INSTRUMENT OF PROFESSIONAL SERVICE, IS THE PROPERTY OF CH2M HILL AND IS NOT TO BE USED, IN WHOLE OR IN PART, FOR ANY OTHER PROJECT WITHOUT THE WRITTEN AUTHORIZATION OF CH2M HILL.

VERIFY SCALES

BAR IS ONE INCH ON ORIGINAL DRAWING.

IF NOT ONE INCH ON THIS SHEET, ADJUST SCALES ACCORDINGLY.

MODIFICATIONS TO THE





J. LAMBERT SCHWARTZ WWTTP

THE GRAND STRAND WATER AND SEWER AUTHORITY

MECHANICAL LEGEND


DWG NO.	G-3
DATE	AUG 1985
PROJ NO.	SA19793-A0*

OVERLAY IDENTIFICATION						FORMAT		FILM KE		PRINTED		84	
					COMPOSITE								
					PROJ NO.								
					OVERLAY								
					SCREEN								
					CONTRACT								

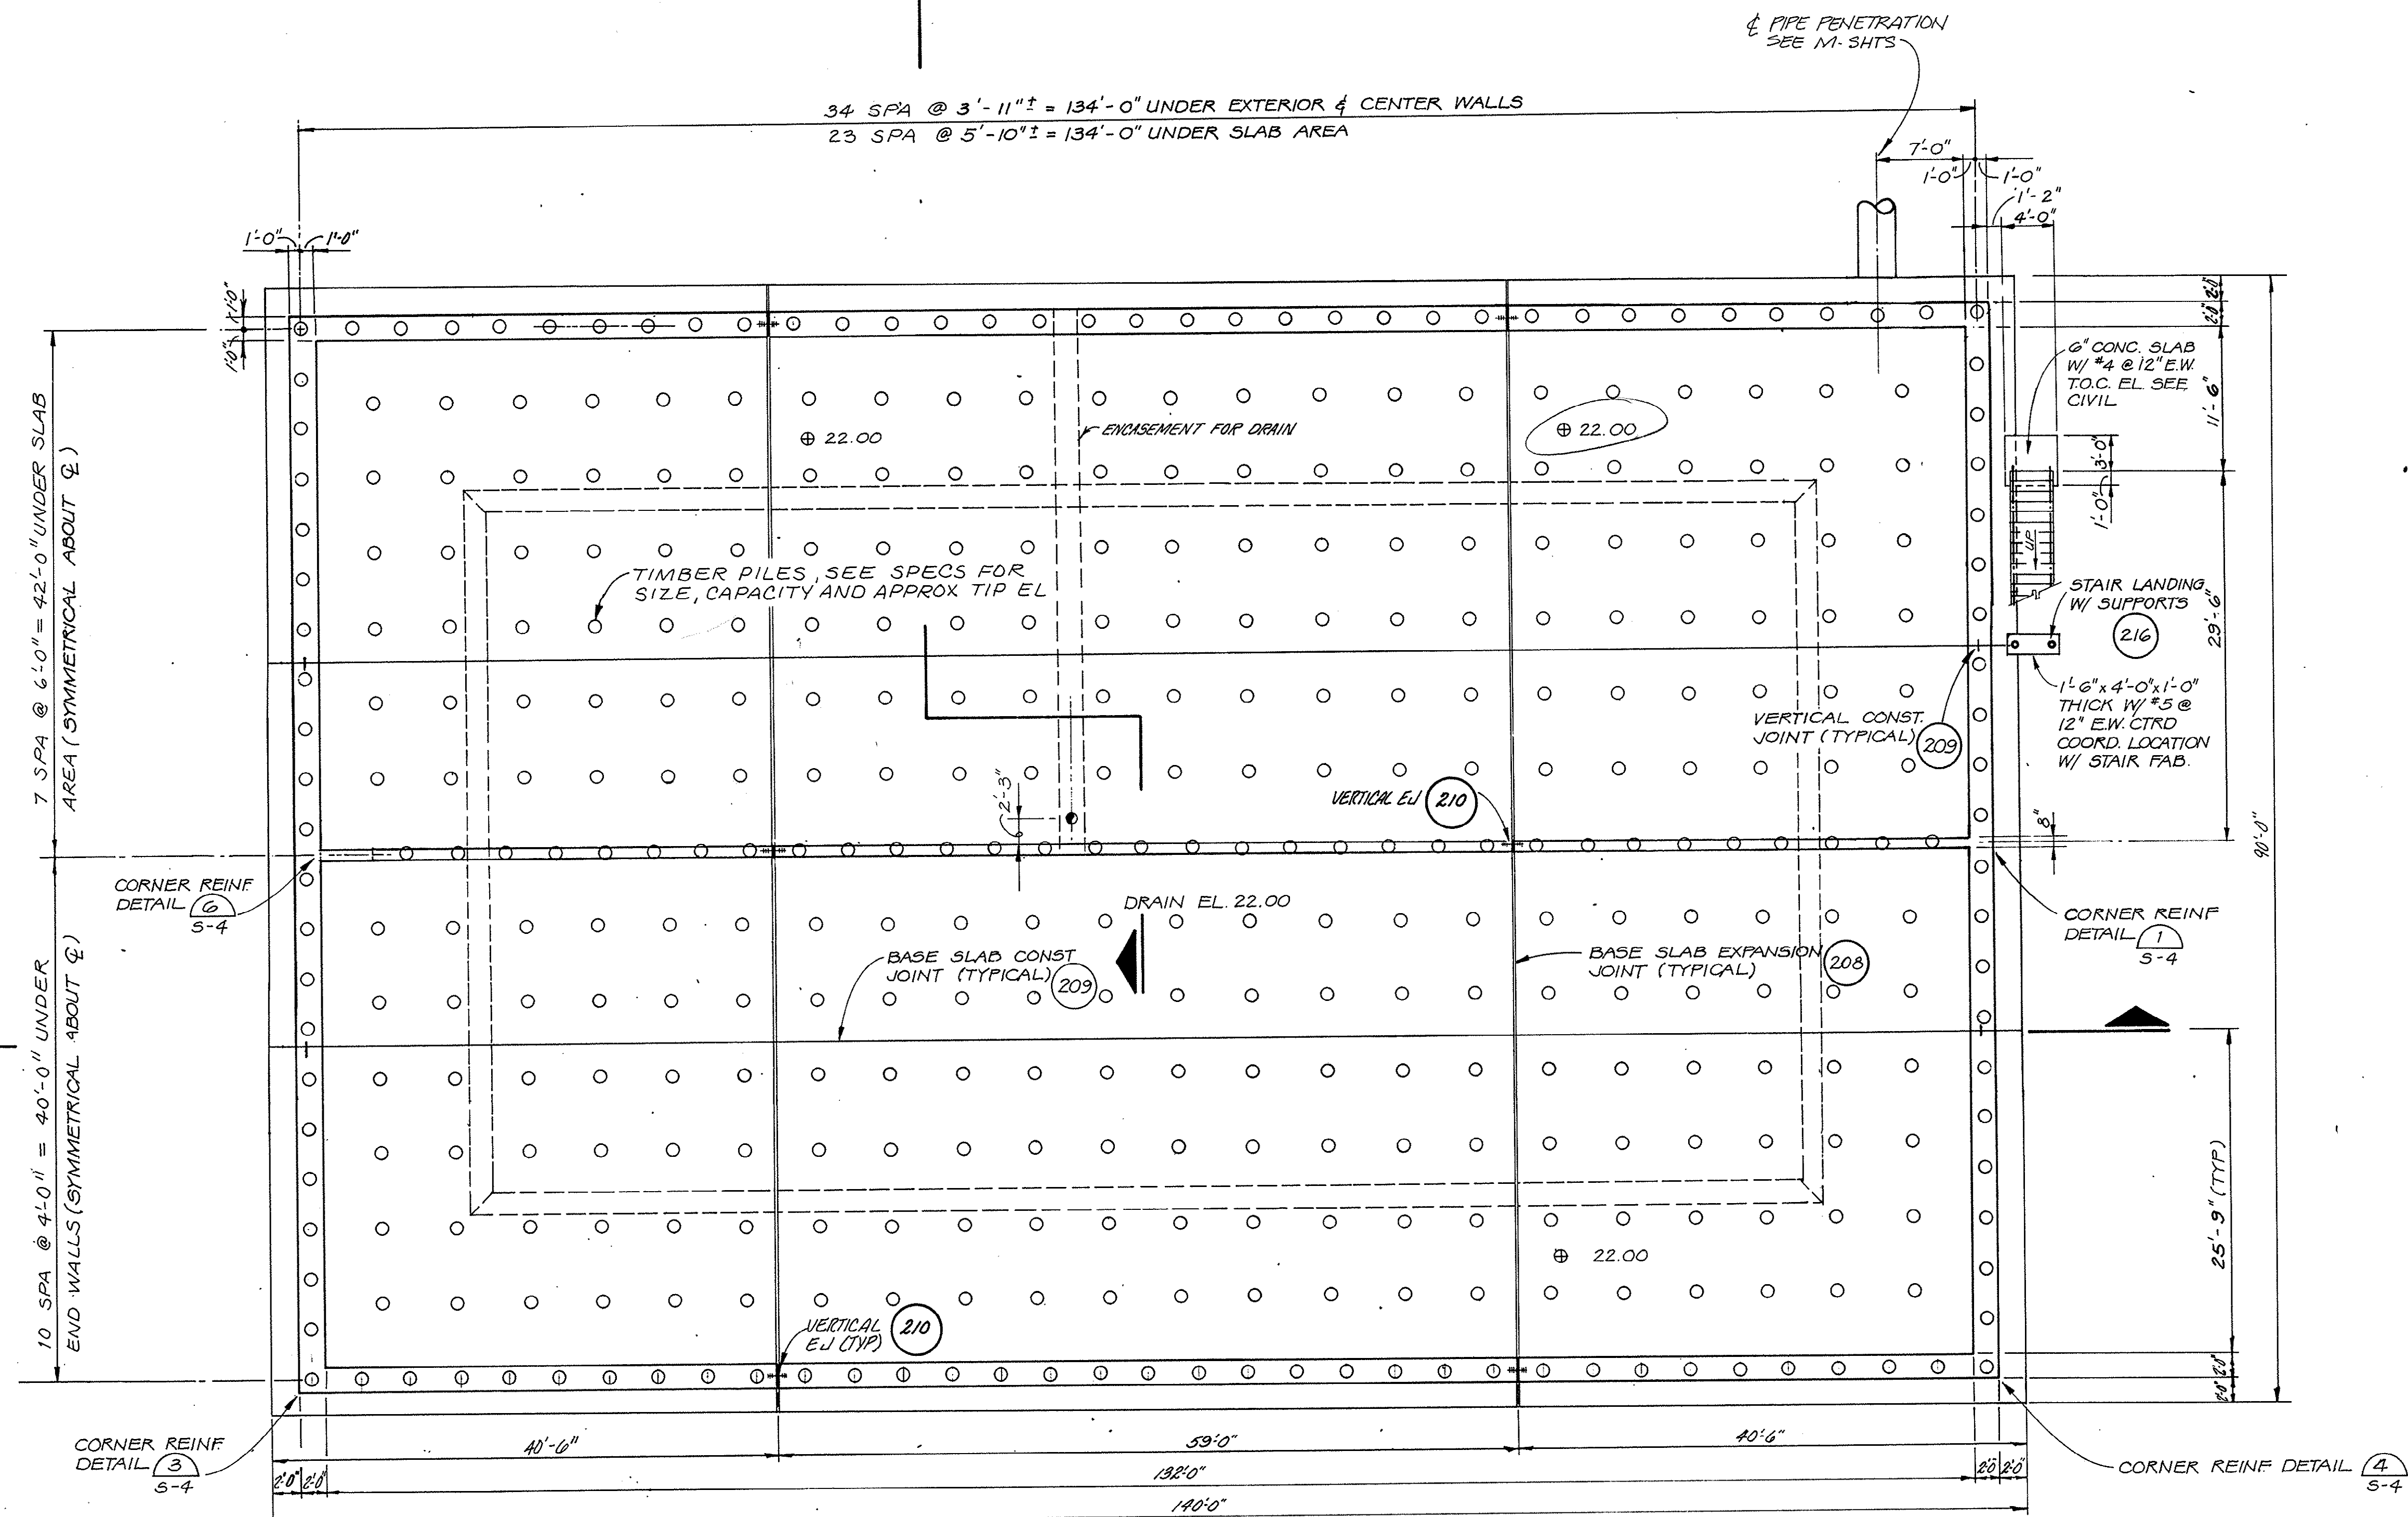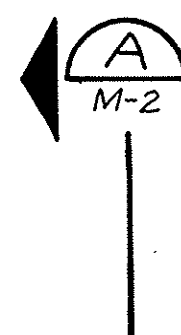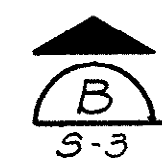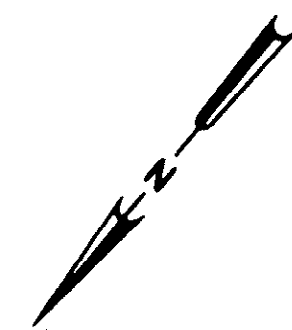

PRE-AERATION BASIN - PILE AND FOUNDATION PLAN
1/8" = 1'-0"

7-05-005-S

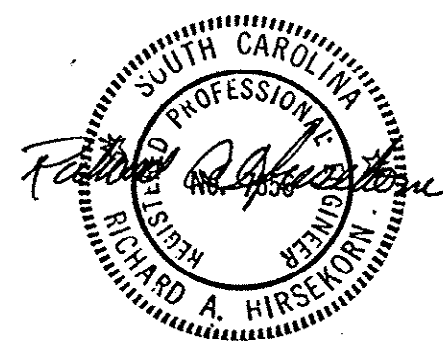

	DSGN	J.D. MAXFIELD					REUSE OF DOCUMENTS	VERIFY SCALES	MODIFICATIONS TO THE	PRE - AERATION BASIN FOUNDATION PLAN	SHEET
	DR.	M.C. FURNHAM					THIS DOCUMENT, AND THE IDEAS AND DESIGNS INCORPORATED HEREIN, AS AN INSTRUMENT OF PROFESSIONAL SERVICE, IS THE PROPERTY OF CH2M HILL AND IS NOT TO BE USED, IN WHOLE OR IN PART, FOR ANY OTHER PROJECT WITHOUT THE WRITTEN AUTHORIZATION OF CH2M HILL.	BAR IS ONE INCH ON ORIGINAL DRAWING: 0 _____ 1"	J. LAMBERT SCHWARTZ WWTP		DWG NO. S-1
	CHK	B. JOHNSON						IF NOT ONE INCH ON THIS SHEET, ADJUST SCALES ACCORDINGLY.	THE GRAND STRAND WATER AND SEWER AUTHORITY		DATE AUG 1985
	APVD	R.A. HIRSEKORN	NO.	DATE	REVISION	BY	APVD	©CH2M HILL			PROJ NO. SA 19793.AO



SHEET	
DWG NO.	S-2
DATE	AUG 1985
PROJ NO.	SA19793-A0

OVERLAY IDENTIFICATION		COMPOSITE	JOURNAL	SEQUENCE	FILM RE	PRINTED	10	84
PROJ NO.		OVERLAY		M-3-2				
CONTRACT		SCREEN		M-3-2				
				M-3-1				



DSGN	V. BATES/J. MAXFIELD
DR	R.A. GILKESON
CHK	T.L. BELSER
APVD	R.A. HIRSEKORN

NO.	DATE	REVISION	BY APV

REUSE OF DOCUMENTS
THIS DOCUMENT, AND THE IDEAS AND DESIGNS INCORPORATED HEREIN, AS AN INSTRUMENT OF PROFESSIONAL SERVICE, IS THE PROPERTY OF CH2M HILL AND IS NOT TO BE USED, IN WHOLE OR IN PART, FOR ANY OTHER PROJECT WITHOUT THE WRITTEN AUTHORIZATION OF CH2M HILL.

©CH2M HILL

VERIFY SCALES
 BAR IS ONE INCH ON
 ORIGINAL DRAWING.
 0  1"
 IF NOT ONE INCH ON
 THIS SHEET, ADJUST
 SCALES ACCORDINGLY.


**MODIFICATIONS
TO THE
J. LAMBERT SCHWARTZ WWTP

THE GRAND STRAND
WATER AND SEWER AUTHORITY**


PRE-AERATION BASIN SECTIONS AND DETAILS

DWG NO.	S-3
DATE	AUG 1985
PROJ NO.	SA 19793.A0


V.N. DAVID / ENG.

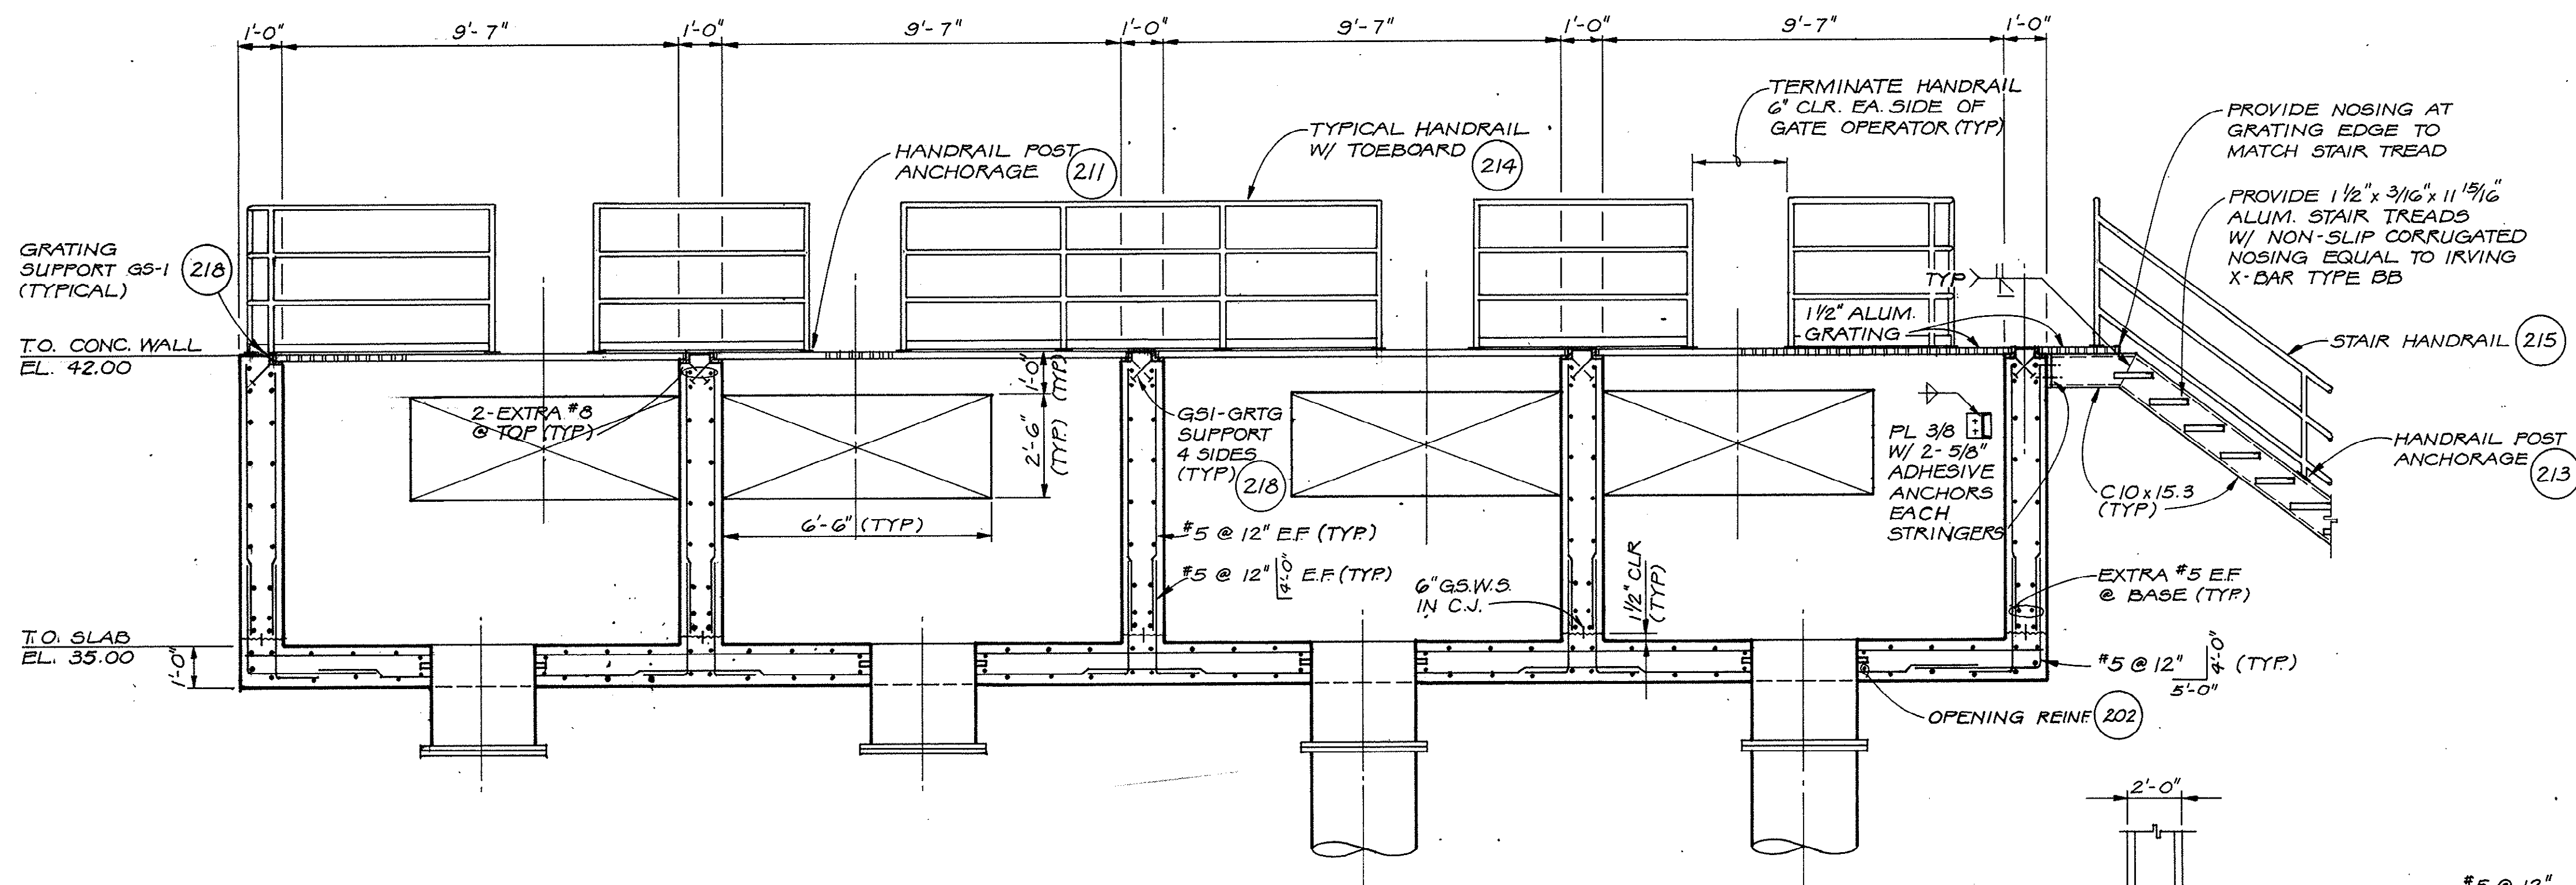

SECTION C
3/8" = 1'-0" S-2

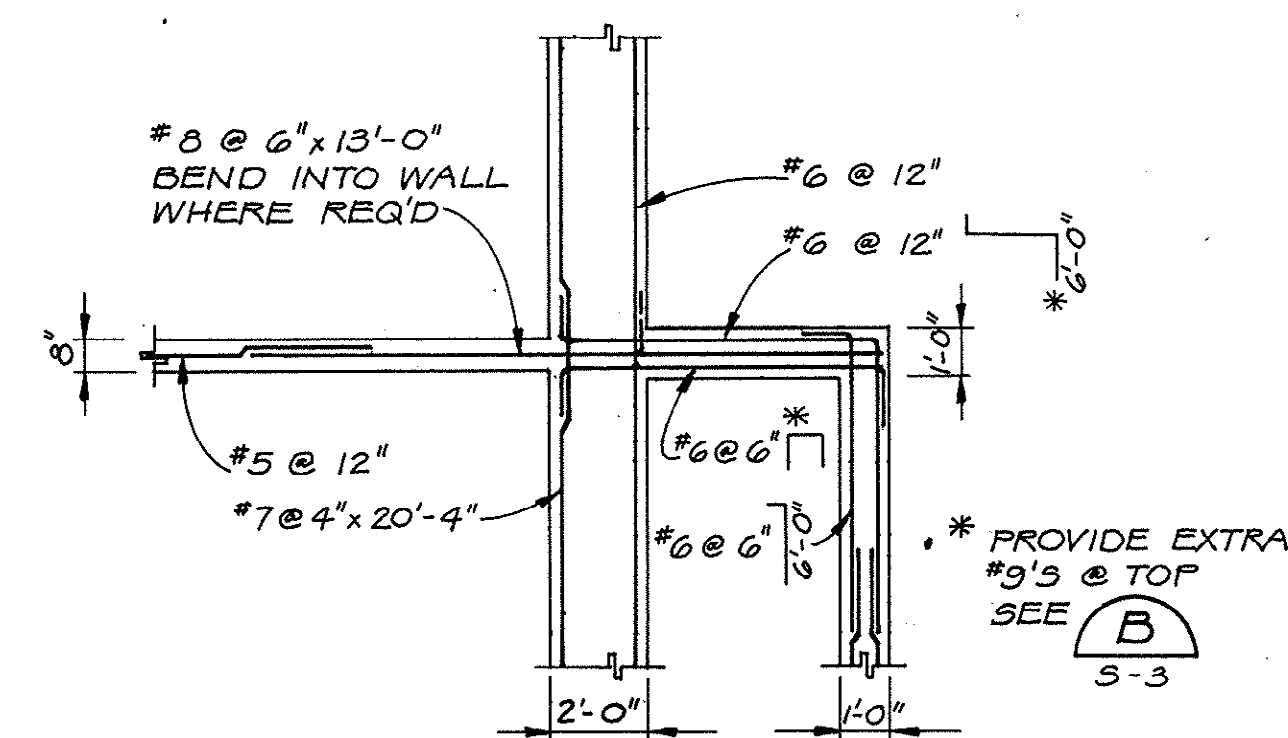


CORNER REINF. DETAIL 1
NTS S-2

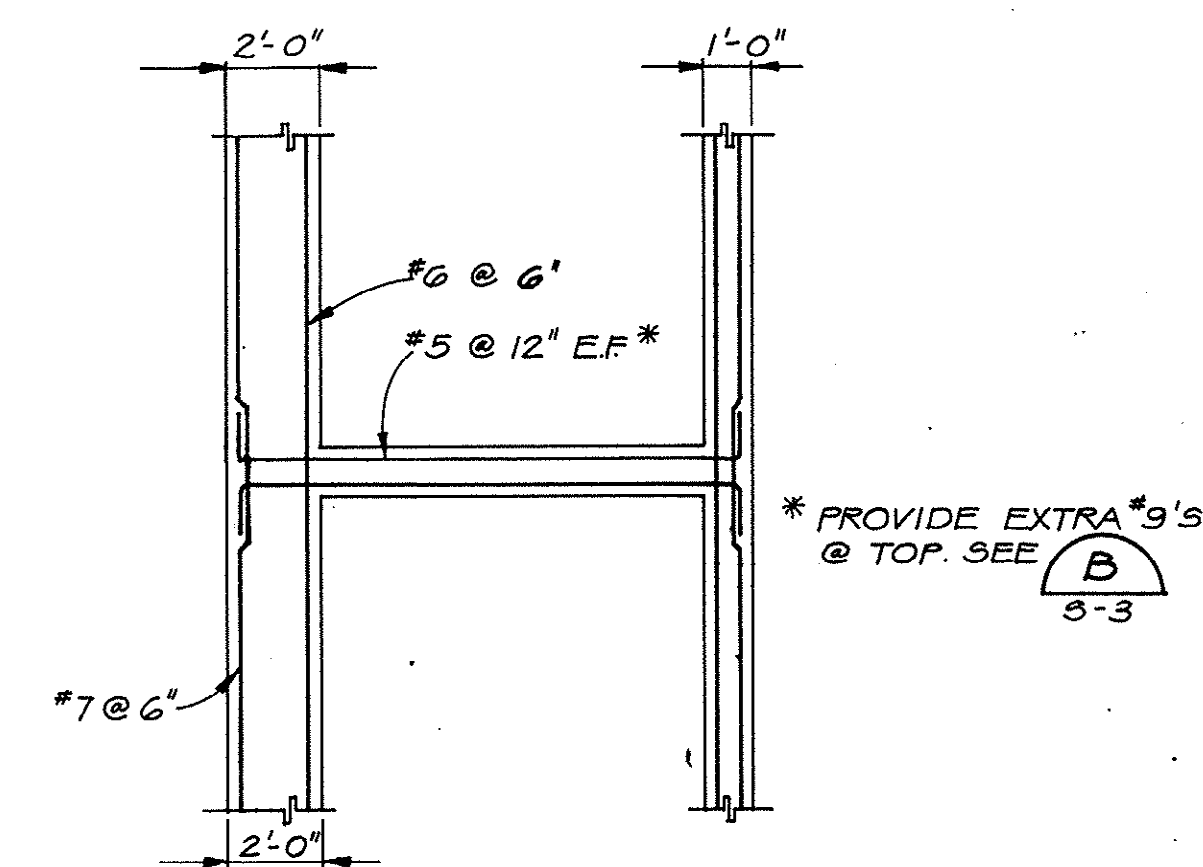


CORNER REINF. DETAIL 6
NTS S-2


CORNER REINF. DETAIL 2
NTS (TYPICAL 3 PLACES) S-2

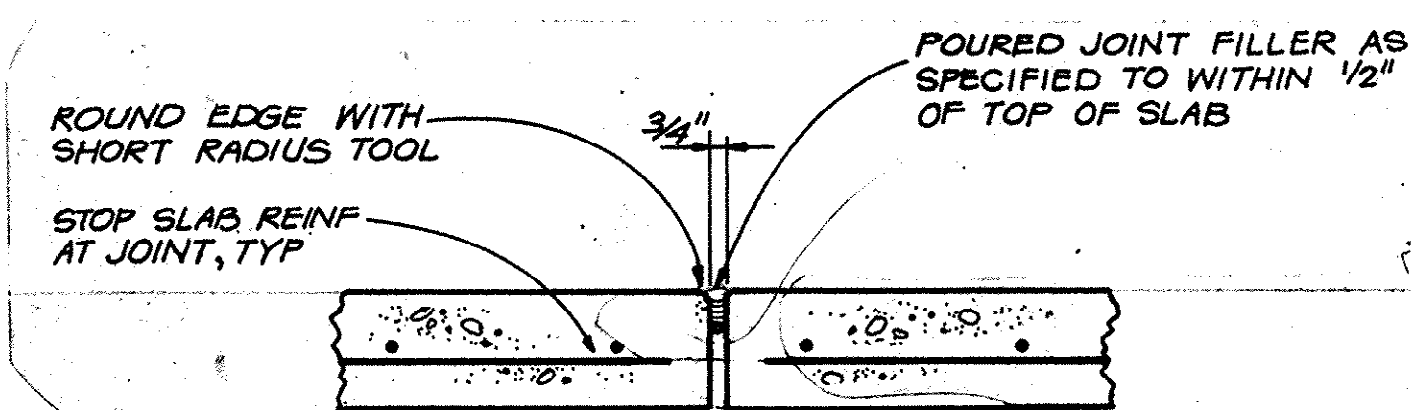


ELEVATED SLAB
EXPANSION JOINT 5
NTS S-2

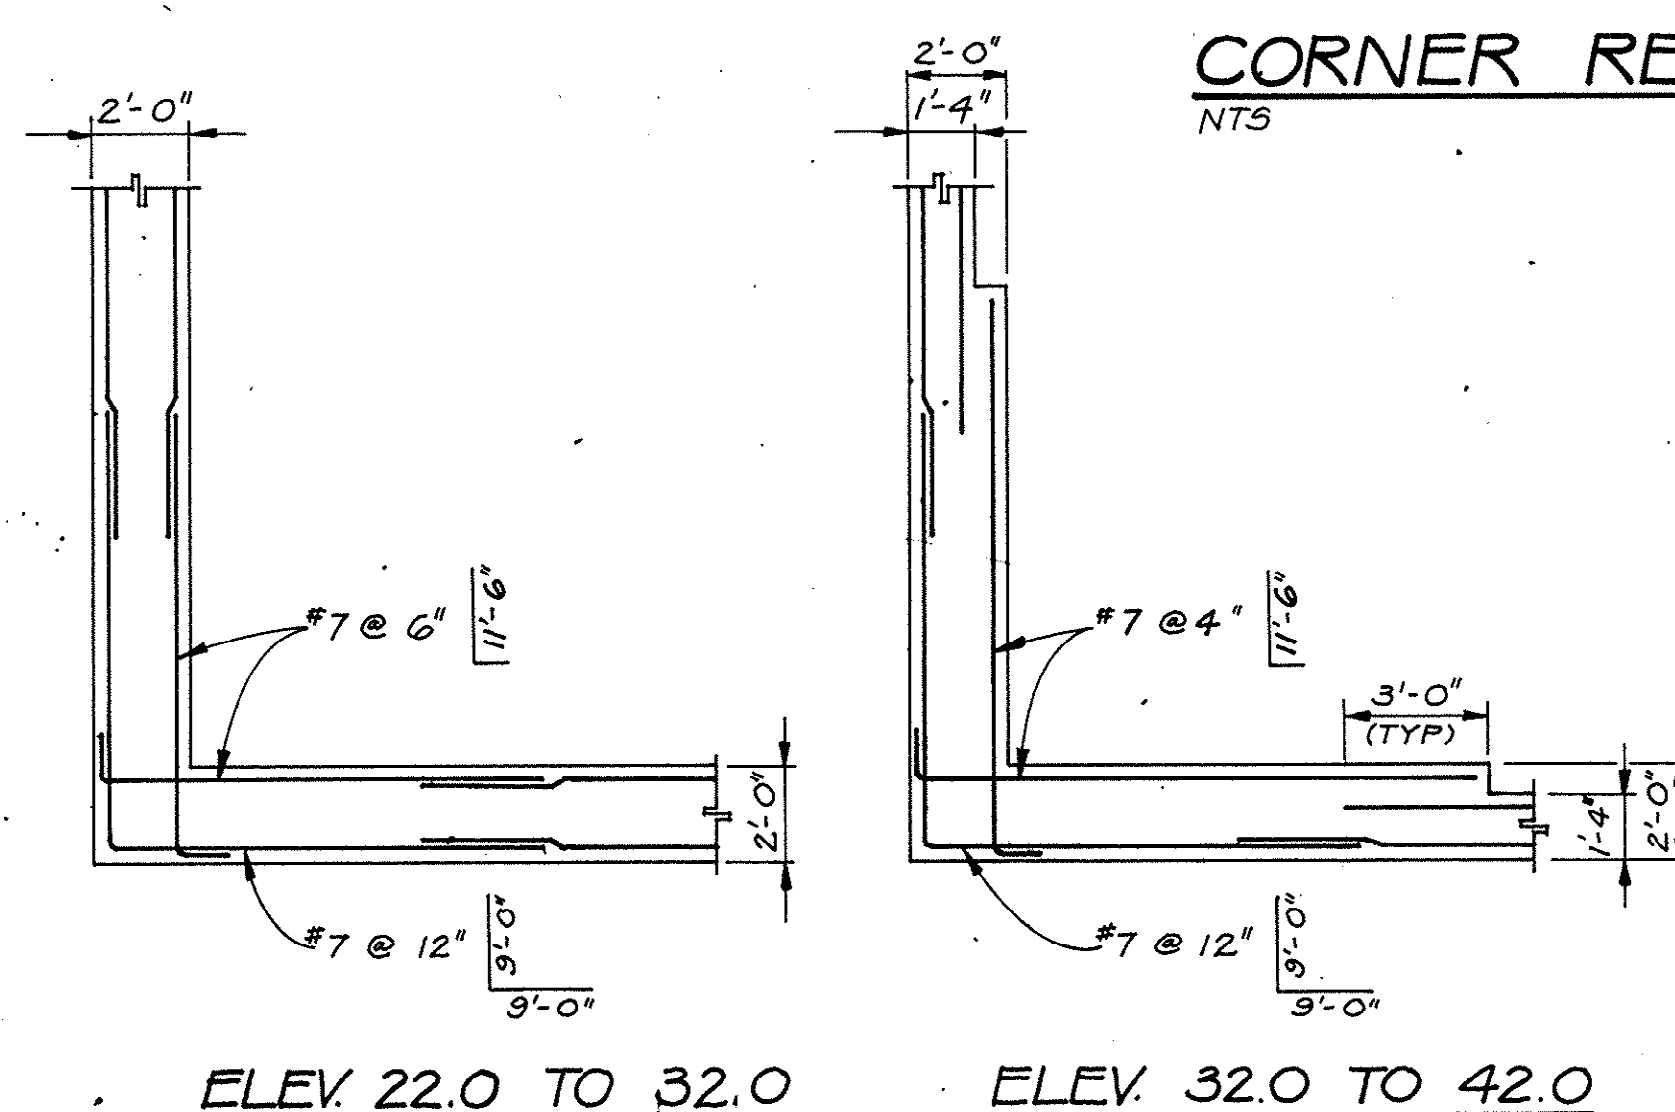

CORNER REINF. DETAIL 3
NTS S-2

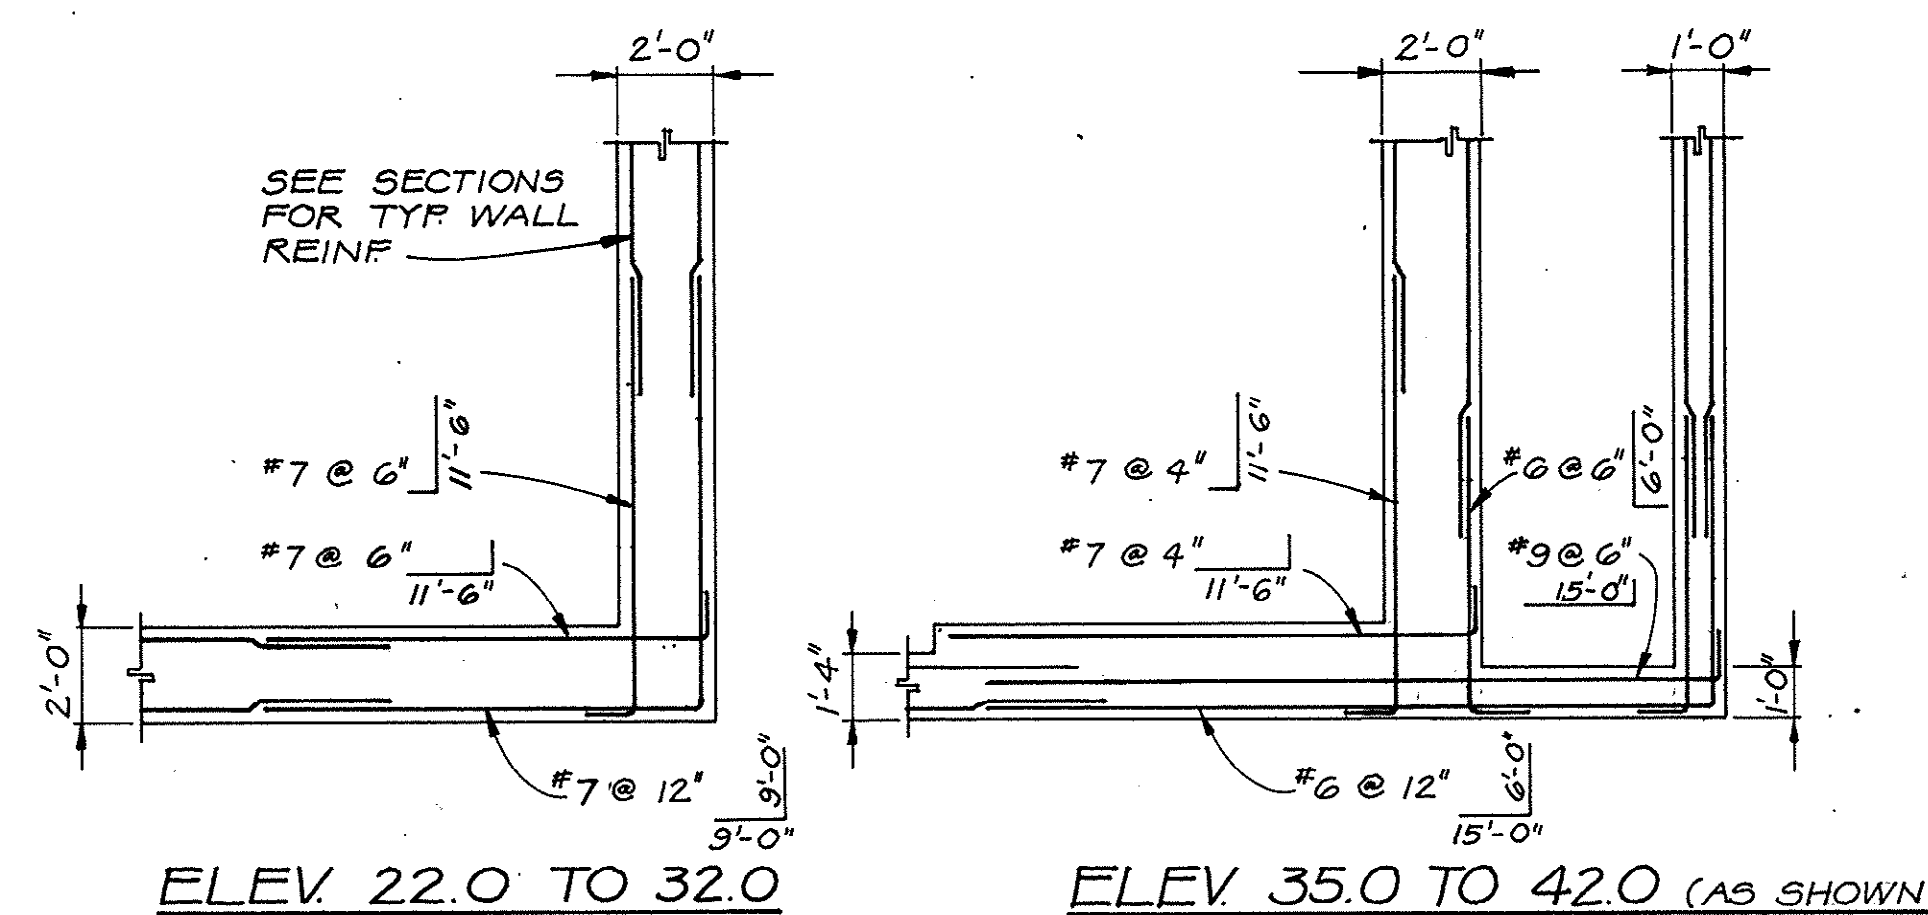

CORNER REINF. DETAIL 4
NTS S-2

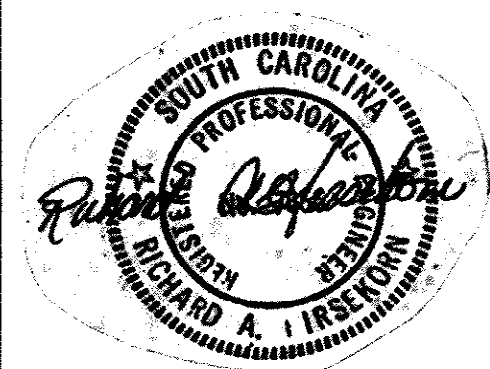

DSGN J.B. WORCESTER
DR V.N. DAVID
CHK J.D. MAXFIELD
B. JOHNSON
APVD R.A. HIRSEKORN

NO. DATE

REVISION

BY

APVD

REUSE OF DOCUMENTS
THIS DOCUMENT, AND THE IDEAS AND DESIGNS INCORPORATED HEREIN, AS AN INSTRUMENT OF PROFESSIONAL SERVICE, IS THE PROPERTY OF CH2M HILL AND IS NOT TO BE USED, IN WHOLE OR IN PART, FOR ANY OTHER PROJECT WITHOUT THE WRITTEN AUTHORIZATION OF CH2M HILL.

VERIFY SCALES
BAR IS ONE INCH ON ORIGINAL DRAWING.
IF NOT ONE INCH ON THIS SHEET, ADJUST SCALES ACCORDINGLY.

MODIFICATIONS TO THE
J. LAMBERT SCHWARTZ WWTP
THE GRAND STRAND
WATER AND SEWER AUTHORITY

PRE-AERATION BASIN
SECTIONS AND DETAILS

SHEET
DWG NO. **S-4**
DATE **AUG 1985**
PROJ NO. **SA19793A0**



SHEET	
DWG NO.	M-1
DATE	AUG 1985
PROJ NO.	SA19793.AO

**MODIFICATIONS
TO THE
J. LAMBERT SCHWARTZ WWTP
THE GRAND STRAND
WATER AND SEWER AUTHORITY**

REUSE OF DOCUMENTS

VERIFY SCALES

MODIFICATIONS

MODIFICATIONS
TO THE
J. LAMBERT SCHWARTZ WWTP

THE GRAND STRAND
WATER AND SEWER AUTHORITY


1
2
3
4
5
6

1
2
3
4
5
6

1
2
3
4
5
6

1
2
3
4
5
6

1
2
3
4
5
6

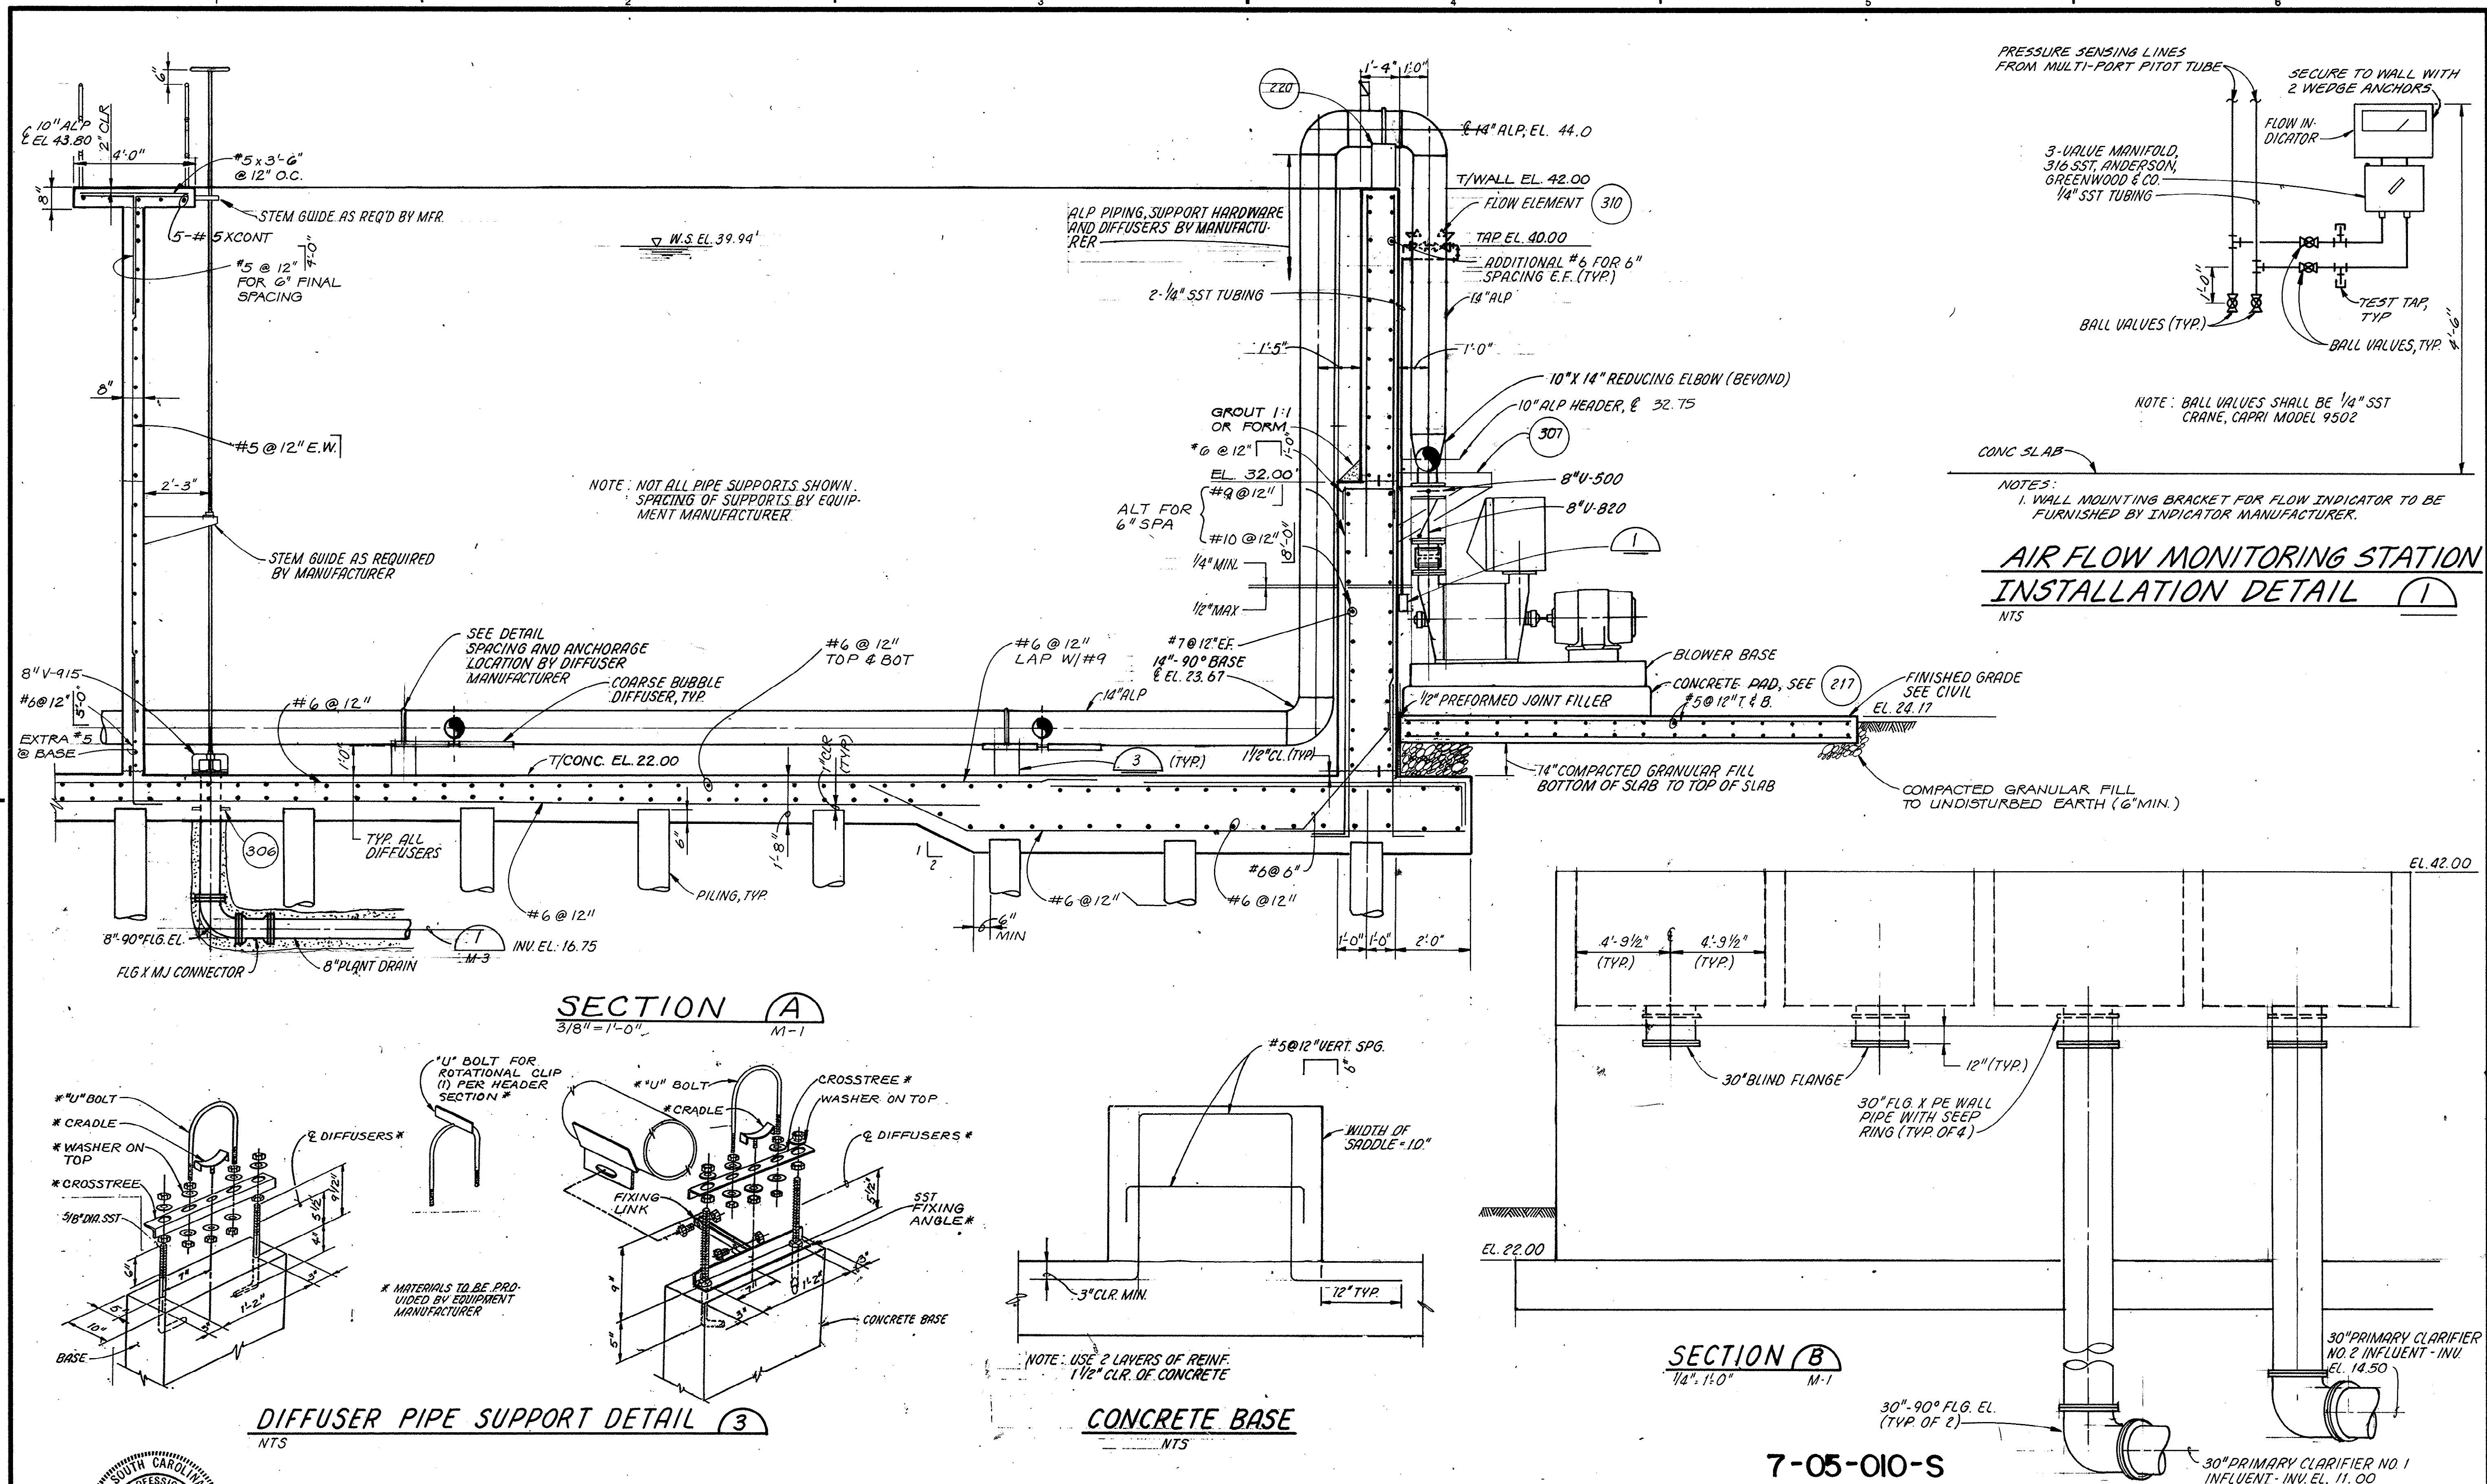

DIFFUSER PIPE SUPPORT DETAIL (3)

CONCRETE BASE

SECTION (B)

7-05-010-S



DESIGN BY
R. PUCCHIA / WORCESTER
OR
BROZMAN / JACKSON
CHECKED BY
GOLDMAN / MAXFIELD
APPROVED BY
R. B. HURSEKORN

NO. DATE REVISION

BY APVD


REUSE OF DOCUMENTS
THIS DOCUMENT, AND THE IDEAS AND DESIGNS INCORPORATED HEREIN, AS AN INSTRUMENT OF PROFESSIONAL SERVICE, IS THE PROPERTY OF CH2M HILL AND IS NOT TO BE USED, IN WHOLE OR IN PART, FOR ANY OTHER PROJECT WITHOUT THE WRITTEN AUTHORIZATION OF CH2M HILL.

VERIFY SCALES
BAR IS ONE INCH ON ORIGINAL DRAWING.
IF NOT ONE INCH ON THIS SHEET, ADJUST SCALES ACCORDINGLY.


MODIFICATIONS TO THE
J. LAMBERT SCHWARTZ WWTP
THE GRAND STRAND WATER AND SEWER AUTHORITY

PRE-AERATION BASIN SECTIONS AND DETAILS

DWG NO. **M-2**
DATE **AUG 1986**
PROJ. NO. **SA 19793.A.0**


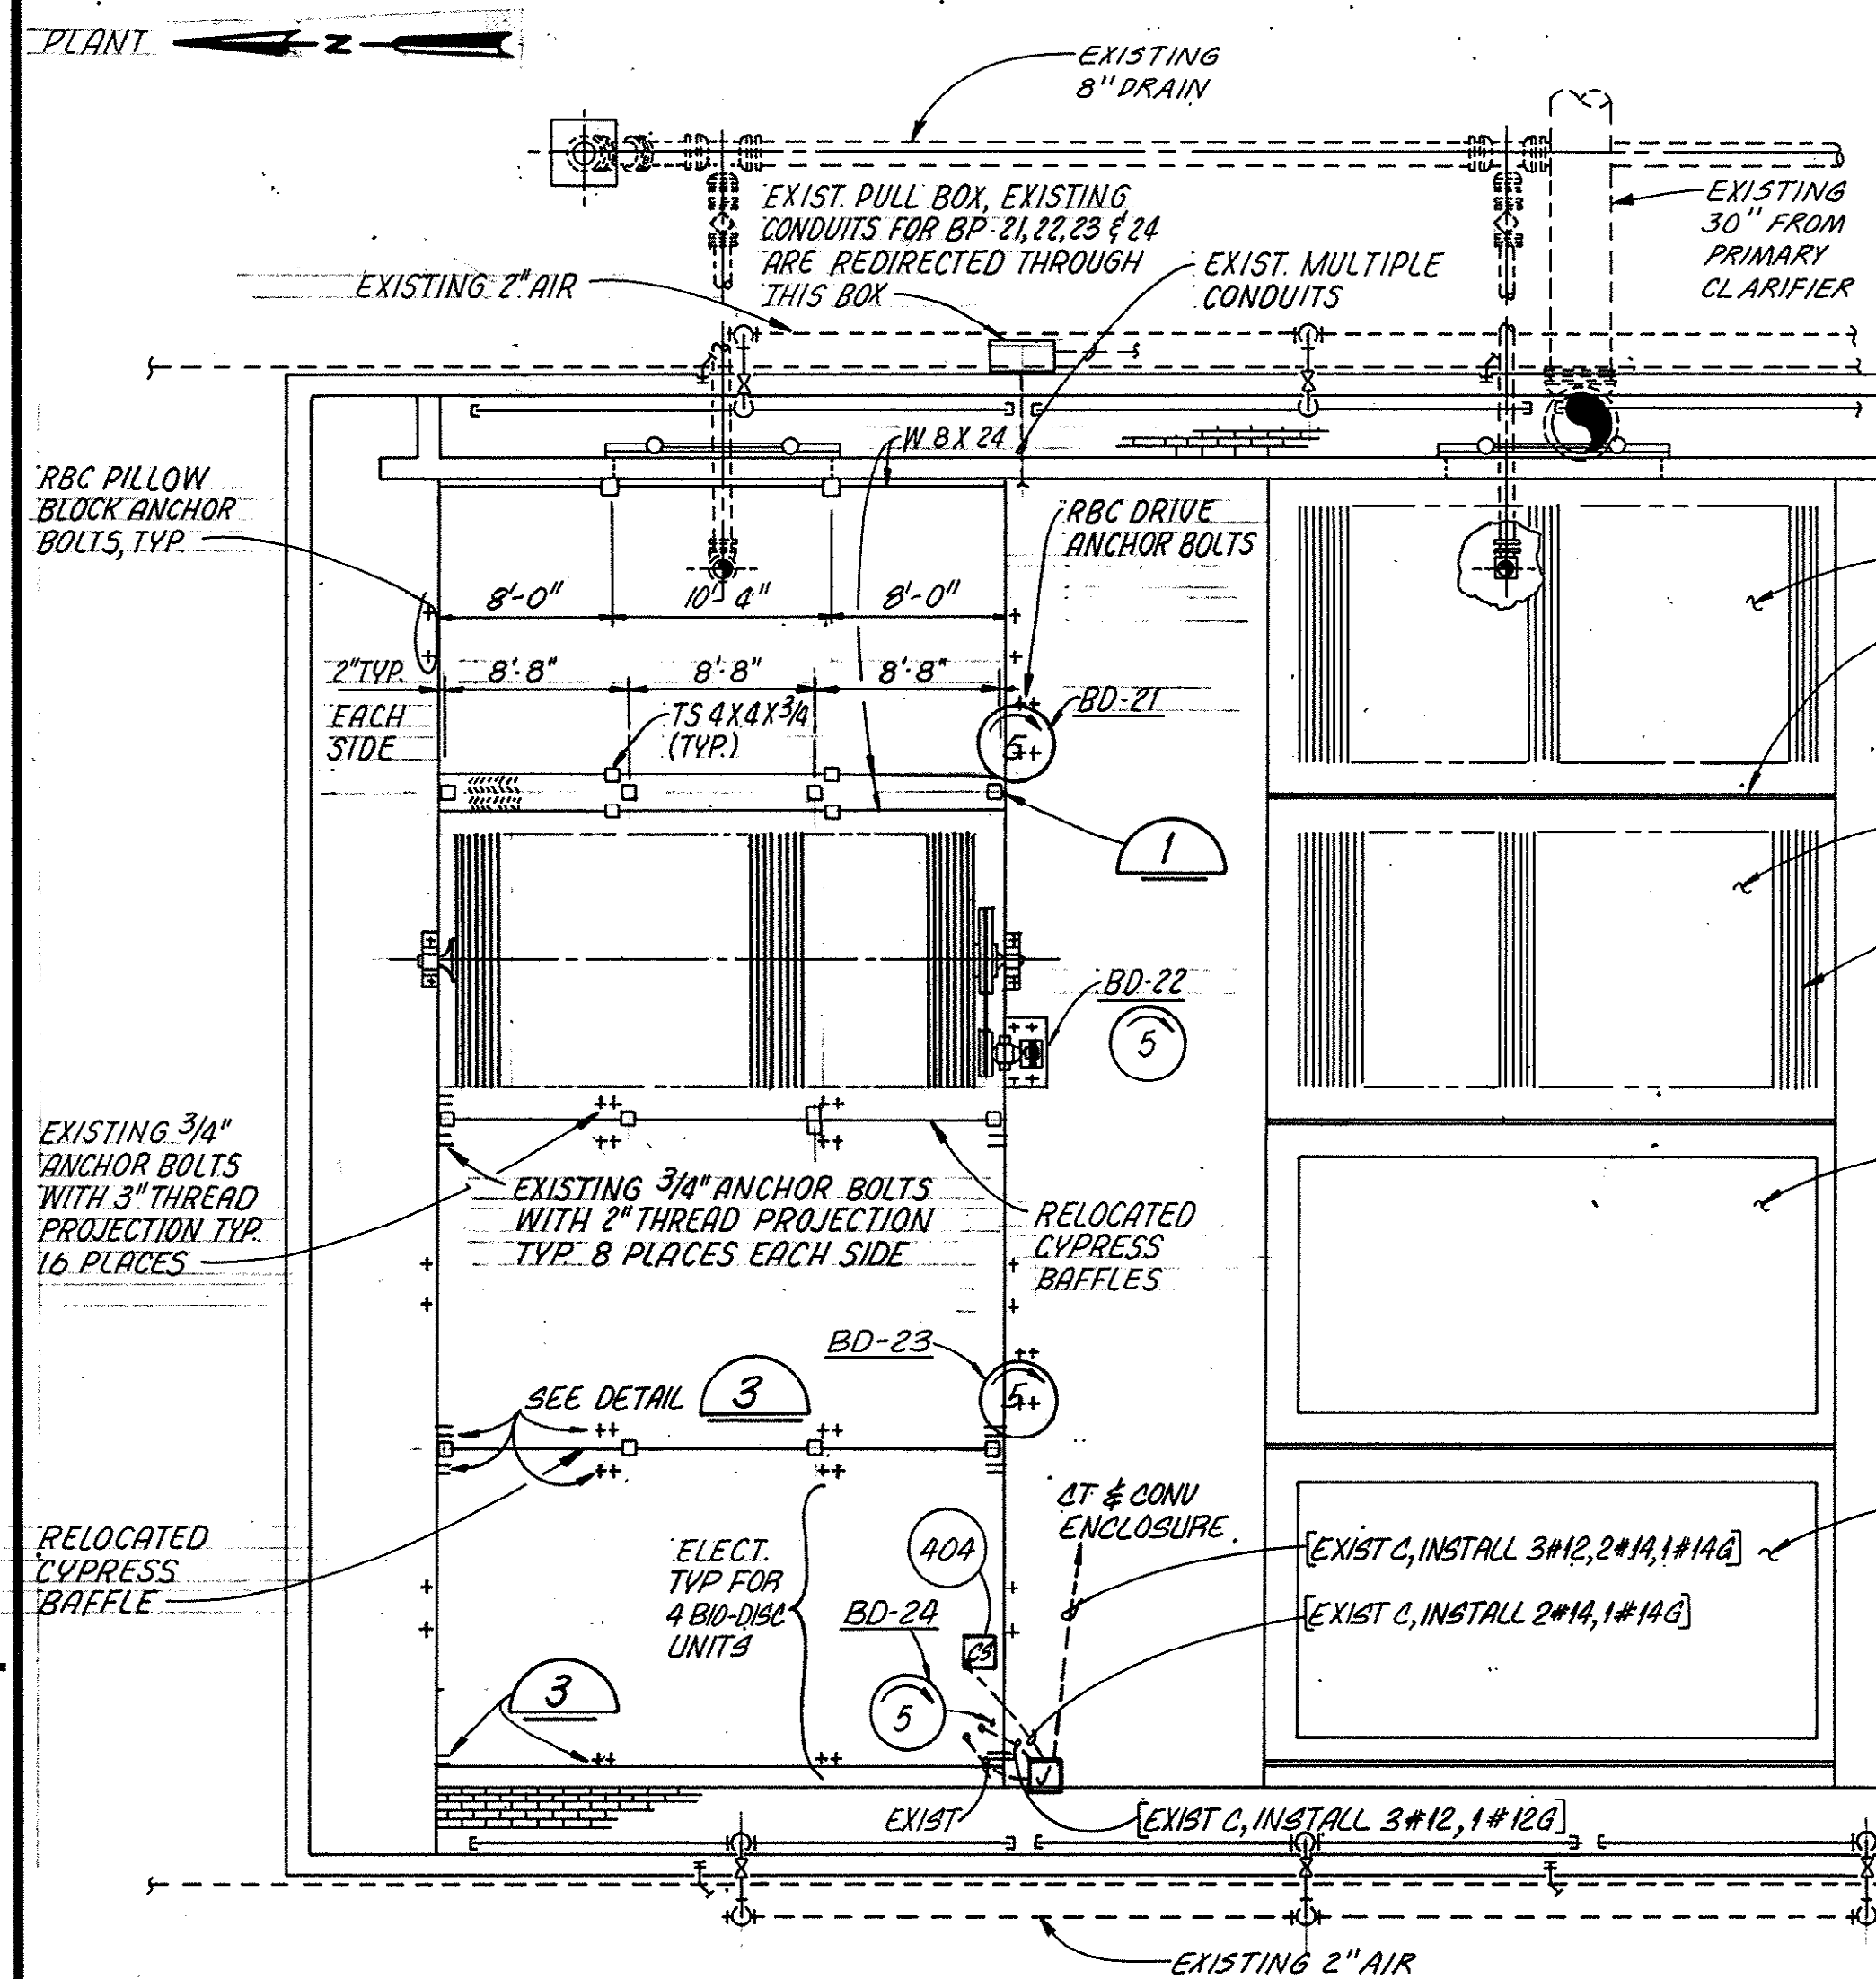


ROTATING BIOLOGICAL CONTACTOR PARTIAL PLAN

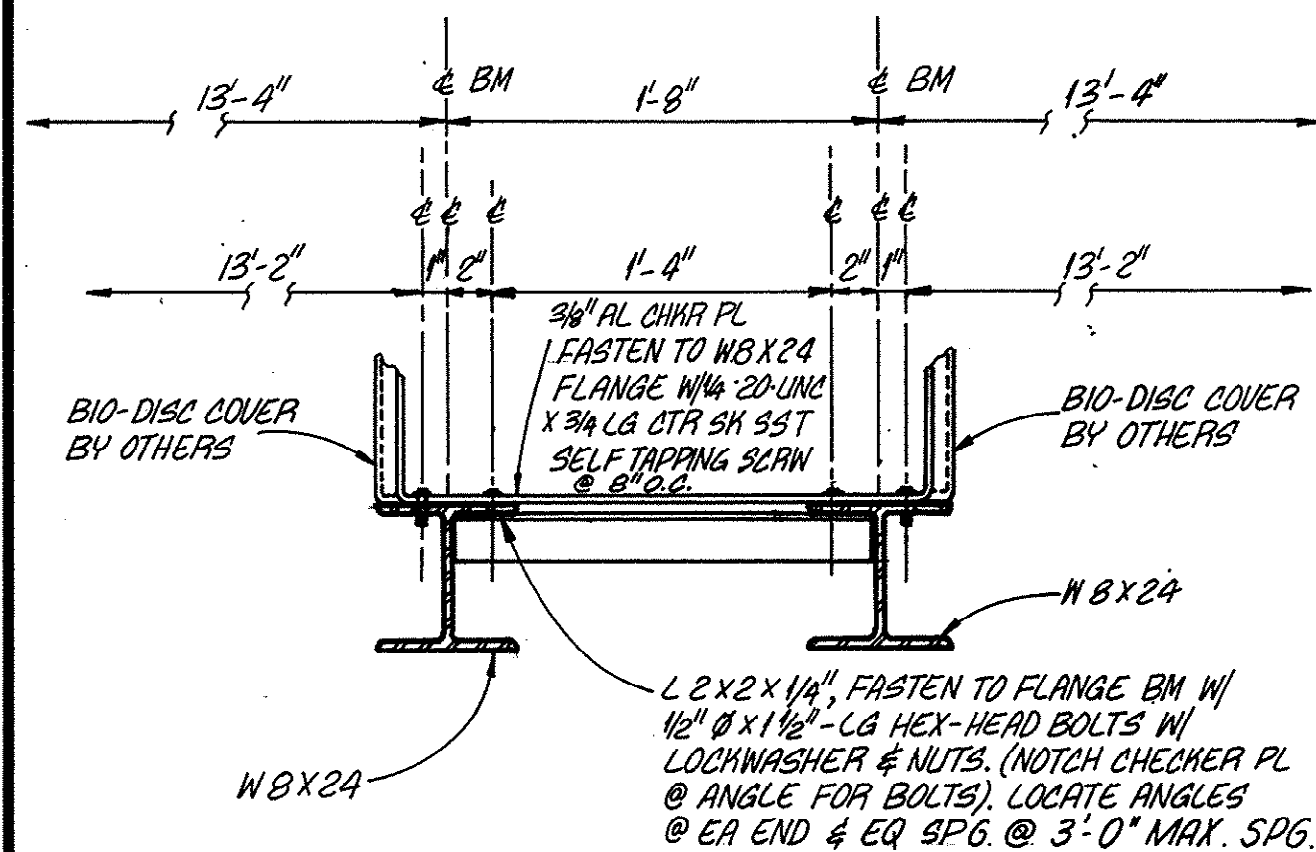


RBC COVER SUPPORT DETAILS

N.T.S.

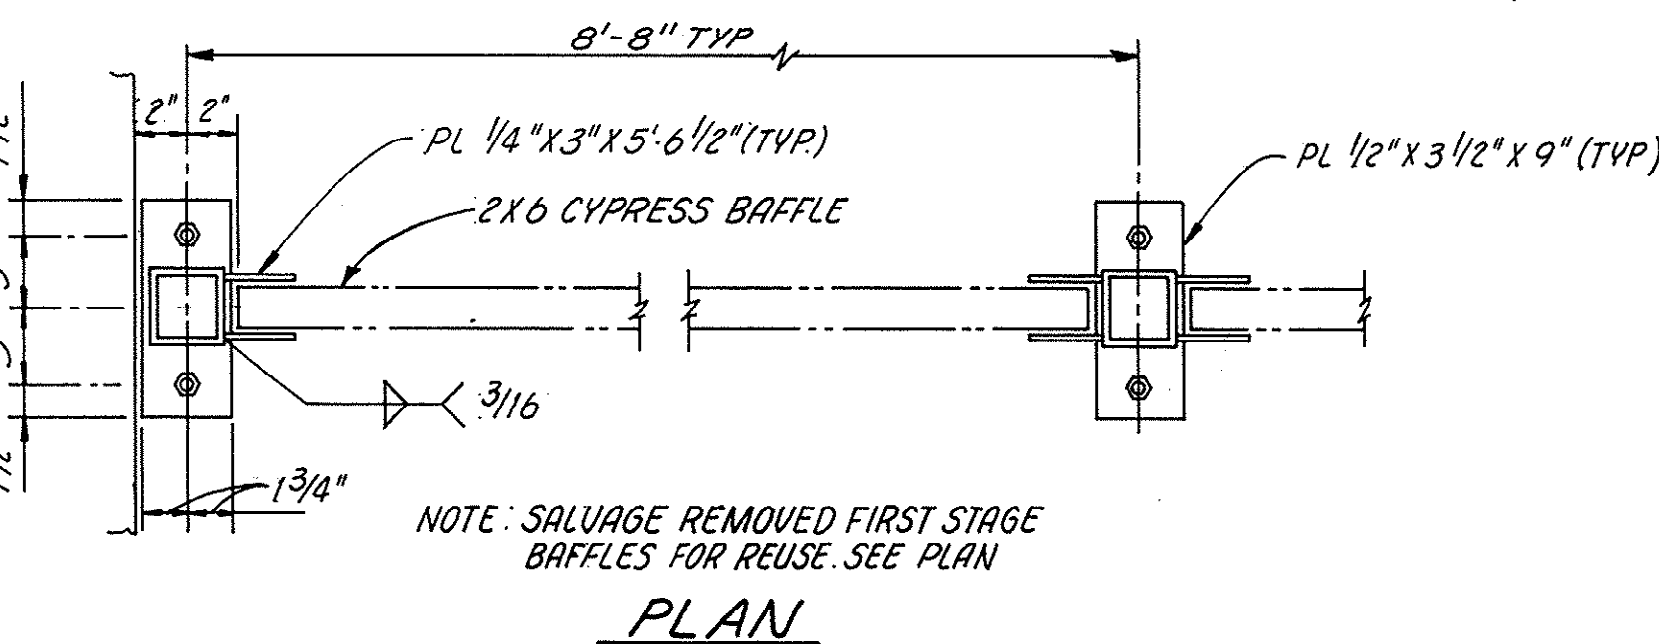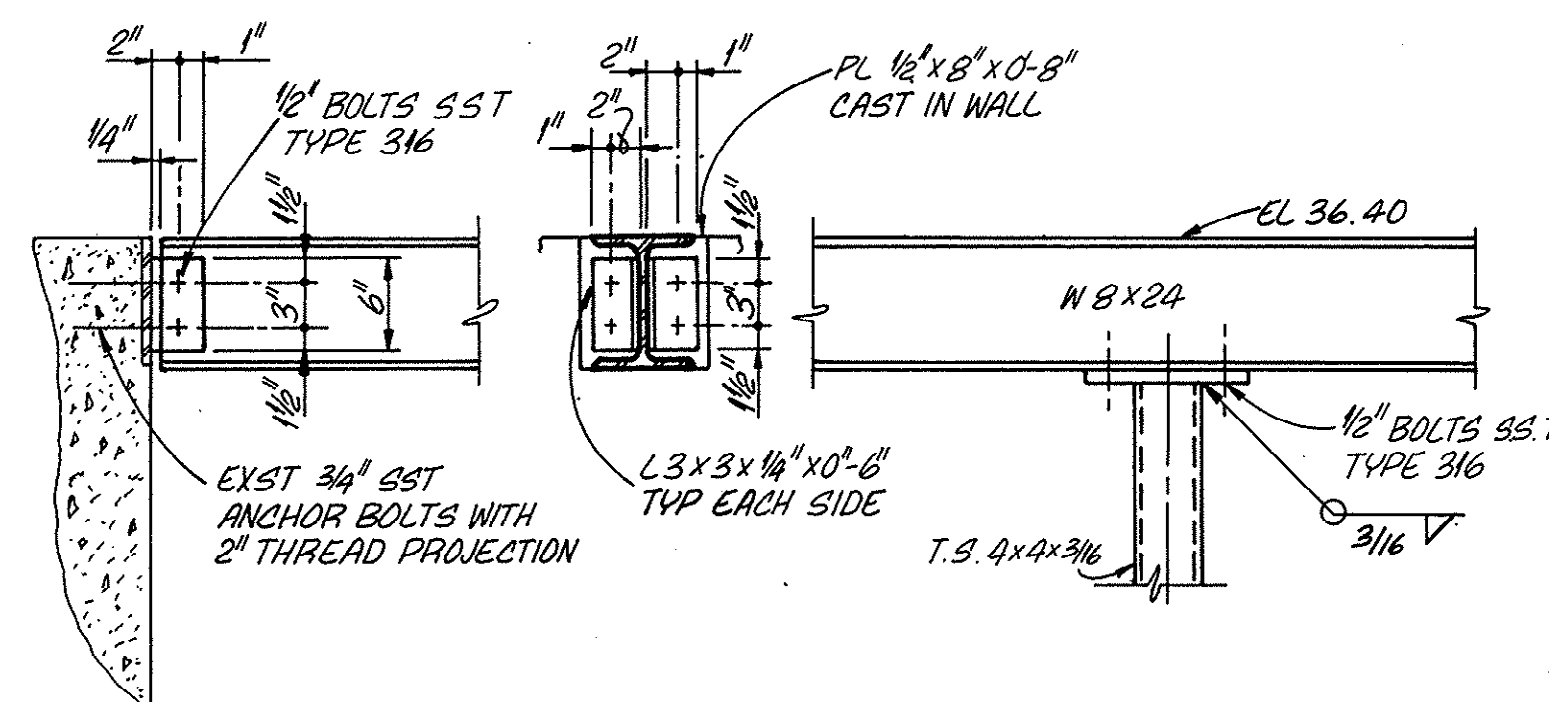


PLAN

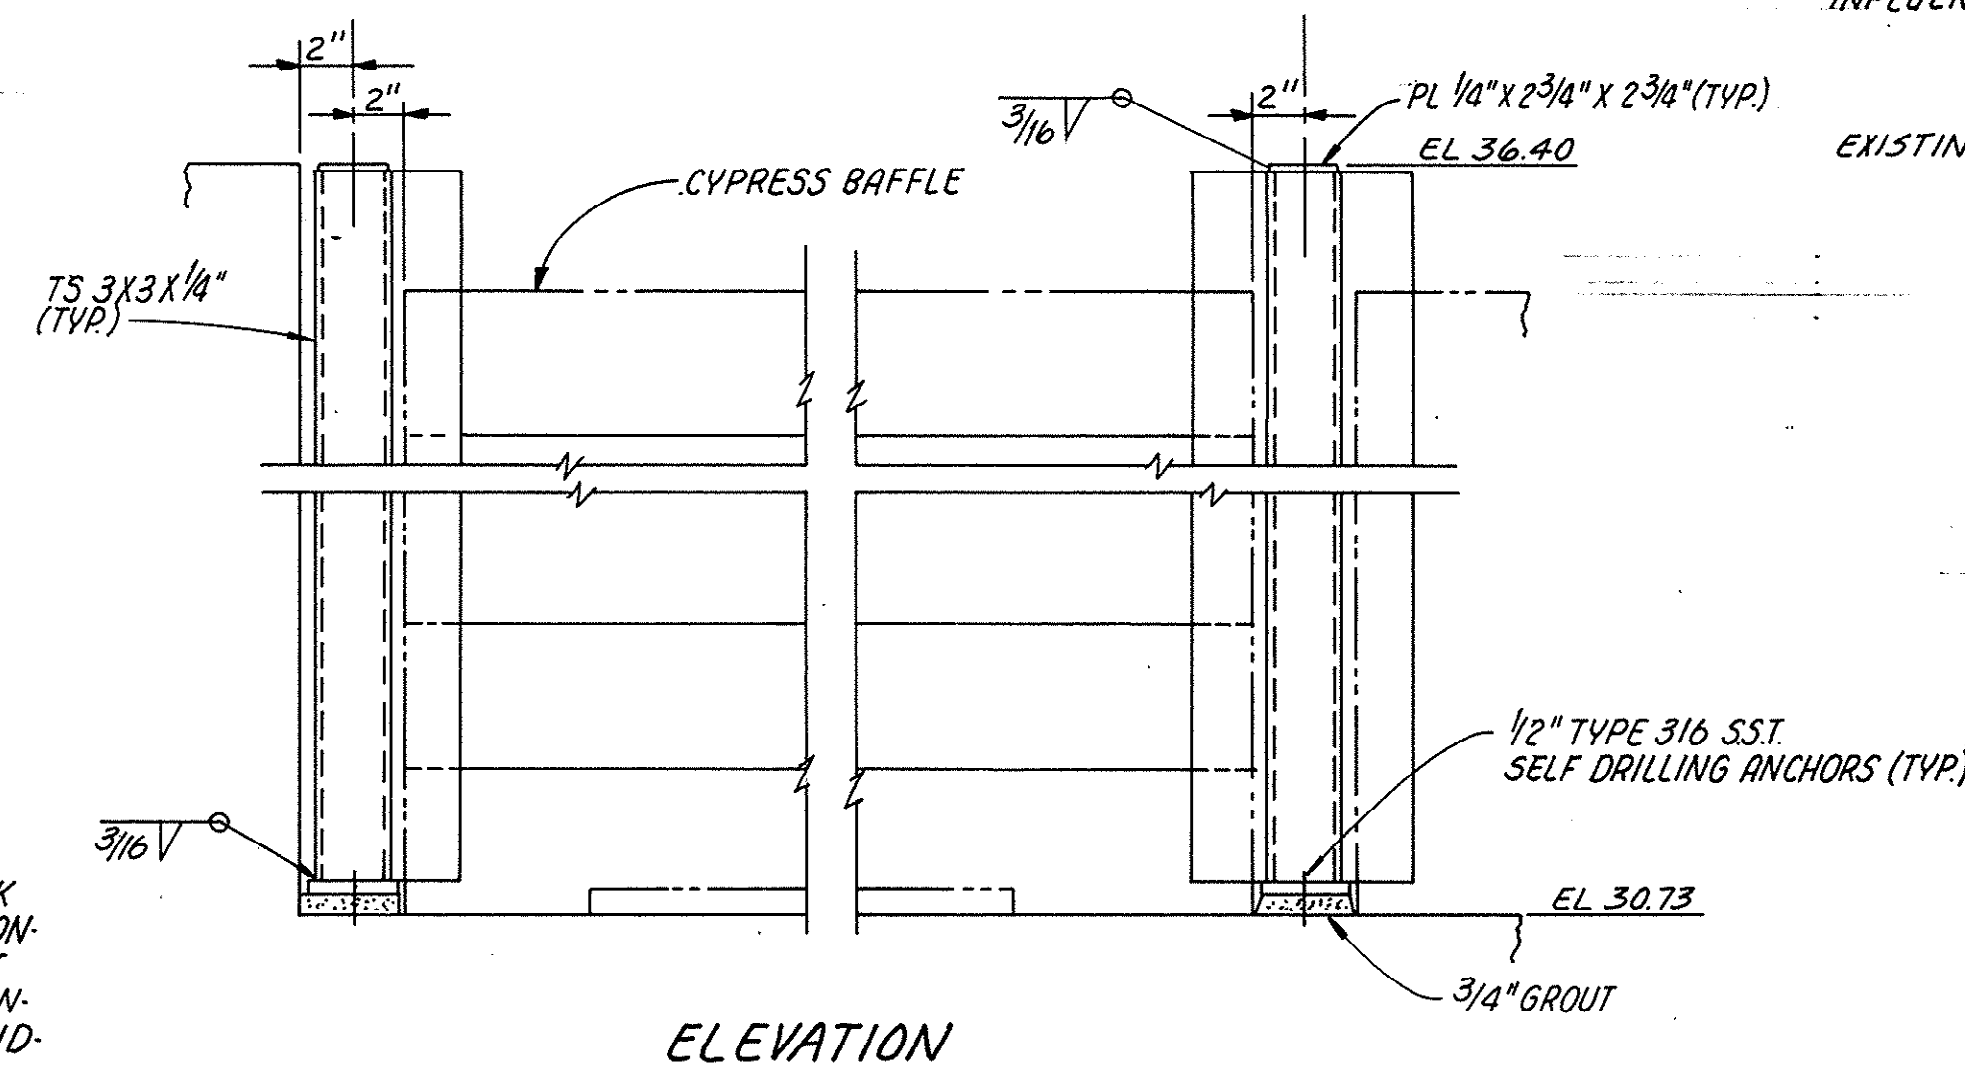


ELEVATION

BAFFLE INSTALLATION/REMOVAL DETAIL 1

1/2" = 1'-0"

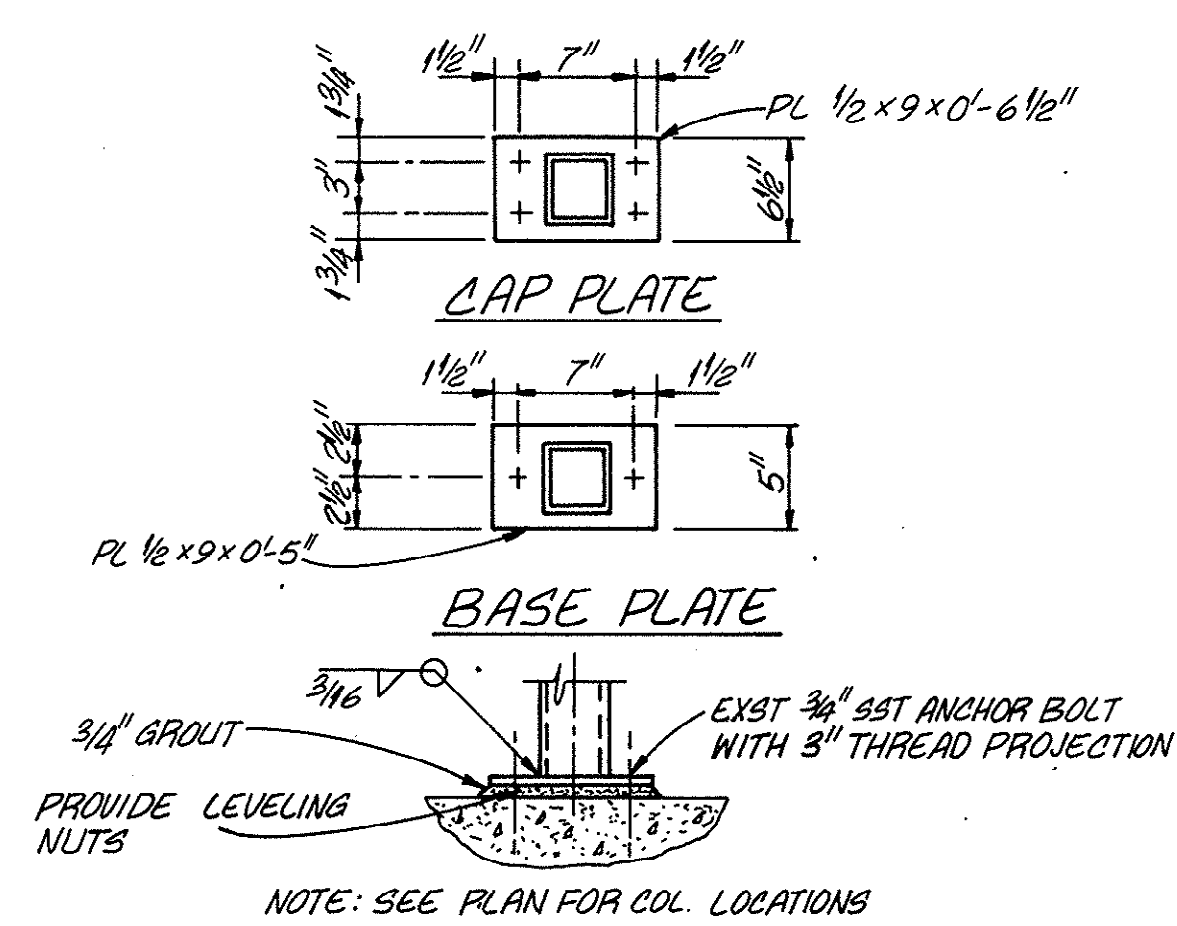

* NOTE: DO NOT TIE ENCASEMENT TO FLOOR SLAB ABOVE UNLESS SPECIFICALLY SHOWN ON DRAWING

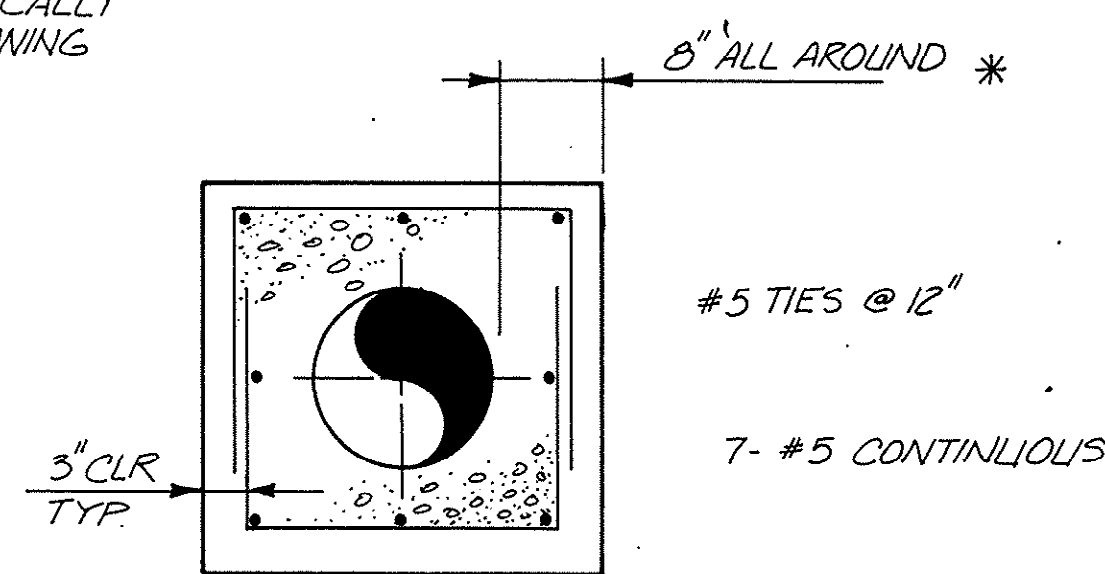


PIPE ENCASEMENT

NTS

M-1, M-2

7-05-011-S

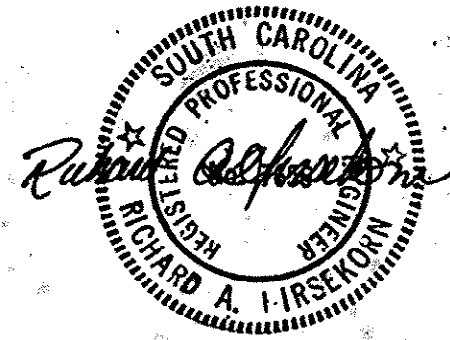

DSGN	U. BATES / R. JOHNSON
DR	R. A. GILKESON / H. DE MEL
CHK	T. L. BELSER
APVD	R. A. HIRSEKORAL

NO.	DATE	REVISION	BY	APVD
-----	------	----------	----	------

REUSE OF DOCUMENTS
THIS DOCUMENT, AND THE IDEAS AND DESIGNS INCORPORATED HEREIN, AS AN INSTRUMENT OF PROFESSIONAL SERVICE, IS THE PROPERTY OF CH2M HILL AND IS NOT TO BE USED, IN WHOLE OR IN PART, FOR ANY OTHER PROJECT WITHOUT THE WRITTEN AUTHORIZATION OF CH2M HILL.


VERIFY SCALES
BAR IS ONE INCH ON ORIGINAL DRAWING.
0 1"
IF NOT ONE INCH ON THIS SHEET, ADJUST SCALES ACCORDINGLY.

MODIFICATIONS TO THE
J. LAMBERT SCHWARTZ WWTP


THE GRAND STRAND
WATER AND SEWER AUTHORITY

ROTATING BIOLOGICAL CONTACTOR/
HEADWORKS MODIFICATIONS

DWG NO.	M-3
DATE	AUG 1988
PROJ NO.	SA19793A0

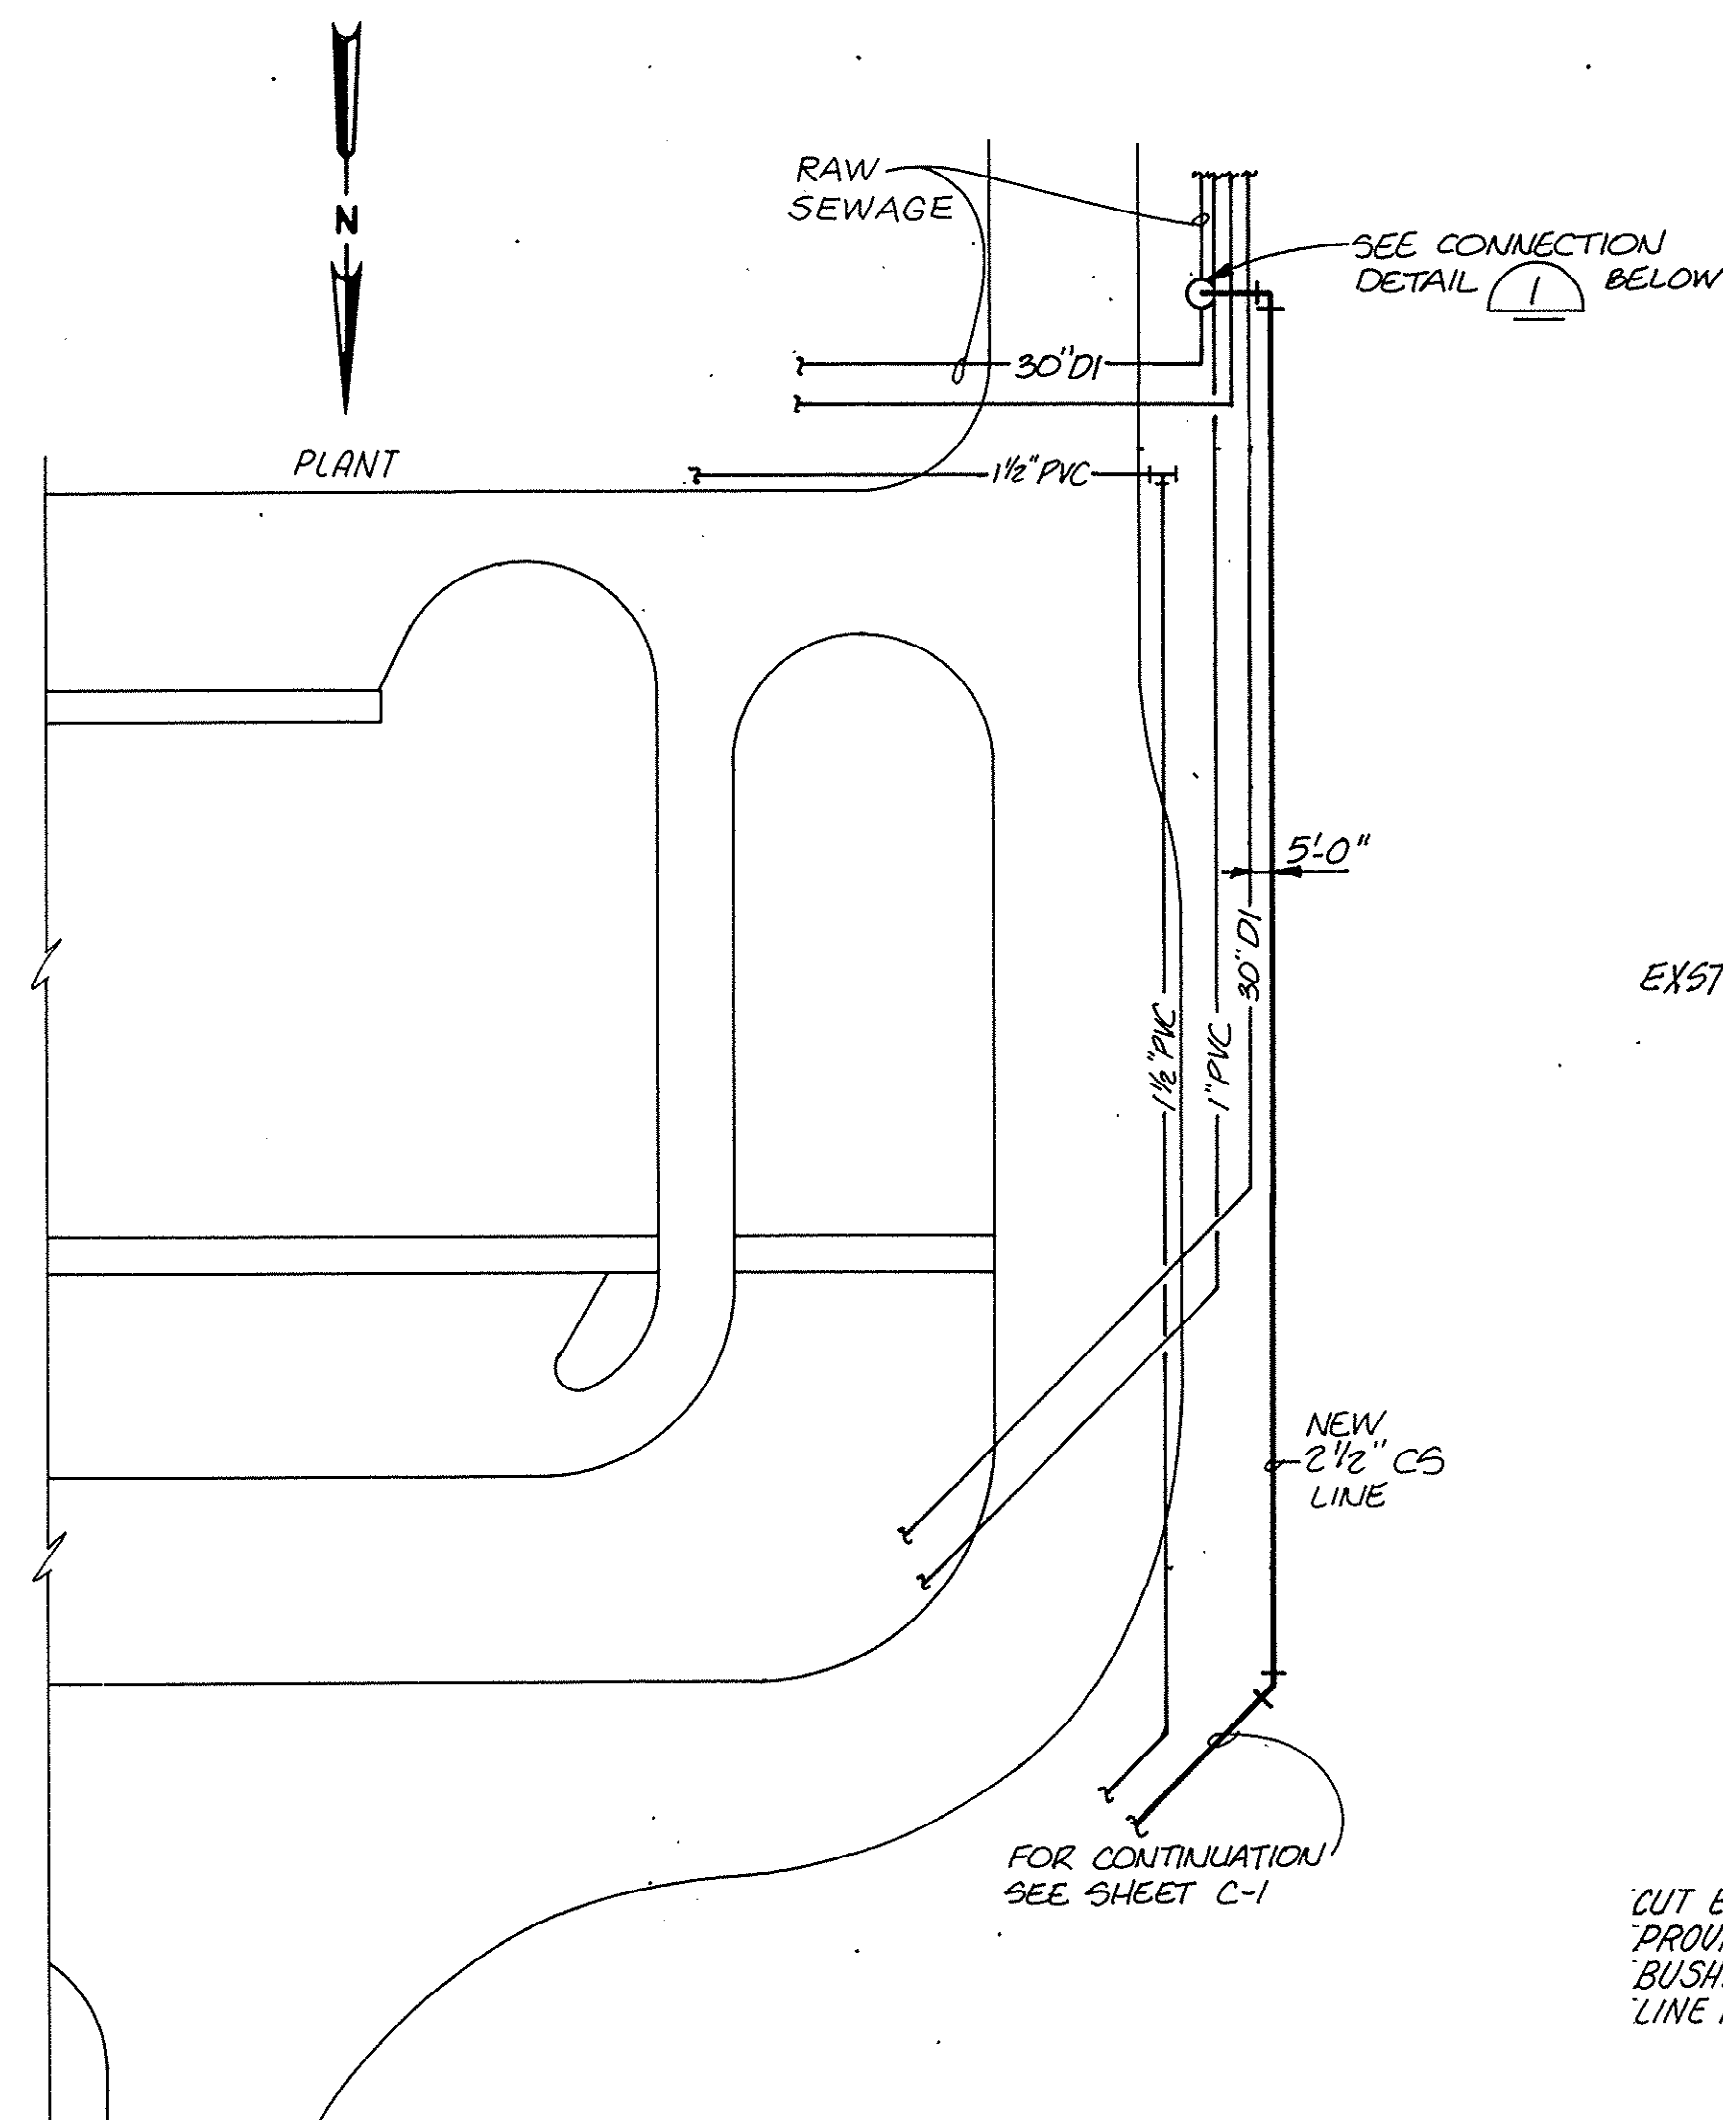


PARTIAL SITE PLAN
 1" = 30'

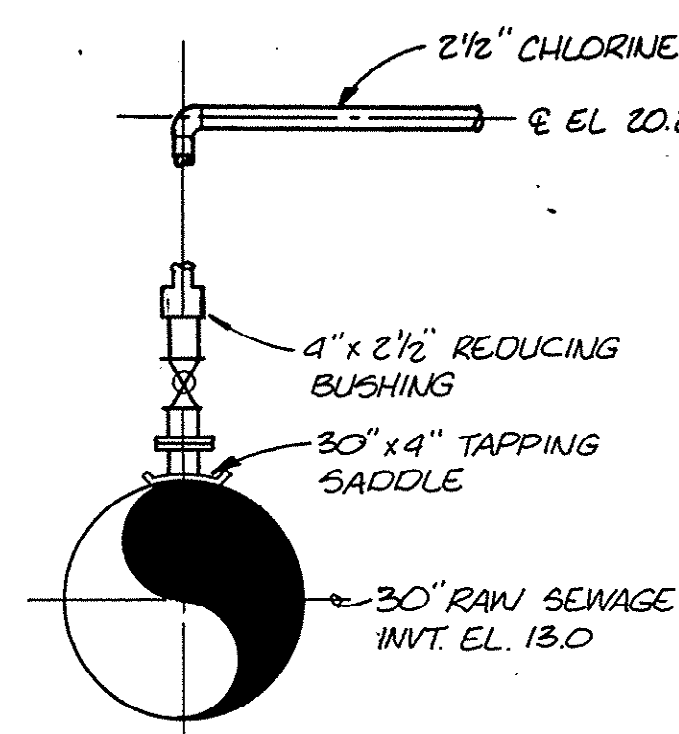


DETAIL 1
 NTS

- NOTES:
1. PROVIDE TAPPING SADDLE AND 4" BALL VALVE. DRILL PIPE FOR 2 1/2" DIA. ORIFICE THROUGH BALL VALVE.
 2. BALL VALVE NOT REQUIRED FOR CONNECTION TO WASTE SLUDGE LINE.

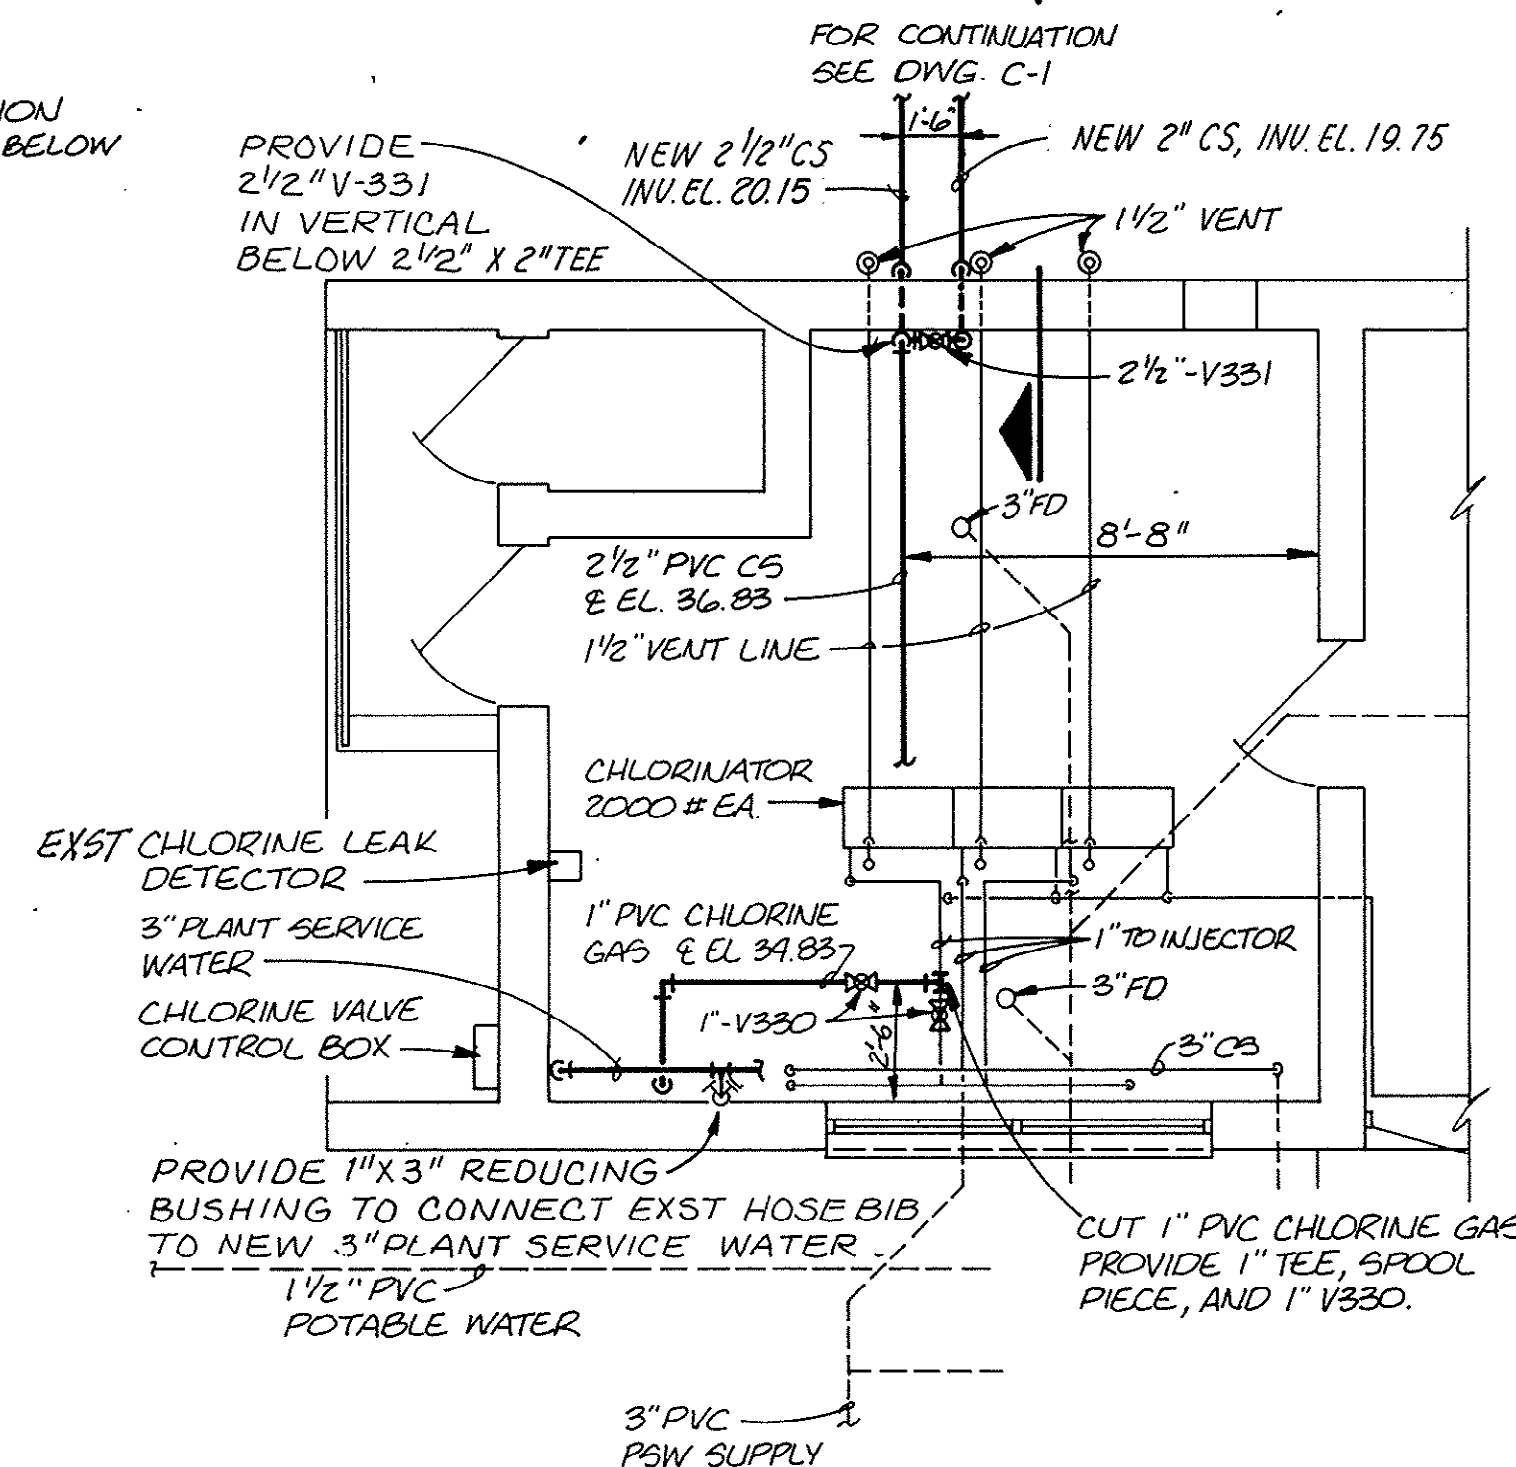


CHLORINATION BUILDING PARTIAL PLAN
 1/4" = 1'-0"

CUT EXISTING 1 1/4" IRRIGATION. PROVIDE 1 1/4" x 1 1/2" REDUCING BUSHING. RE-ROUTE IRRIGATION LINE AS SHOWN

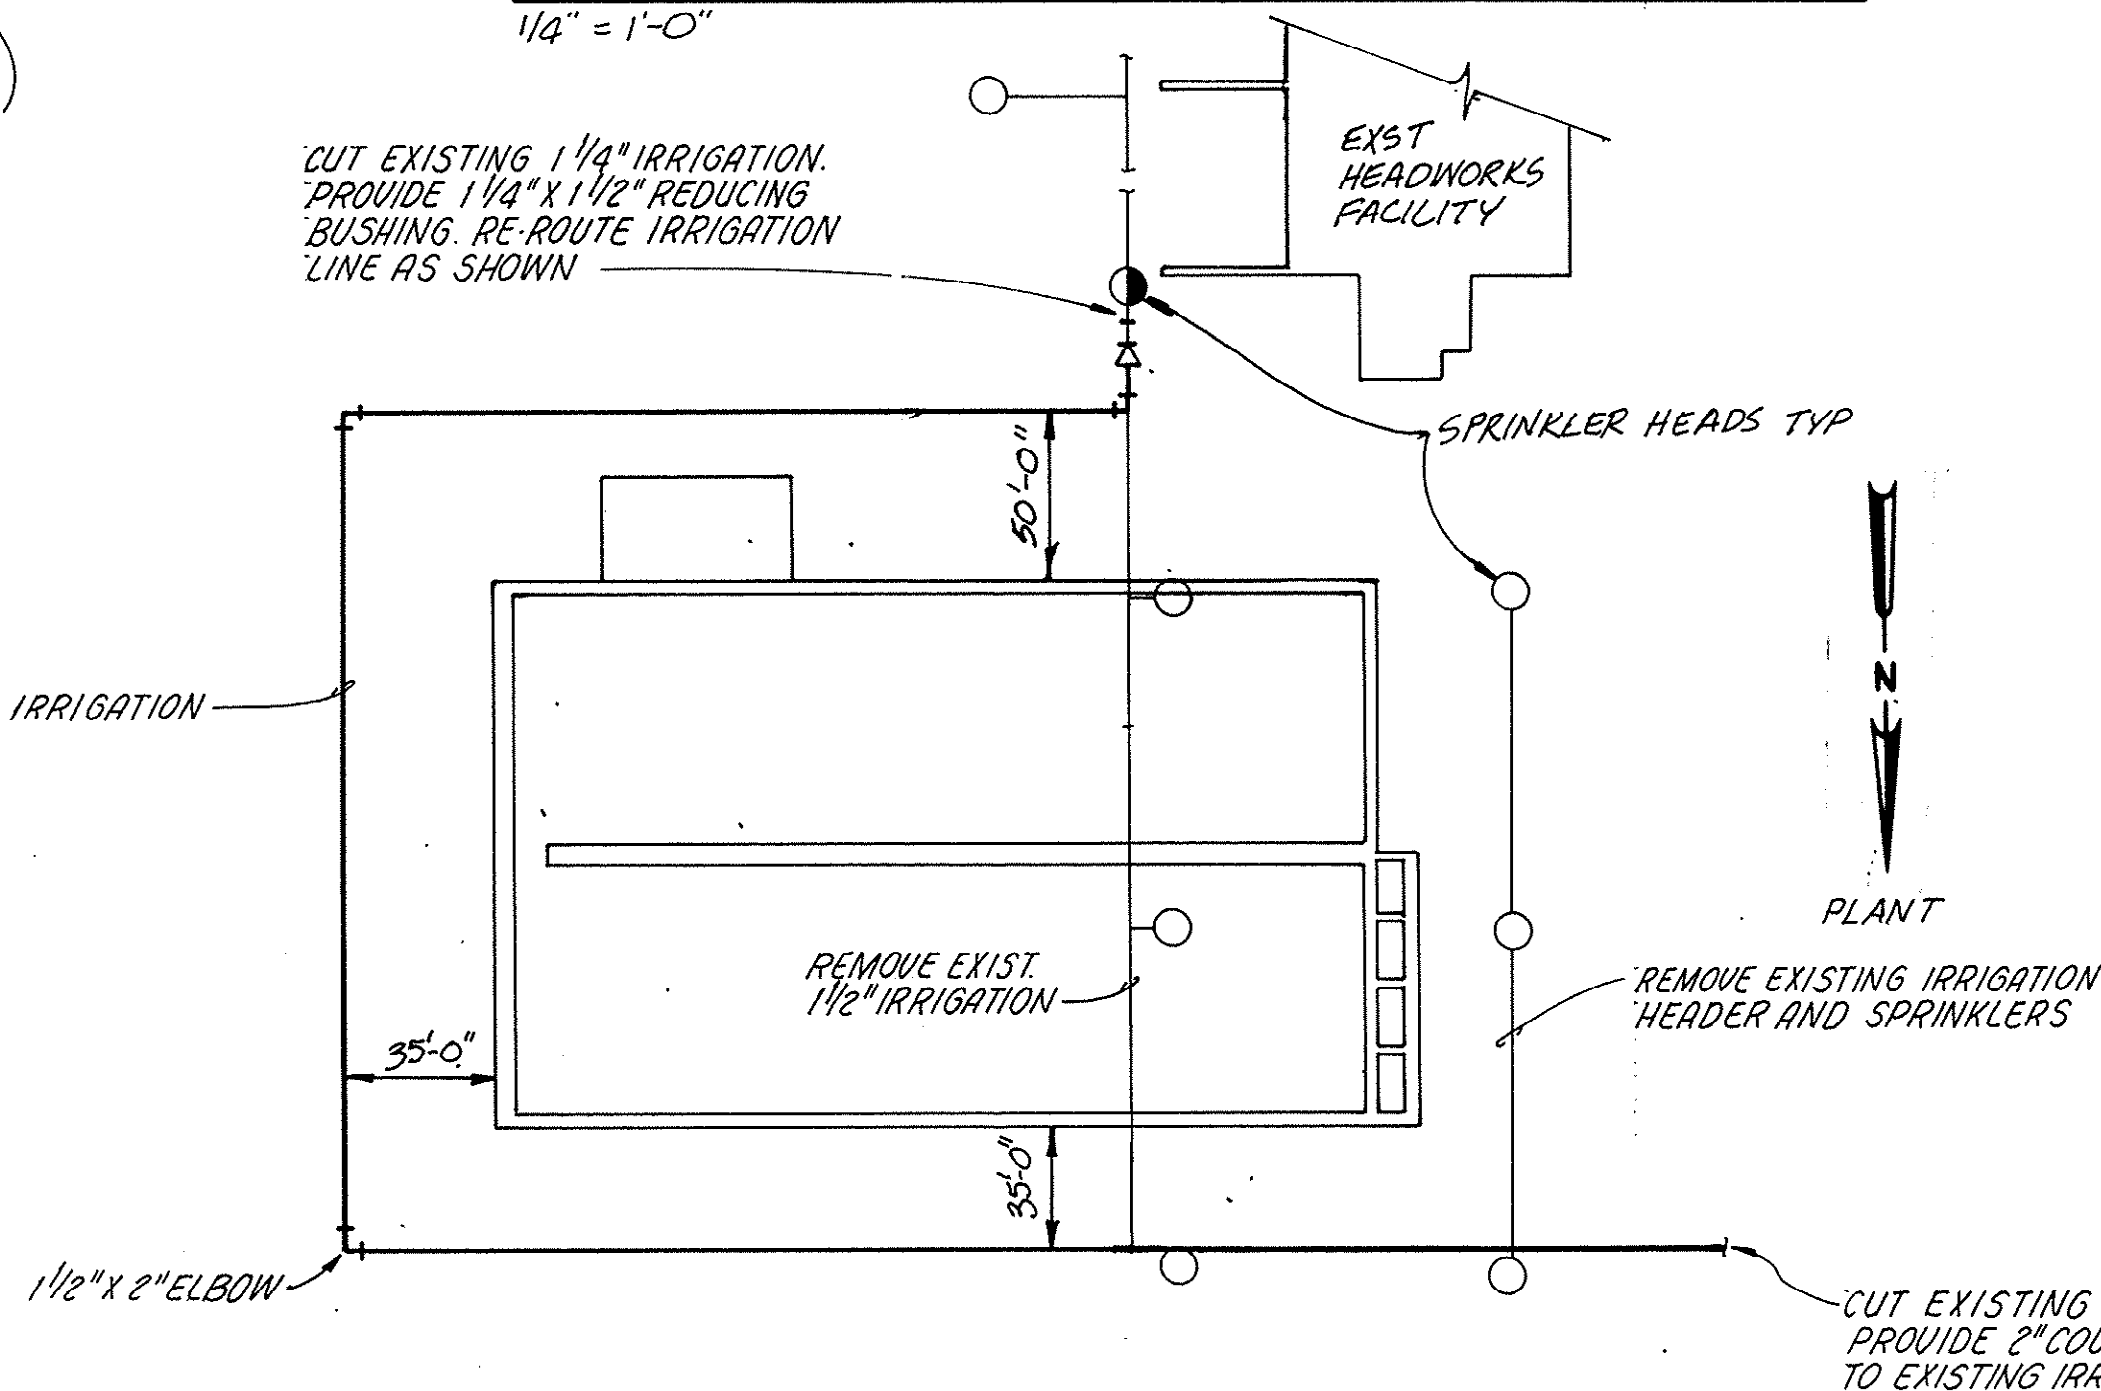


IRRIGATION SYSTEM DETAIL
 NTS
 C-1

EXST CHLORINE SOLUTION TO CLARIFIER EFFLUENT DISINFECTION

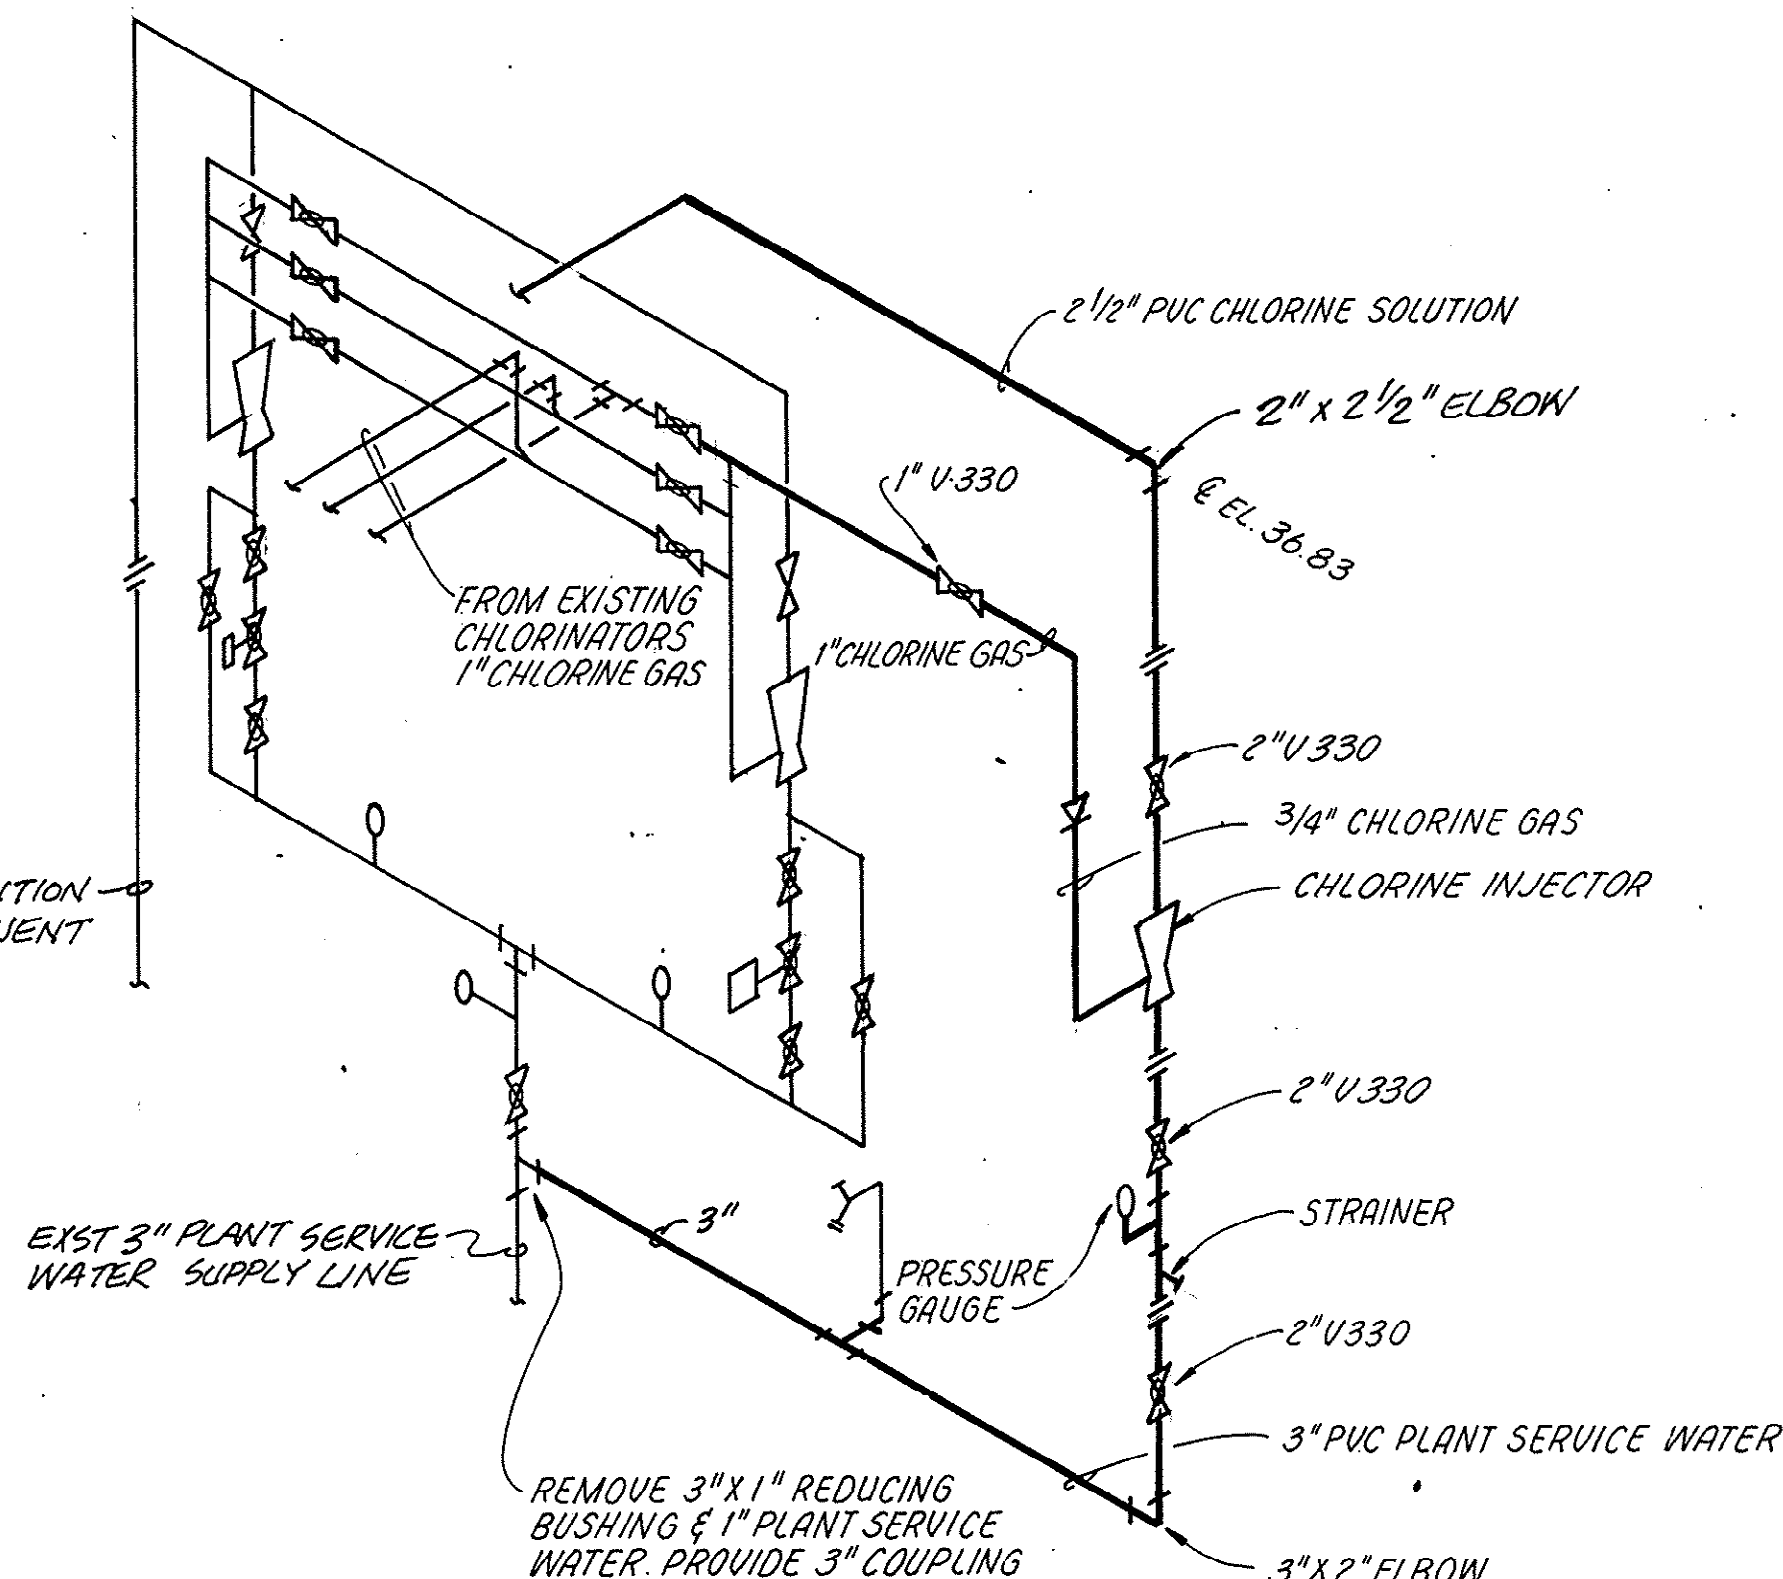


CHLORINATION BUILDING PIPING SCHEMATIC

NOTE: SEE 309 FOR PIPE SUPPORTS

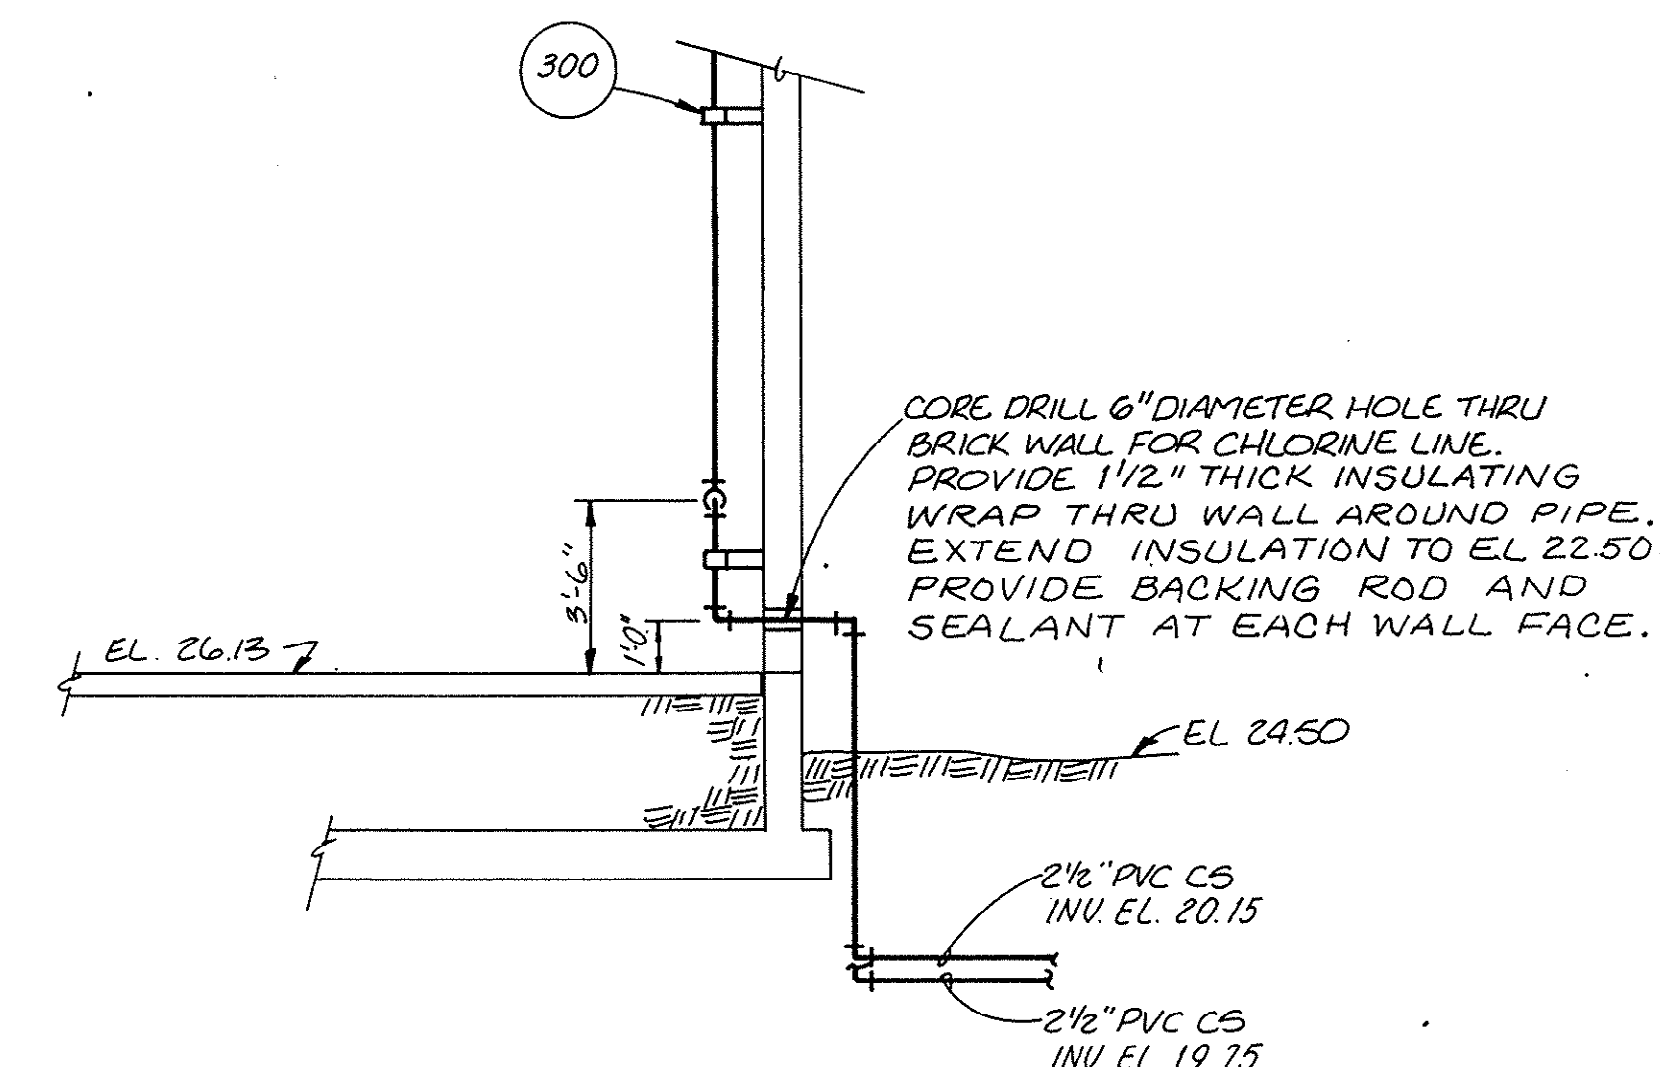

SECTION B
 1/4" = 1'-0"

7-05-012-S

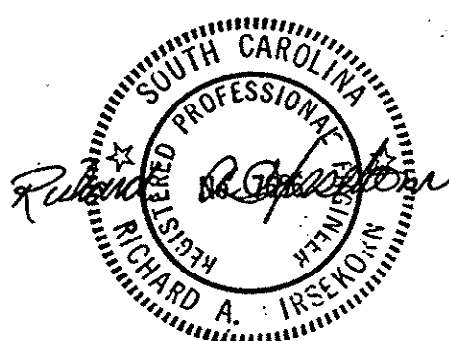

DSGN: V. BATES
 DR: M. HALES
 CHK: T.L. BELSER
 APVD: R.A. HISEKORN

NO.	DATE	REVISION	BY	APVD

REUSE OF DOCUMENTS
 THIS DOCUMENT, AND THE IDEAS AND DESIGNS INCORPORATED HEREIN, AS AN INSTRUMENT OF PROFESSIONAL SERVICE, IS THE PROPERTY OF CH2M HILL AND IS NOT TO BE USED, IN WHOLE OR IN PART, FOR ANY OTHER PROJECT WITHOUT THE WRITTEN AUTHORIZATION OF CH2M HILL.

VERIFY SCALES
 BAR IS ONE INCH ON ORIGINAL DRAWING.
 0 1"
 IF NOT ONE INCH ON THIS SHEET, ADJUST SCALES ACCORDINGLY.

MODIFICATIONS TO THE
J. LAMBERT SCHWARTZ WWTP
THE GRAND STRAND WATER AND SEWER AUTHORITY

CHLORINATION BUILDING MODIFICATIONS


DWG NO. **M-4**
 DATE **AUG 1985**
 PROJ NO. **SA19793.A0**

ELECTRICAL LEGEND


	CONNECTION POINT TO EQUIPMENT SPECIFIED. FURNISHED AND INSTALLED UNDER OTHER SECTIONS. RACEWAY, CONDUCTOR AND CONNECTION IN THIS SECTION.
	CONDUIT OF SIZE X CONTAINING CONDUCTORS Y
	MAJOR ELECTRICAL COMPONENT OR DEVICE - NAME OR IDENTIFYING SYMBOL AS SHOWN.
	MOTOR, SQUIRREL CAGE INDUCTION - HORSEPOWER INDICATED
	LUMINAIRE - SEE SCHEDULE
	LUMINAIRE AND POLE - SEE SCHEDULE
	WALL MOUNTED LUMINAIRE - SEE SCHEDULE
	GENERAL ELECTRICAL CONTROL OR WIRING DEVICE. NEMA 1 ENCLOSURE UNLESS INDICATED OTHERWISE. LETTER SYMBOLS OR ABBREVIATIONS INDICATE TYPE OF DEVICE.
	DRAWOUT AIR CIRCUIT BREAKER LOW VOLTAGE
	FUSE
	GROUND
	TRANSFORMER, SECONDARY VOLTAGES, PHASE AND RATING INDICATED AS APPLICABLE
	GROUND FAULT RELAY WITH C.T.
	PUSH-BUTTON SWITCH, MOMENTARY CONTACT, NORMALLY CLOSED
	TIME DELAY RELAY CONTACT NORMALLY OPEN CONTACT
	TIME DELAY RELAY CONTACT NORMALLY CLOSED
	HOME RUN - DESTINATION SHOWN
	EXPOSED CONDUIT AND CONDUCTORS*
	CONCEALED CONDUIT AND CONDUCTORS*
	CONDUIT, DOWN
	WALL SWITCH: 2 - DOUBLE POLE WP - WEATHERPROOF
	CONVENIENCE RECEPTACLE - DUPLEX UNLESS SPECIFIED OTHERWISE WP - WEATHERPROOF
	CONTACT - NORMALLY OPEN
	CONTACT - NORMALLY CLOSED
	OVERLOAD RELAY HEATER
	MAGNETIC STARTER WITH NEMA SIZE INDICATED
	CIRCUIT BREAKER, MAGNETIC TRIP ONLY. FRAME SIZE SHOWN, 3 POLE UNLESS INDICATED OTHERWISE.
	CIRCUIT BREAKER, 3 POLE UNLESS INDICATED OTHERWISE
	CIRCUIT BREAKER WITH CURRENT LIMITING FUSES. TRIP AND FUSE RATING INDICATED, 3 POLE UNLESS INDICATED OTHERWISE.
	REMOTE DEVICE
	CURRENT TRANSFORMER
	INDICATING LIGHT - LETTER INDICATES COLOR
	GENERAL ELECTRICAL CONTROL OR WIRING DEVICE. LETTER SYMBOLS OR ABBREVIATIONS INDICATE TYPE OF DEVICE.
	DB1 CONSTRUCTION
	DB2 CONSTRUCTION

ABBREVIATIONS

86	LOCKOUT RELAY	INCA	INCANDESCENT
A	AMMETER	JJB	JUNCTION BOX
AF	AMPS FRAME	KCM	THOUSAND CIRCULAR MILLS
AOL	AUXILIARY OVERLOAD	LC	LATCHING COIL
AT	AMPS TRIP	LR	LATCHING RELAY
ATNR	AUTO-TRANSFORMER NON-REVERSING	M	MAGNETIC CONTACTOR COIL
C	CONDUIT	MA	MILLIAMPERE
CB	CIRCUIT BREAKER	MCC	MOTOR CONTROL CENTER
CPT	CONTROL POWER TRANSFORMER	MR	METER RELAY
CR	CONTROL RELAY	MTD	MOTOR THERMAL DETECTOR
CT	CURRENT TRANSFORMER	N, NEUT	NEUTRAL
E	ELECTRICAL OPERATION	NC	NORMALLY CLOSED
EA	EACH	NO	NORMALLY OPEN
EI	ELECTRICAL INTERLOCK	OL	OVERLOAD RELAY
ETM	ELAPSED TIME METER	S	SECOND
EXST	EXISTING	SH	SPACE HEATER
F, FU	FUSE	SW	SWITCH
FVNR	FULL VOLTAGE NON-REVERSING	SWGR	SWITCHGEAR
G, GND	GROUND	TC	TRIP COIL
GALV	GALVANIZED	TDC	TIME-DELAYED CLOSING
GFR	GROUND FAULT RELAY	TDR	TIME DELAY RELAY
HH	HANDHOLE	TJB	TERMINAL JUNCTION BOX
HID	HIGH INTENSITY DISCHARGE	UC	UNLATCHING COIL
HPS	HIGH PRESSURE SODIUM	VIB	VIBRATION DETECTOR
		W/	WITH
		WP	WEATHERPROOF

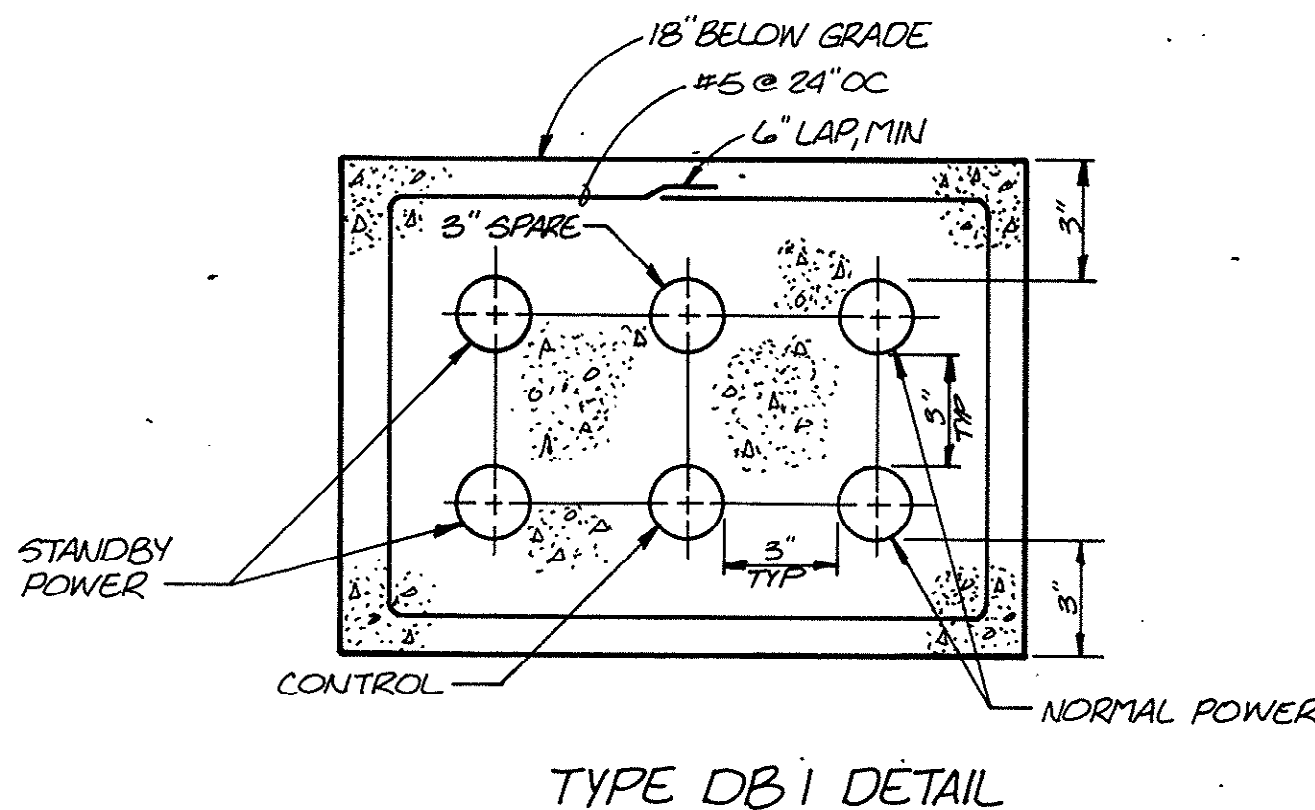

TYPE DB1 DETAIL

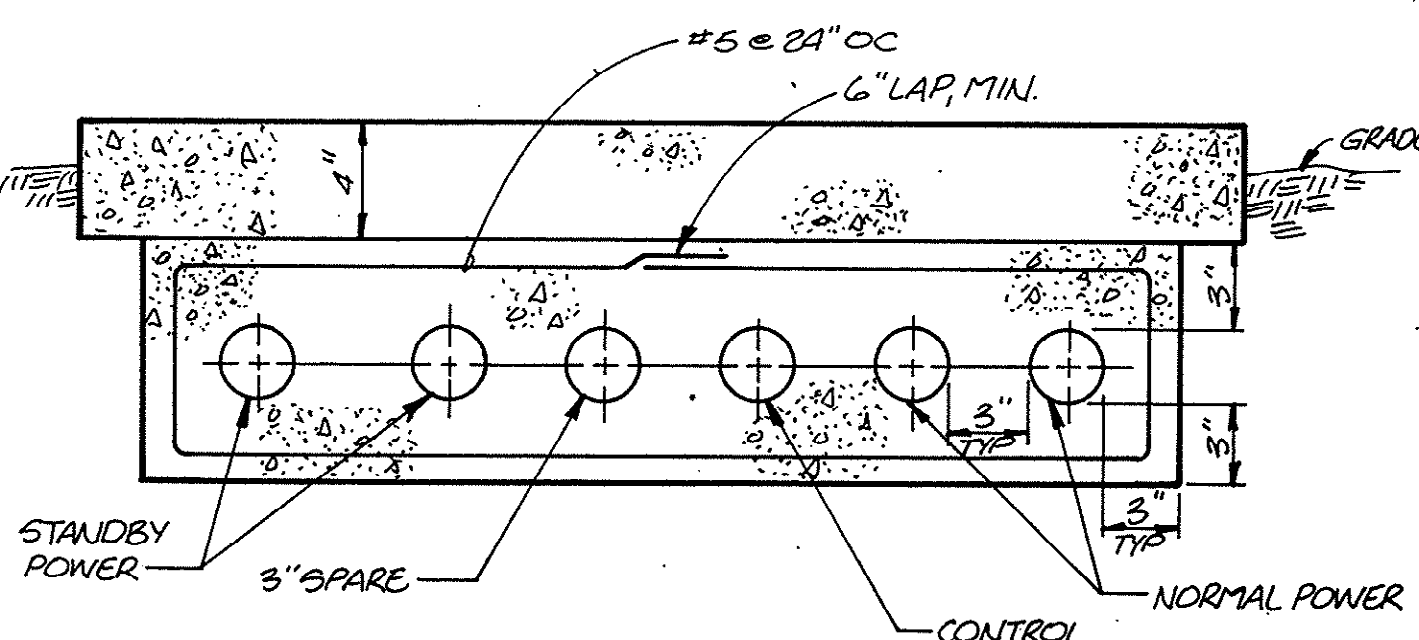


TYPE DB2 DETAIL

NOTE: PROVIDE 6" MINIMUM GRANULAR FILL, 3/4" MINUS, UNDER ALL CONCRETE ENCASED DUCT RUNS.


DUCT BANK DETAILS

NTS

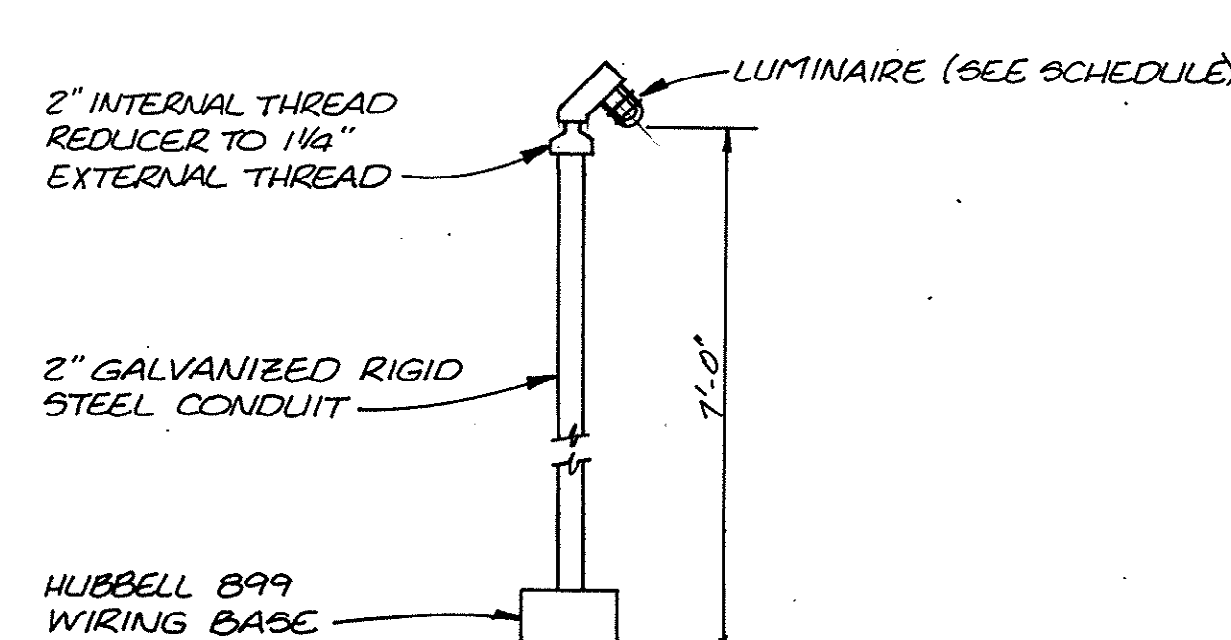


STANCHION MOUNTED LUMINAIRE

NTS

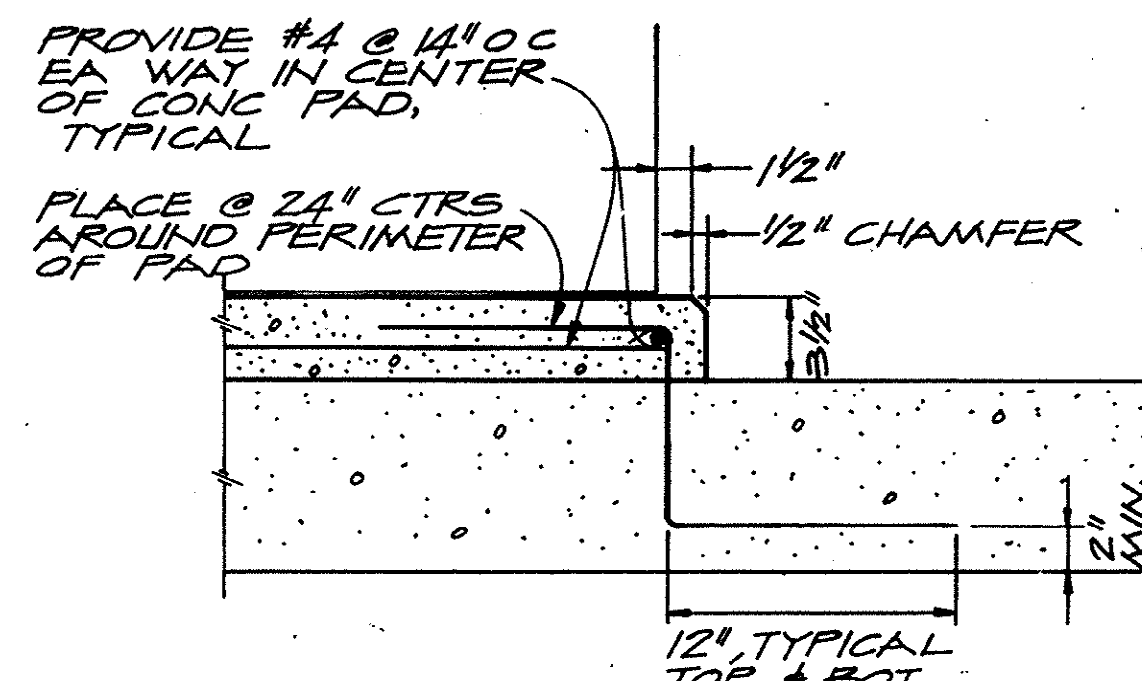


CONCRETE PAD SECTION

NTS

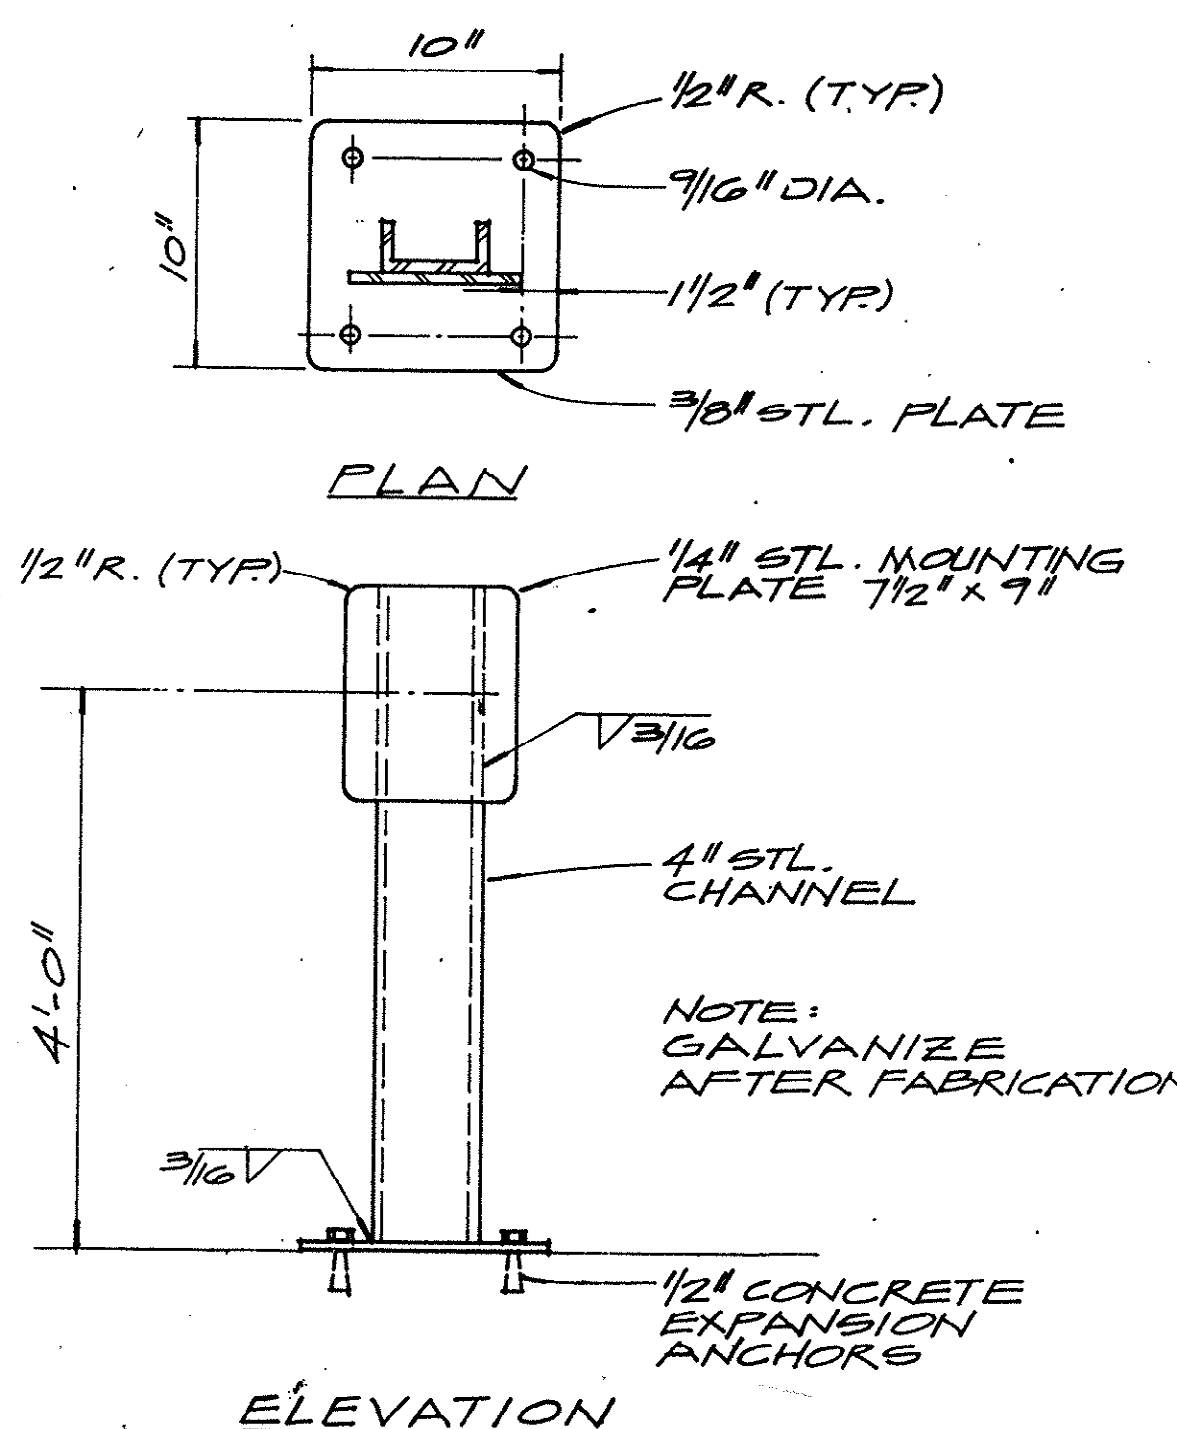


EQUIPMENT MOUNTING PEDESTAL DETAIL

NTS

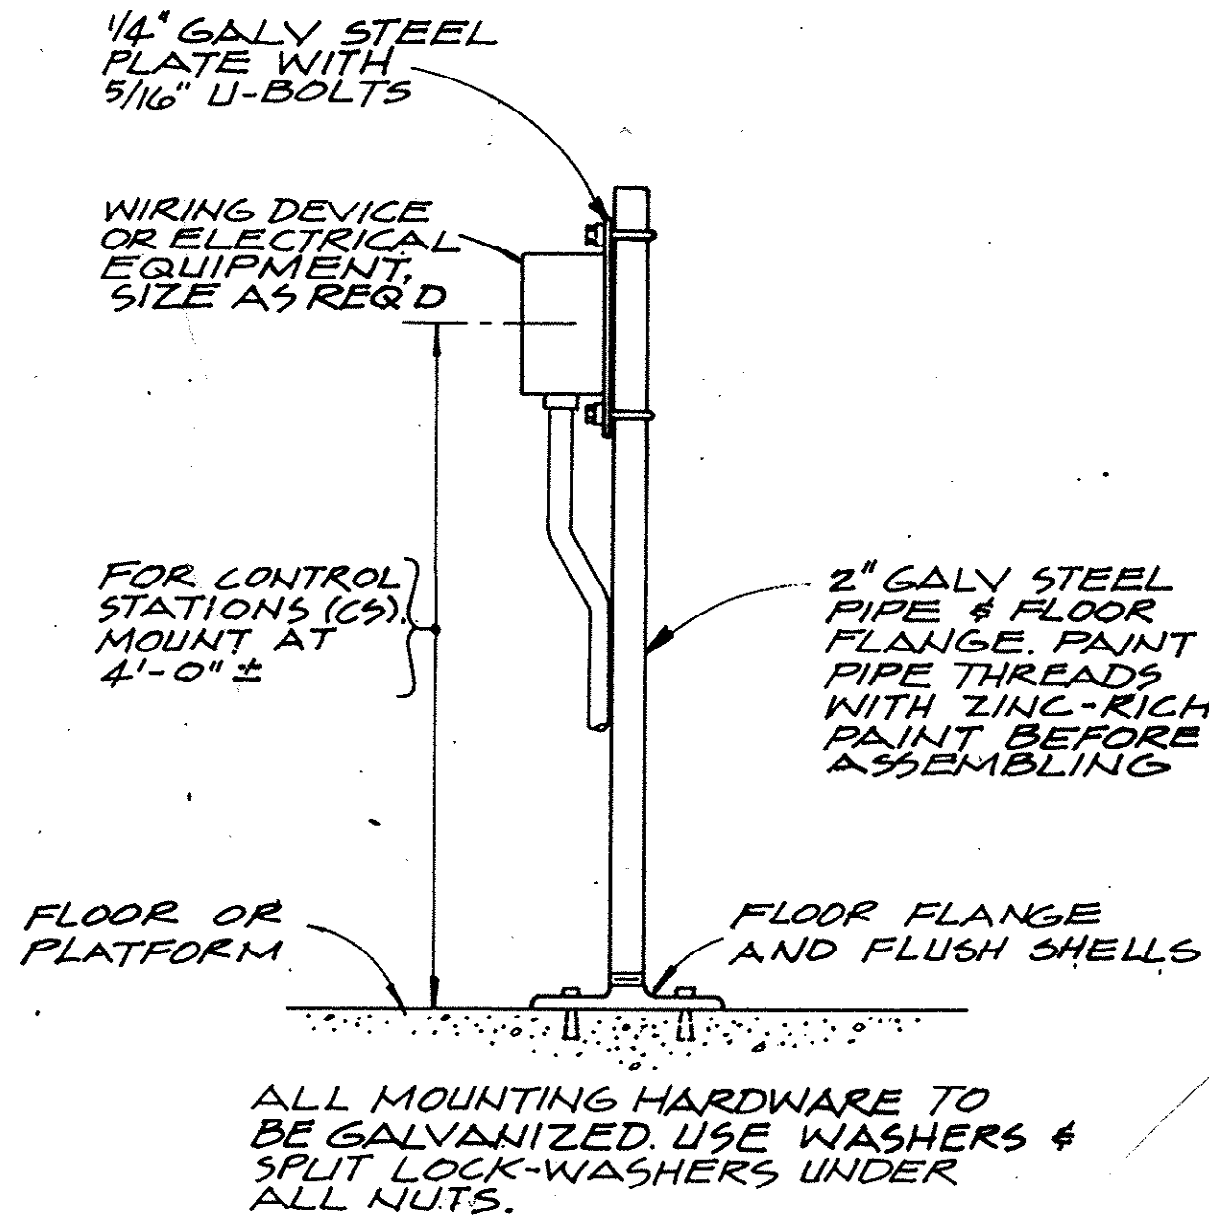

PEDESTAL MOUNTED DETAIL

NTS

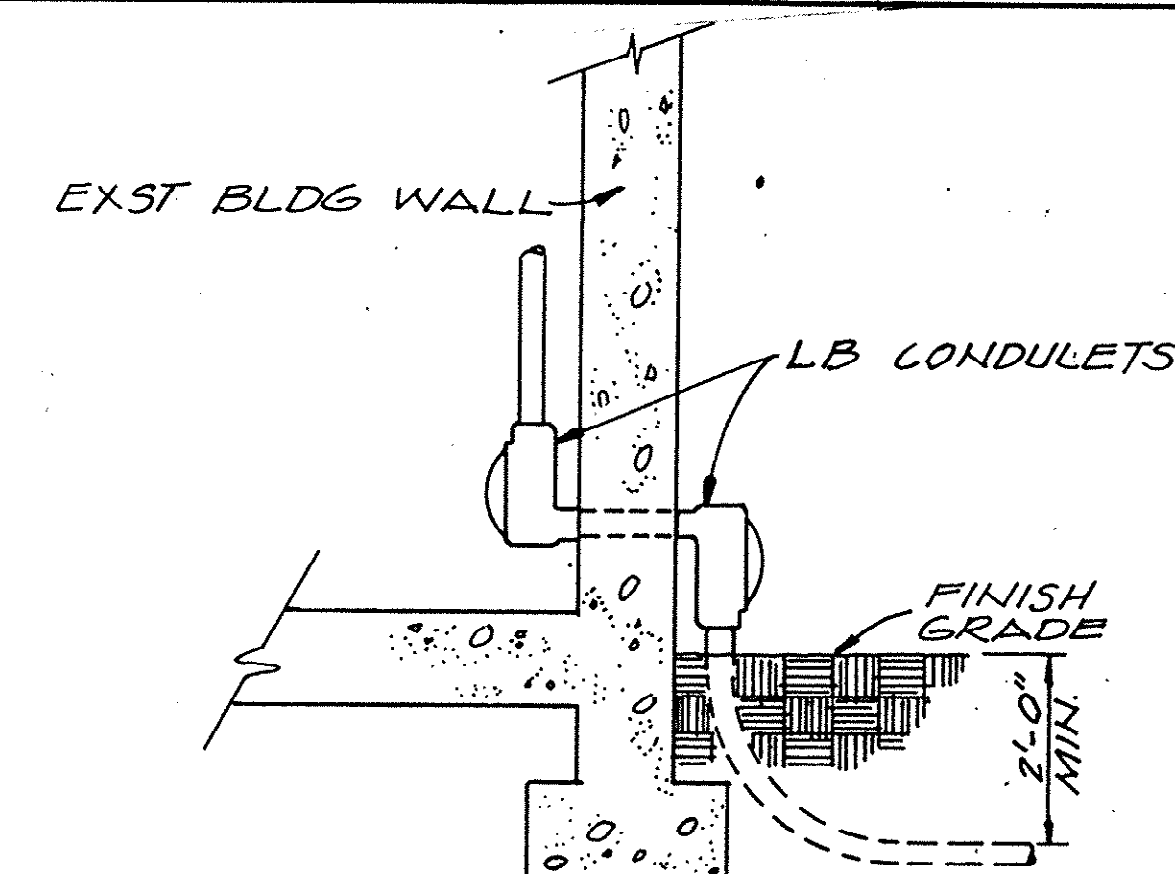

CONDUIT ENTRANCE

NTS

7-05-013-S


REUSE OF DOCUMENTS
THIS DOCUMENT, AND THE IDEAS AND DESIGNS INCORPORATED HEREIN, AS AN INSTRUMENT OF PROFESSIONAL SERVICE, IS THE PROPERTY OF CH2M HILL AND IS NOT TO BE USED, IN WHOLE OR IN PART, FOR ANY OTHER PROJECT WITHOUT THE WRITTEN AUTHORIZATION OF CH2M HILL.

VERIFY SCALES
BAR IS ONE INCH ON ORIGINAL DRAWING.
IF NOT ONE INCH ON THIS SHEET, ADJUST SCALES ACCORDINGLY.

MODIFICATIONS TO THE
J. LAMBERT SCHWARTZ WWTP
THE GRAND STRAND WATER AND SEWER AUTHORITY.



ELECTRICAL DETAILS AND LEGEND

DWG. NO. **E-1**
DATE **AUG 1988**
PROJ. NO. **SA19793.A0**

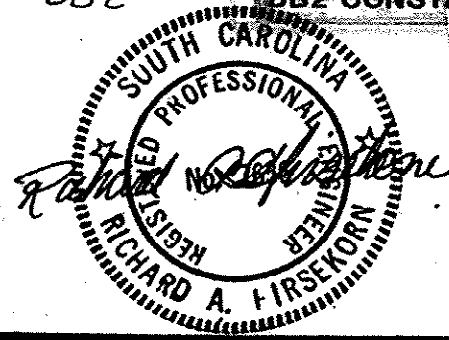


DSGN **R. JOHNSON**
DR **P. OAKES**
CHK **B. NAGEL**
APVD **R.A. HIRSEKORN**

NO.	DATE	REVISION	BY	APVD

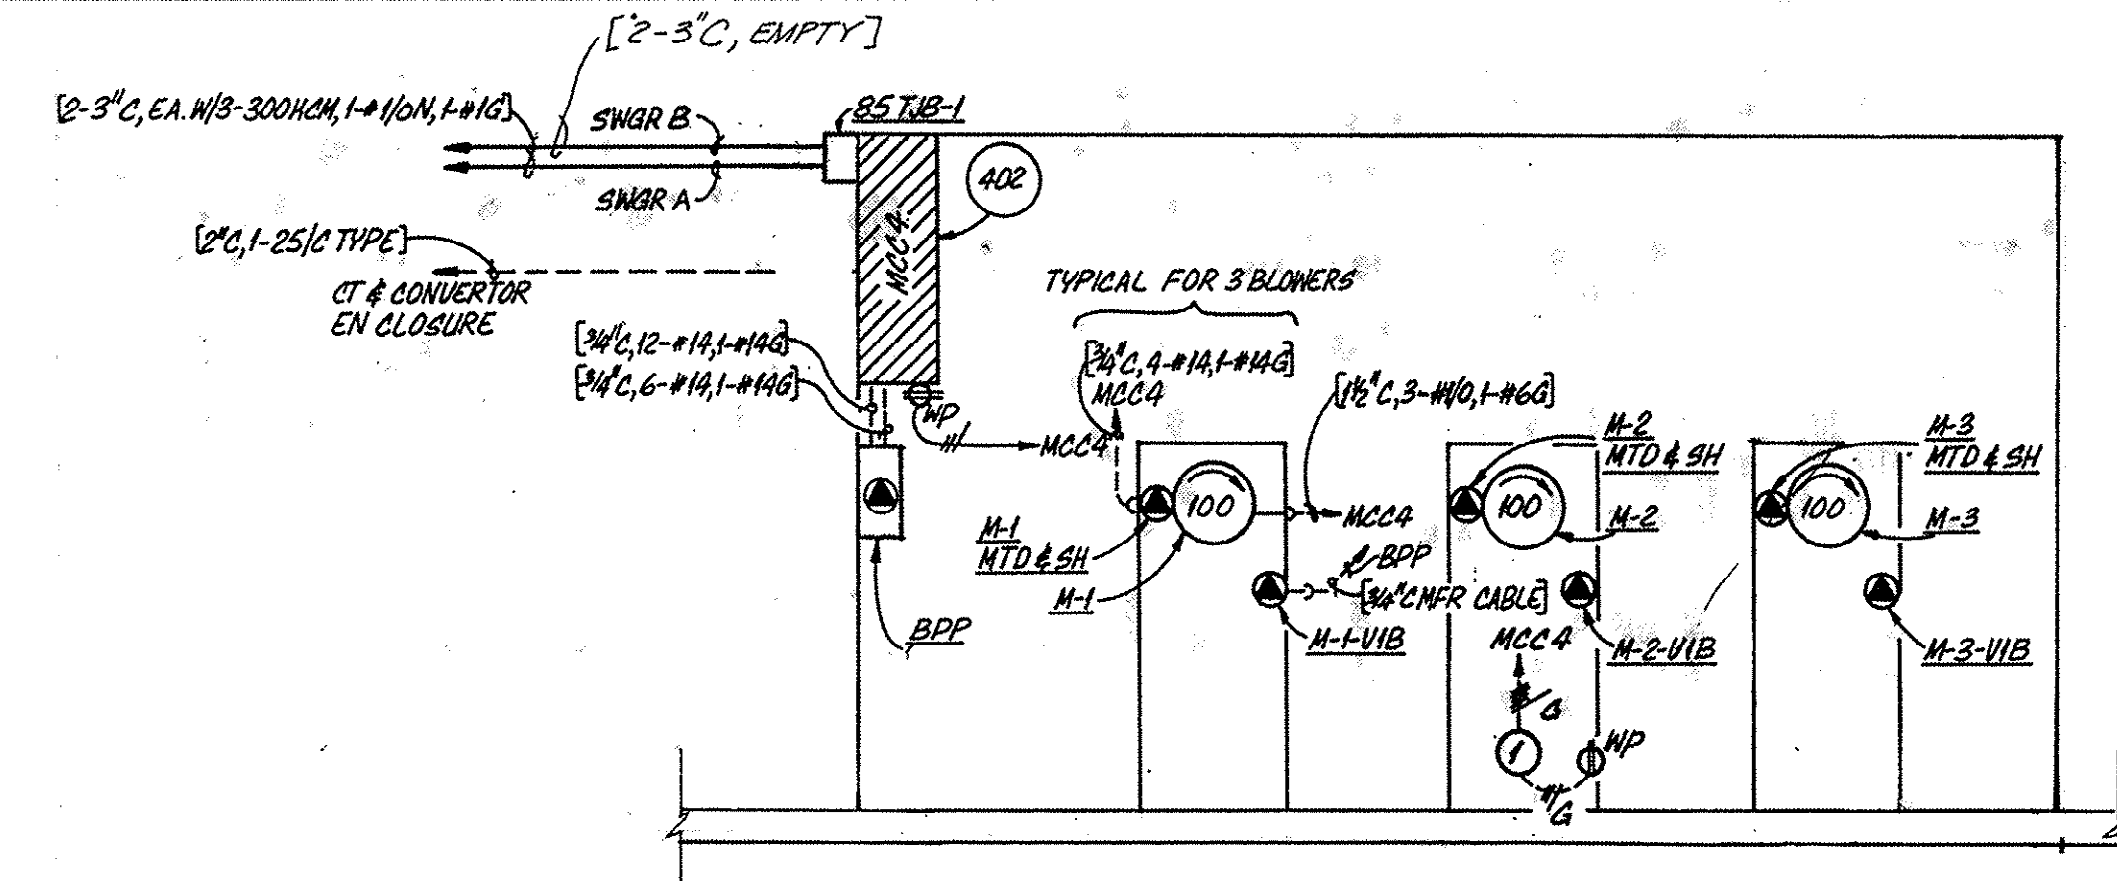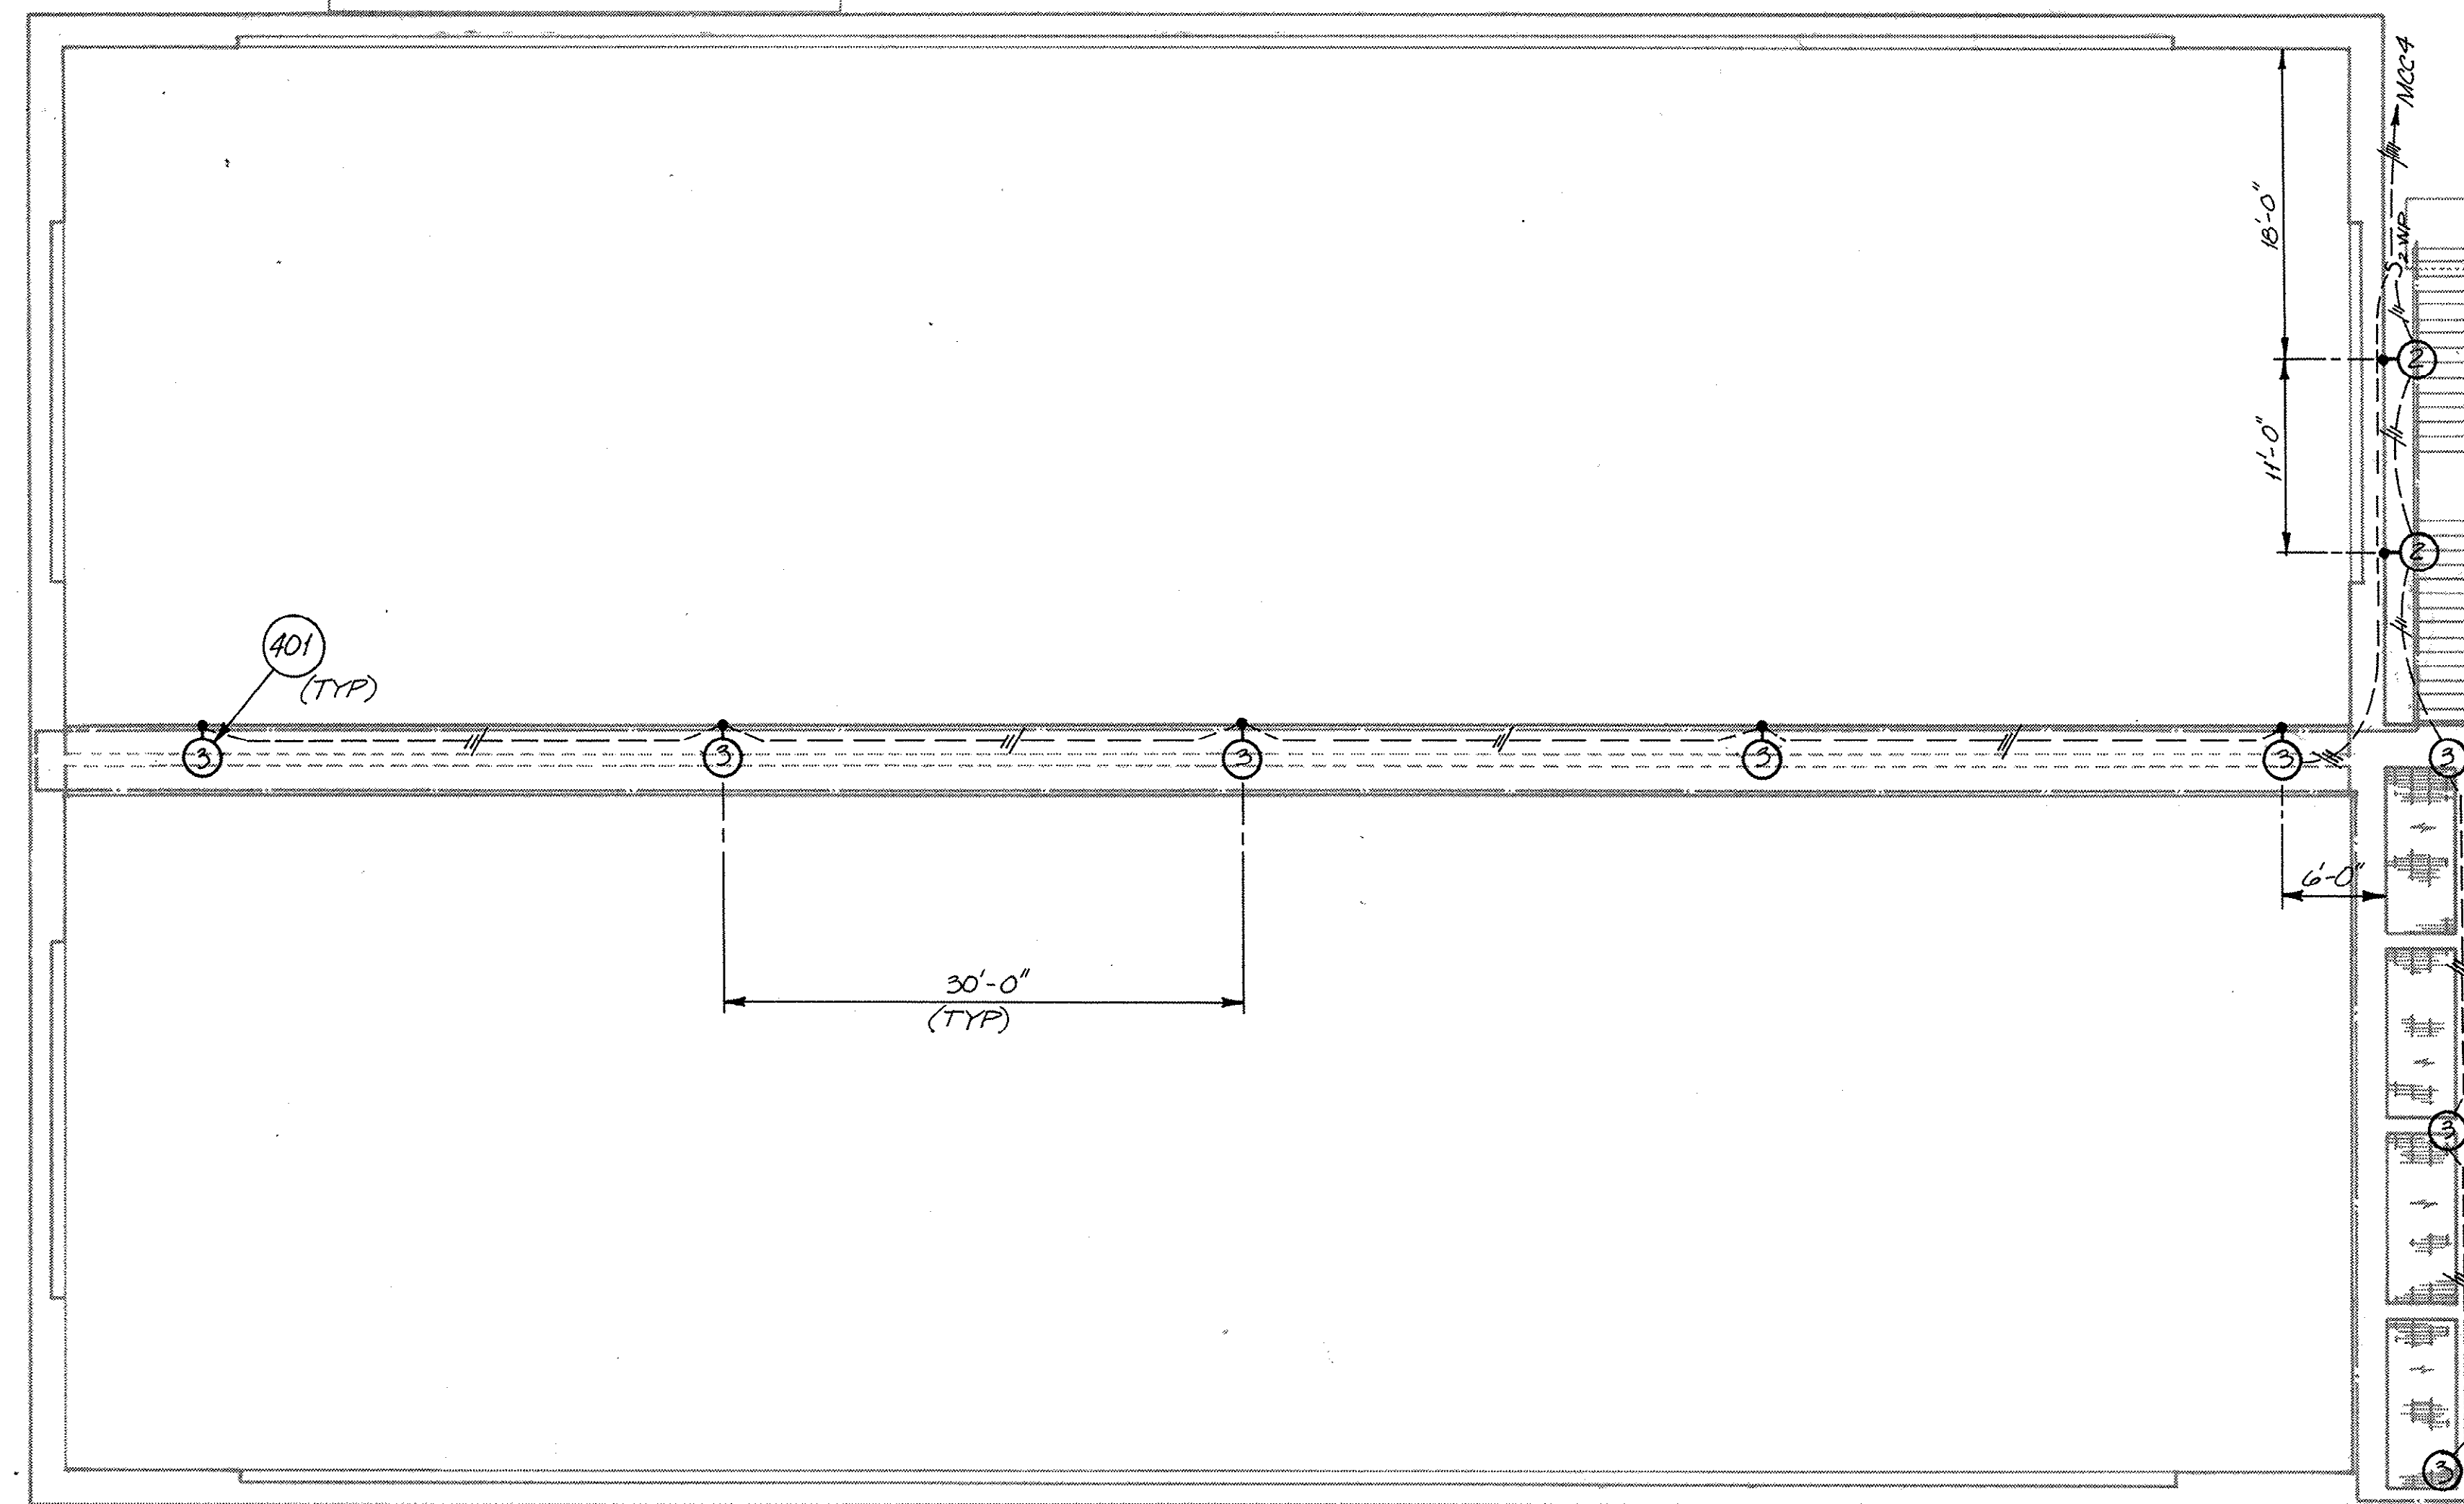


BLOWER FACILITY DETAIL (1)
NTS

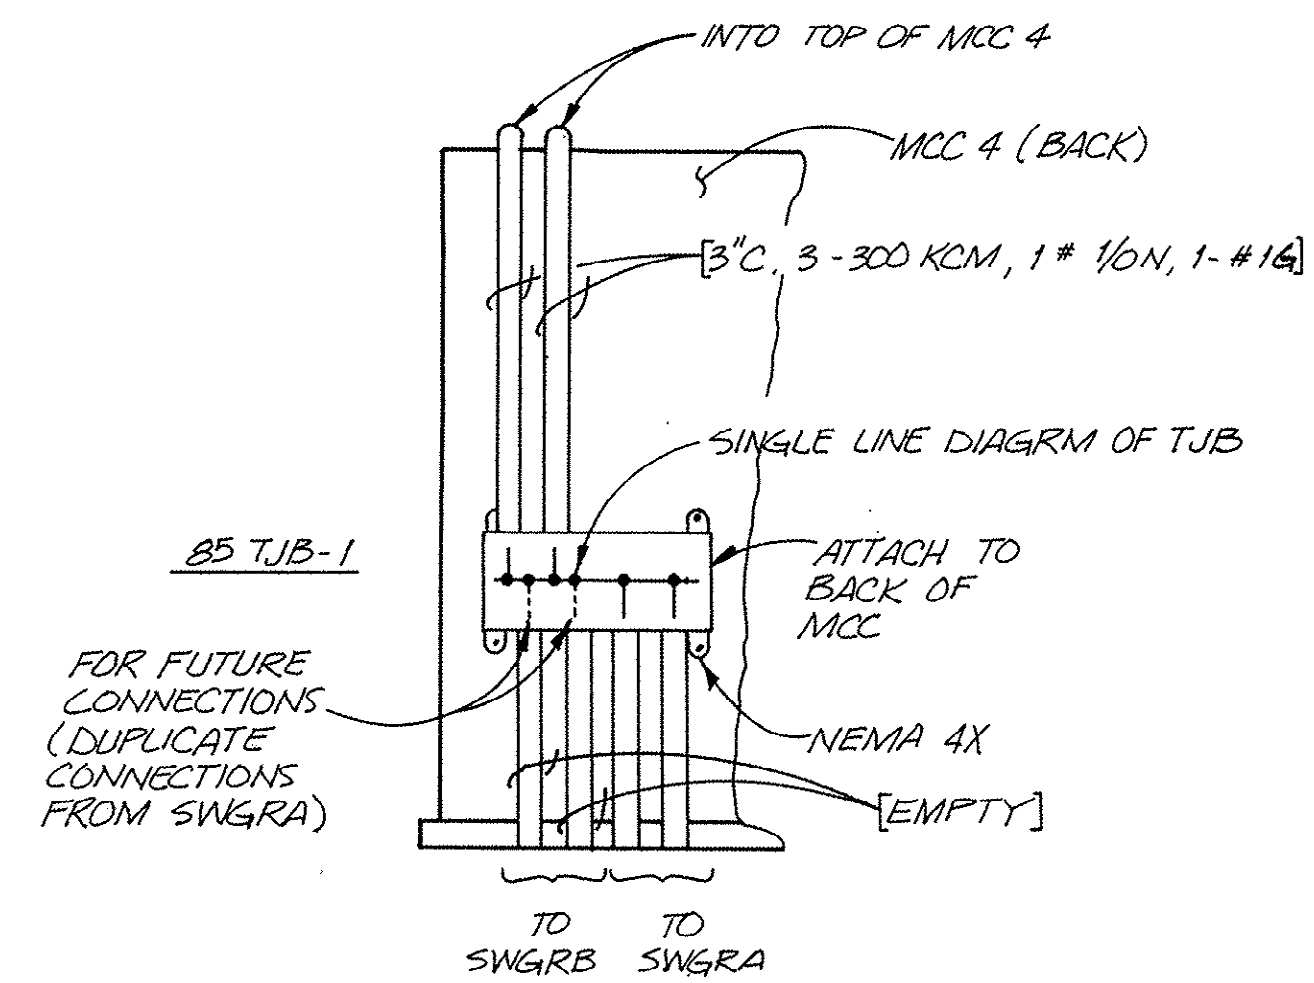

SECTION A
NTS


7-05-015-S

	DSGN	R. JOHNSON		REUSE OF DOCUMENTS THIS DOCUMENT, AND THE IDEAS AND DESIGNS INCORPORATED HEREIN, AS AN INSTRUMENT OF PROFESSIONAL SERVICE, IS THE PROPERTY OF CH2M HILL AND IS NOT TO BE USED, IN WHOLE OR IN PART, FOR ANY OTHER PROJECT WITHOUT THE WRITTEN AUTHORIZATION OF CH2M HILL.	VERIFY SCALES BAR IS ONE INCH ON ORIGINAL DRAWING. 0  1" IF NOT ONE INCH ON THIS SHEET, ADJUST SCALES ACCORDINGLY.	MODIFICATIONS TO THE J. LAMBERT SCHWARTZ WWTP THE GRAND STRAND WATER AND SEWER AUTHORITY	PREAERATION BASIN AND BLOWER FACILITY ELECTRICAL PLAN	SHEET	
	DR	R. JACKSON						DWG NO.	E-3
	CHK	B. NAGEL						DATE	AUG 1985
	APVD	R. HIRSEKORN						PROJ NO.	SA19792.AO
	NO.	DATE	REVISION	BY	APVD				

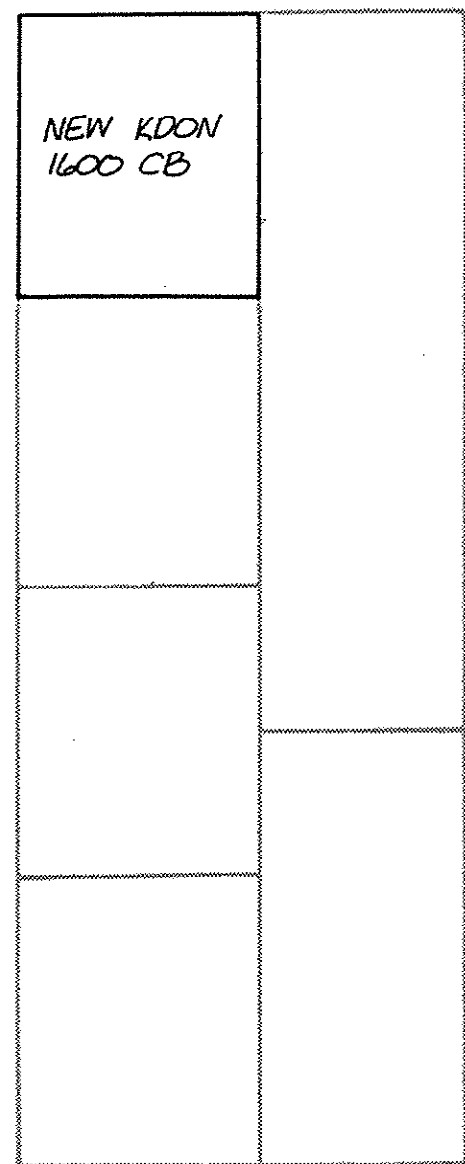


SWITCHGEAR "A"
(NORMAL POWER)

NTS

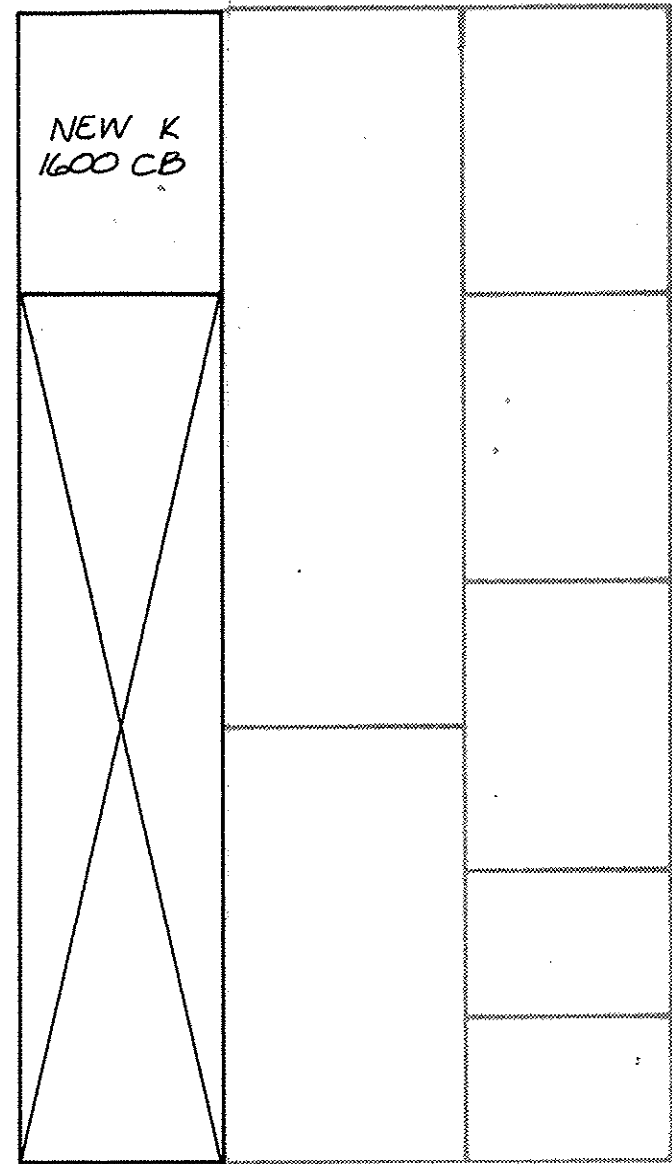

SWITCHGEAR "B"
(EMERGENCY POWER)

NTS

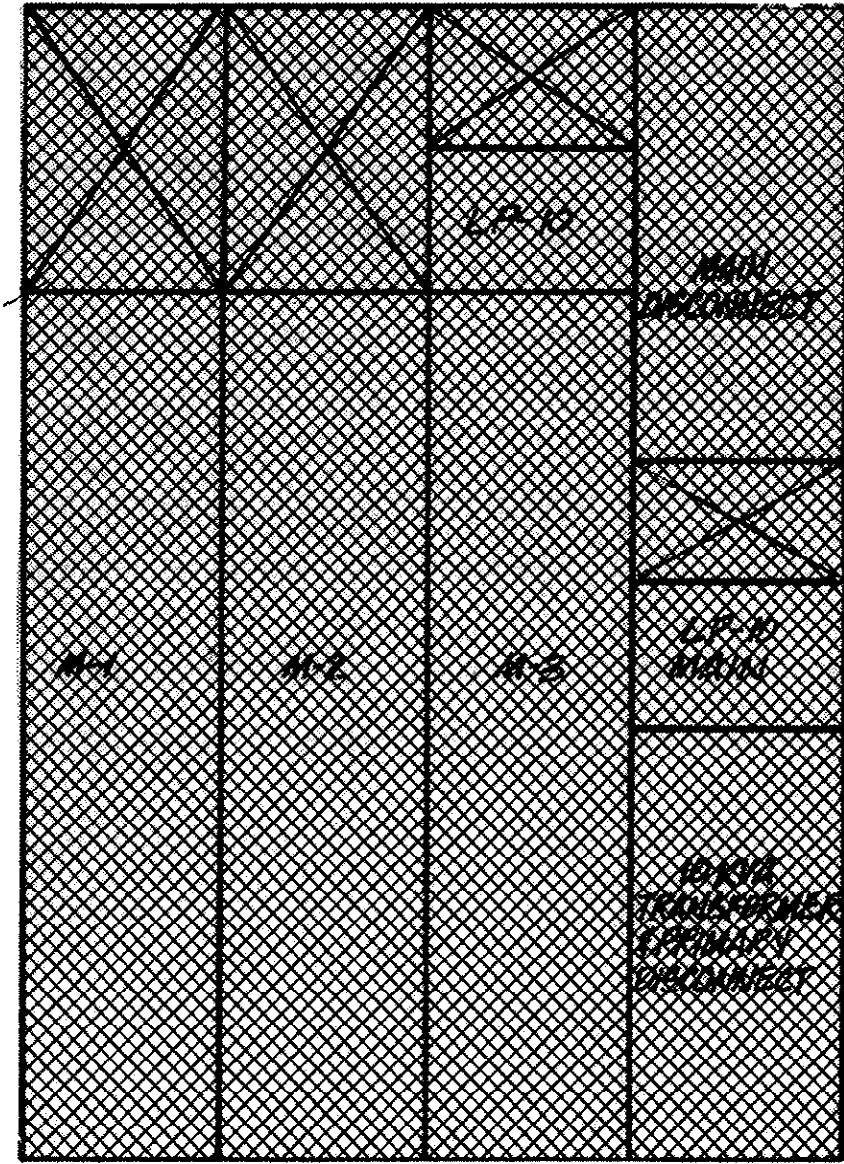

NEMA 3R NON-WALK IN

MCC 4

NTS


INSTALL NEW CT'S AND
CONVERTERS TO MATCH
EXISTING ITEMS IN
OTHER R.B.C. UNITS

		B-21	
		B-22	
		B-23	
		B-24	

**C.T. & CONVERTER
ENCLOSURE**


NTS

NOTE: NOT IN CONTRACT

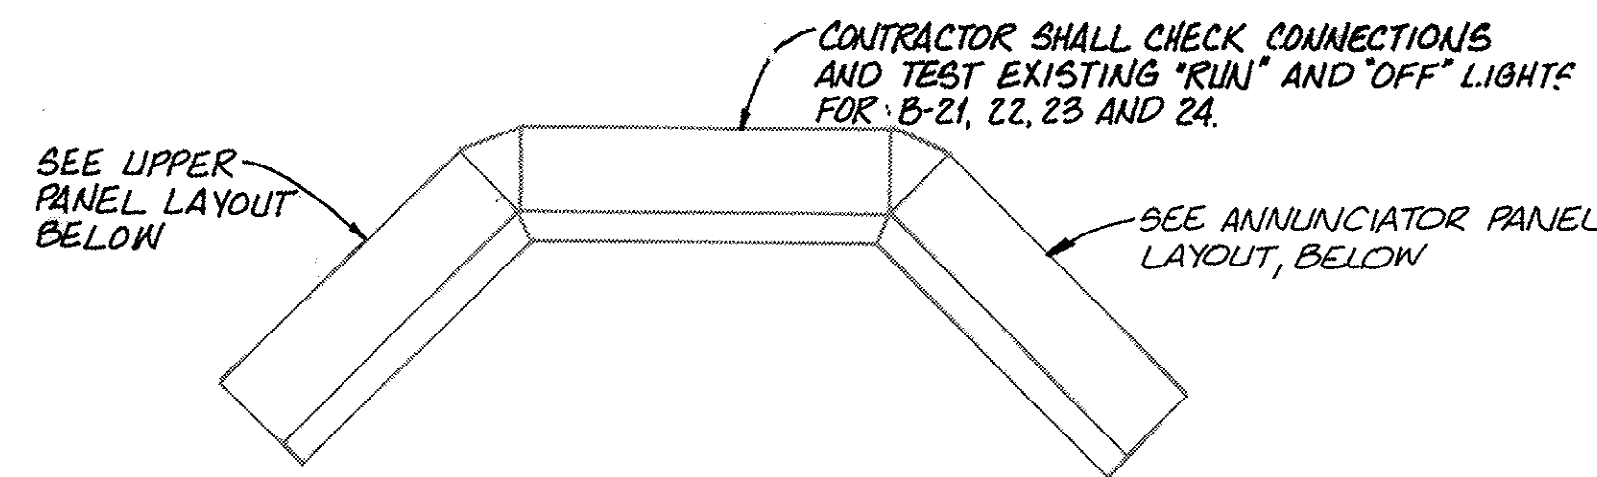

CONTROL CONSOLE PLAN


NTS

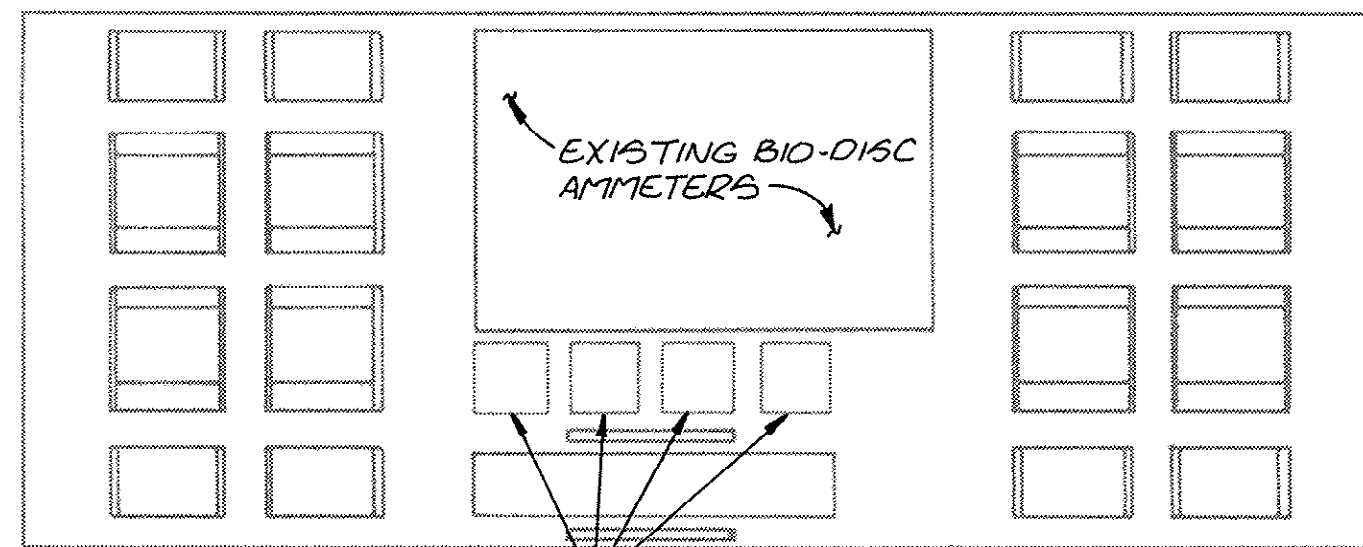

CONTRACTOR SHALL CHECK CONNECTIONS
AND TEST EXISTING AMMETERS FOR
B-21, B-22, B-23 & B-24.


UPPER PANEL LAYOUT

NTS

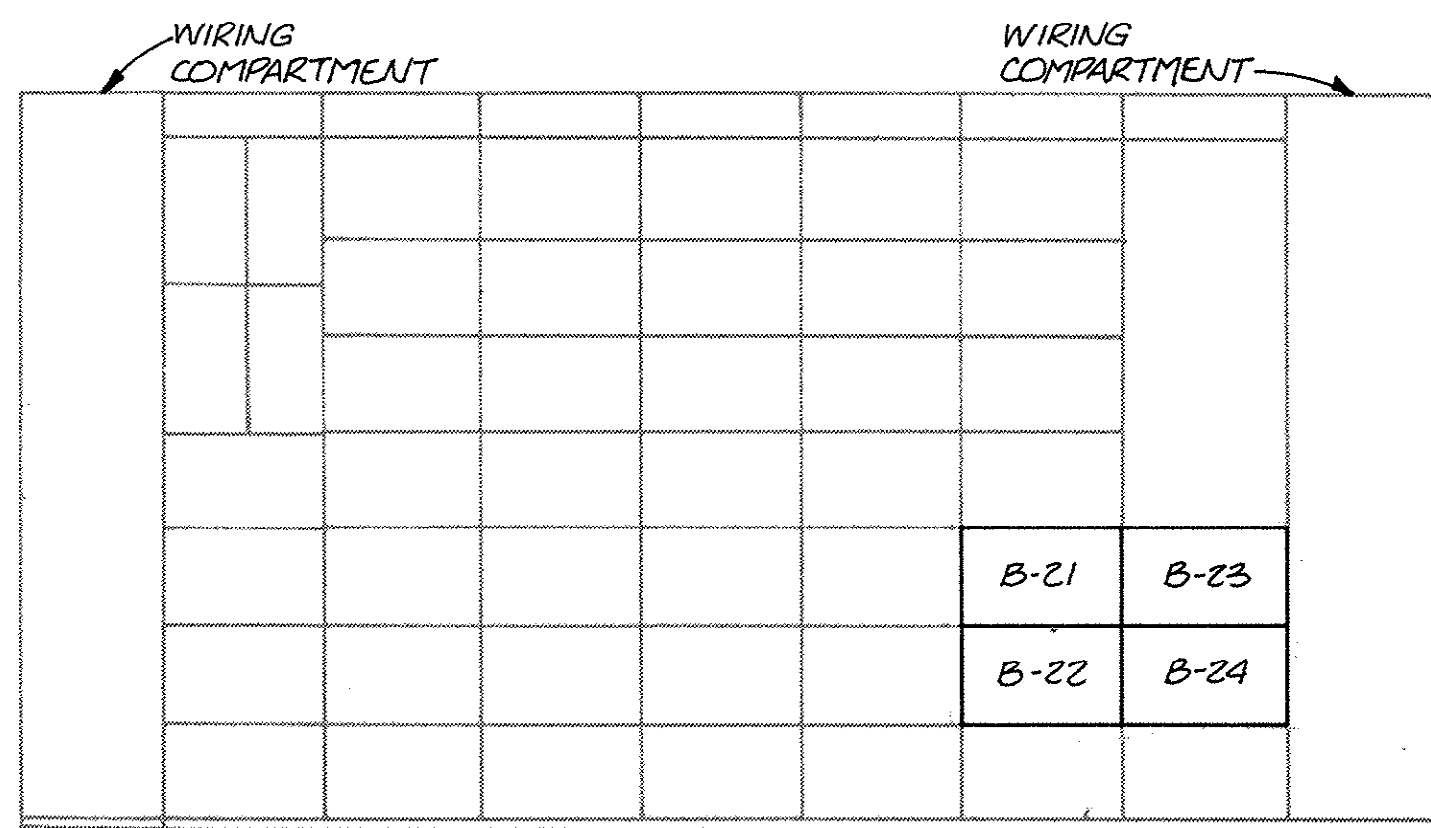

MCC 1

NTS

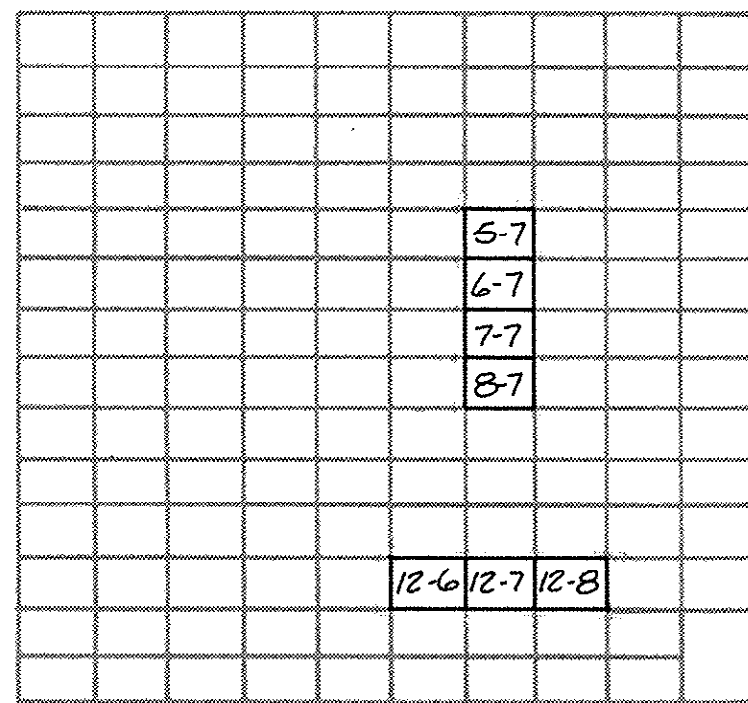

NOTES:


1. CONTRACTOR SHALL CONNECT CIRCUIT, ENGRAVE WINDOWS
AND TEST ANNUNCIATORS ACCORDING TO THE FOLLOWING:

POSITION	WINDOW ENGRAVING	FROM
5-7	ROTATING DISC MOTOR NO. B-21 DISAGREE	MCC 1
6-7	ROTATING DISC MOTOR NO. B-22 DISAGREE	MCC 1
7-7	ROTATING DISC MOTOR NO. B-23 DISAGREE	MCC 1
8-7	ROTATING DISC MOTOR NO. B-24 DISAGREE	MCC 1
12-6	PRE AERATION BLOWER 1 DISAGREE	MCC 4
12-7	PRE AERATION BLOWER 2 DISAGREE	MCC 4
12-8	PRE AERATION BLOWER 3 DISAGREE	MCC 4

2. IF POSITIONS SHOWN ARE NOT VACANT, ARRANGE NEW
ANNUNCIATORS IN VACANT SPACES, AS NEAR AS POSSIBLE
TO PROCESS ORDER.

ANNUNCIATOR PANEL LAYOUT

NTS

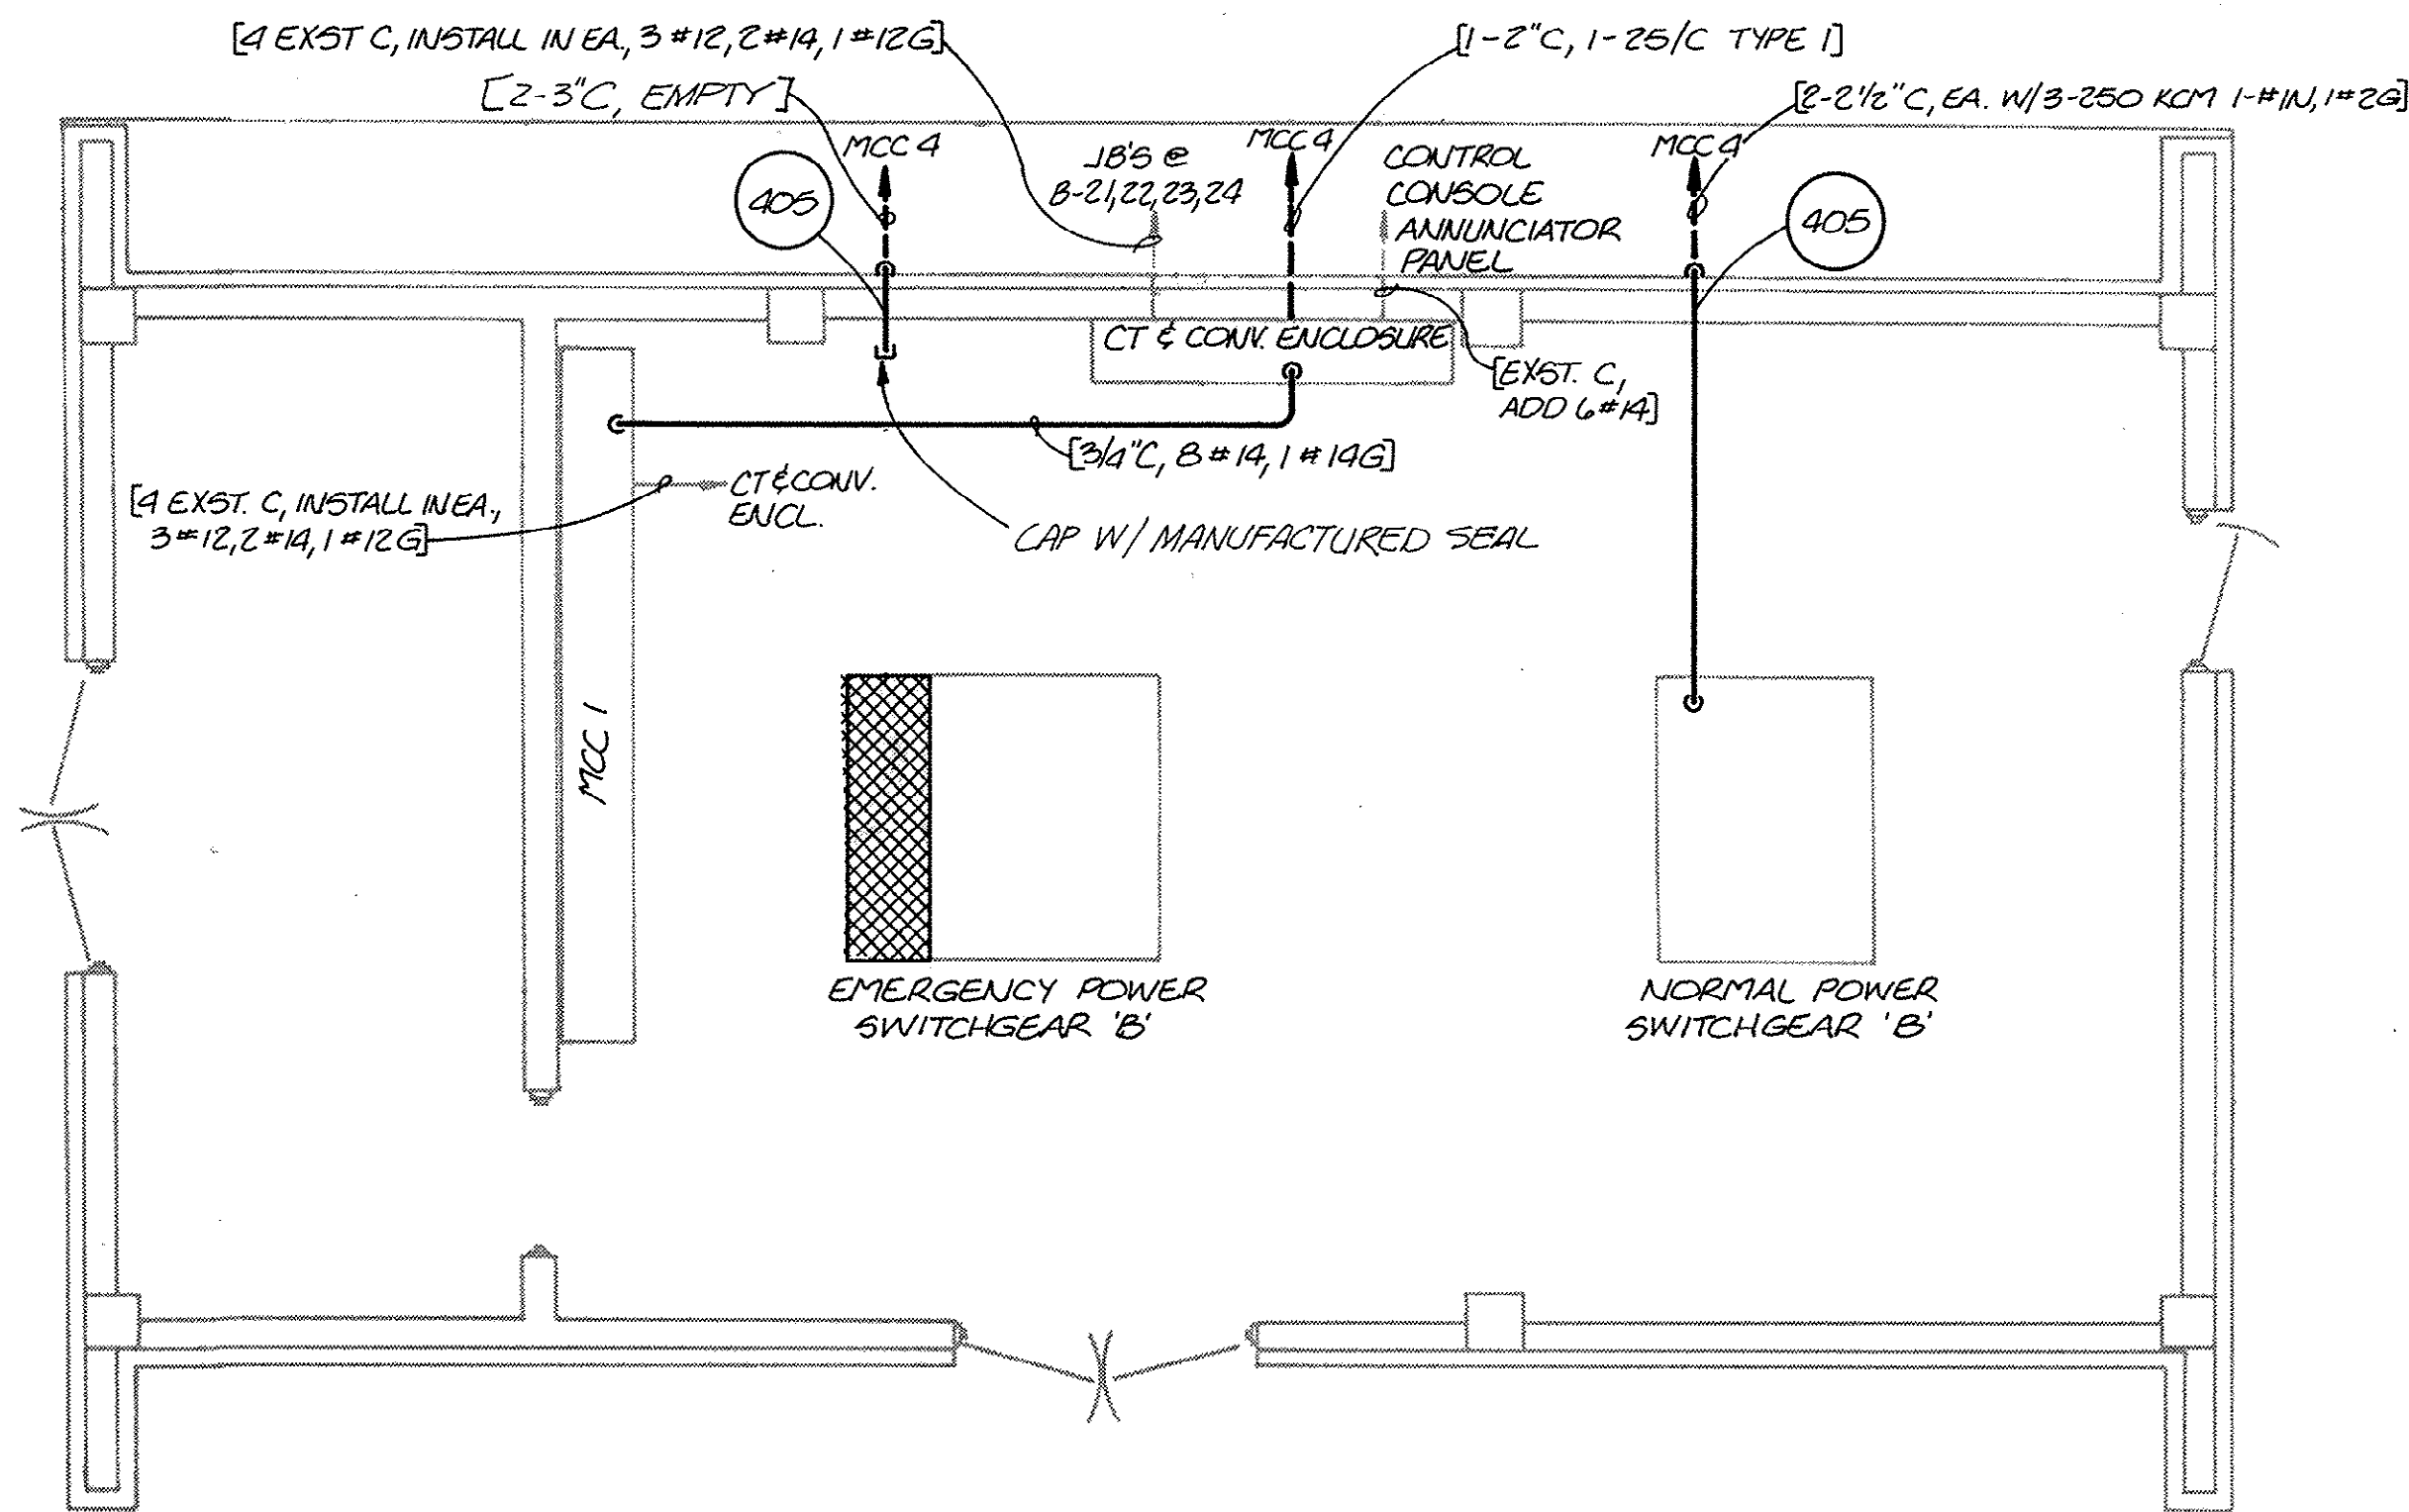

ELECTRICAL BUILDING

NTS

7-05-016-S



DSGN
R. JOHNSON
DR
M. HALE
CHK
B. NAGEL
APVD
R.A. HIRSEKORN

NO. DATE

REVISION

BY

APVD

©CH2M HILL

REUSE OF DOCUMENTS

THIS DOCUMENT, AND THE IDEAS AND DESIGNS INCORPORATED HEREIN, AS AN INSTRUMENT OF PROFESSIONAL SERVICE, IS THE PROPERTY OF CH2M HILL AND IS NOT TO BE USED, IN WHOLE OR IN PART, FOR ANY OTHER PROJECT WITHOUT THE WRITTEN AUTHORIZATION OF CH2M HILL.

VERIFY SCALES

BAR IS ONE INCH ON ORIGINAL DRAWING.
IF NOT ONE INCH ON THIS SHEET, ADJUST SCALES ACCORDINGLY.


MODIFICATIONS
TO THE
J. LAMBERT SCHWARTZ WWTP

THE GRAND STRAND
WATER AND SEWER AUTHORITY


**ELECTRICAL PLANS AND
EQUIPMENT ELEVATIONS**

DWG
NO. **E-4**
DATE **AUG 1985**
PROJ
NO. **SA19793.A0**

REVISIONS
DATE
BY
REMARKS
1
2
3
1000

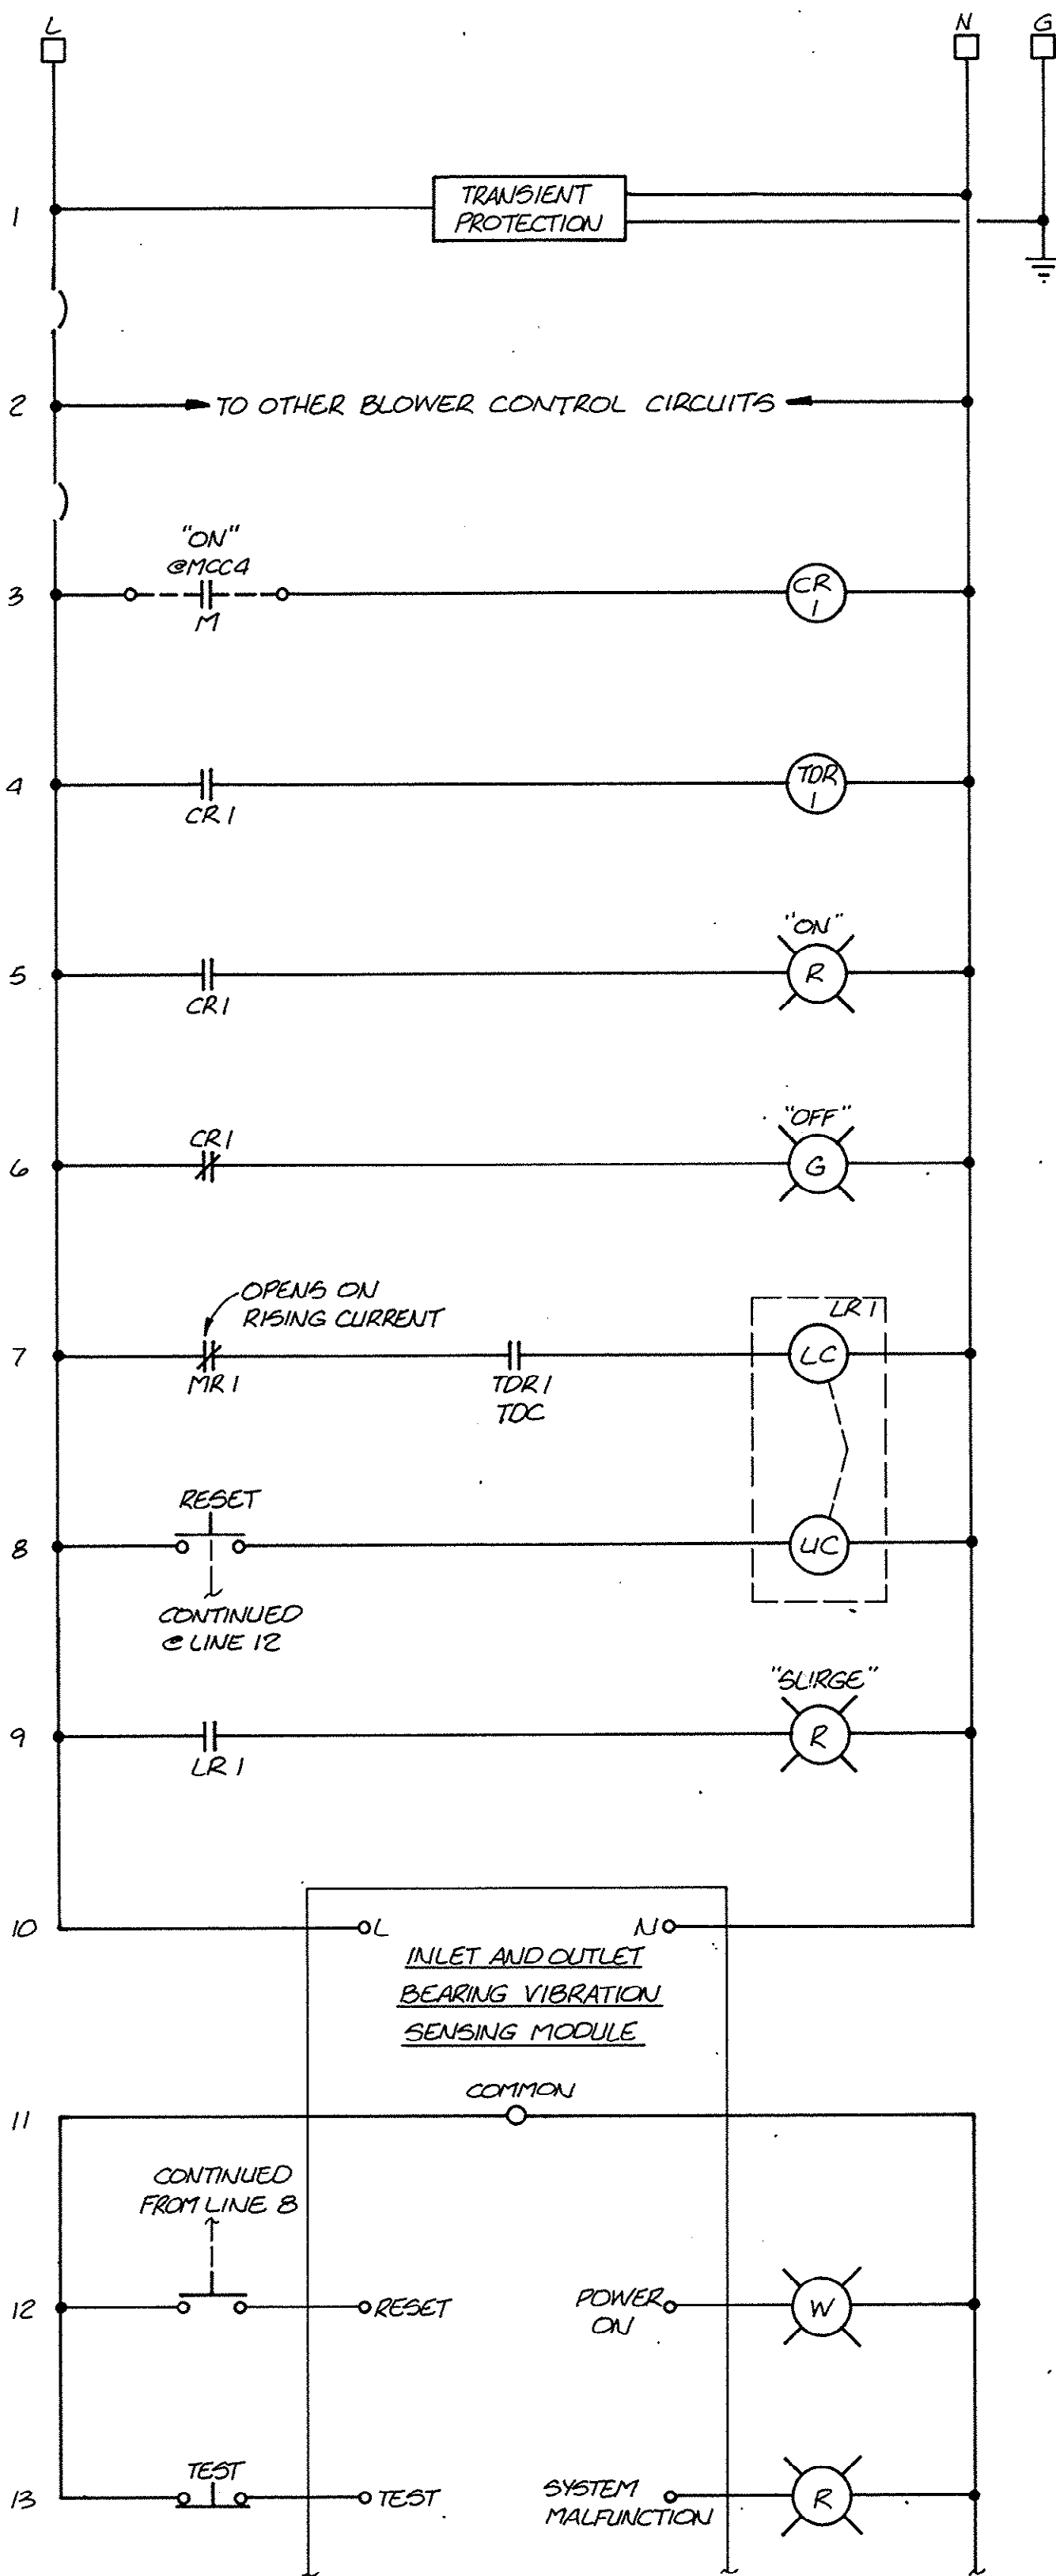

BPP FUNCTIONAL ELEMENTARY CONTROL DIAGRAM
NTS

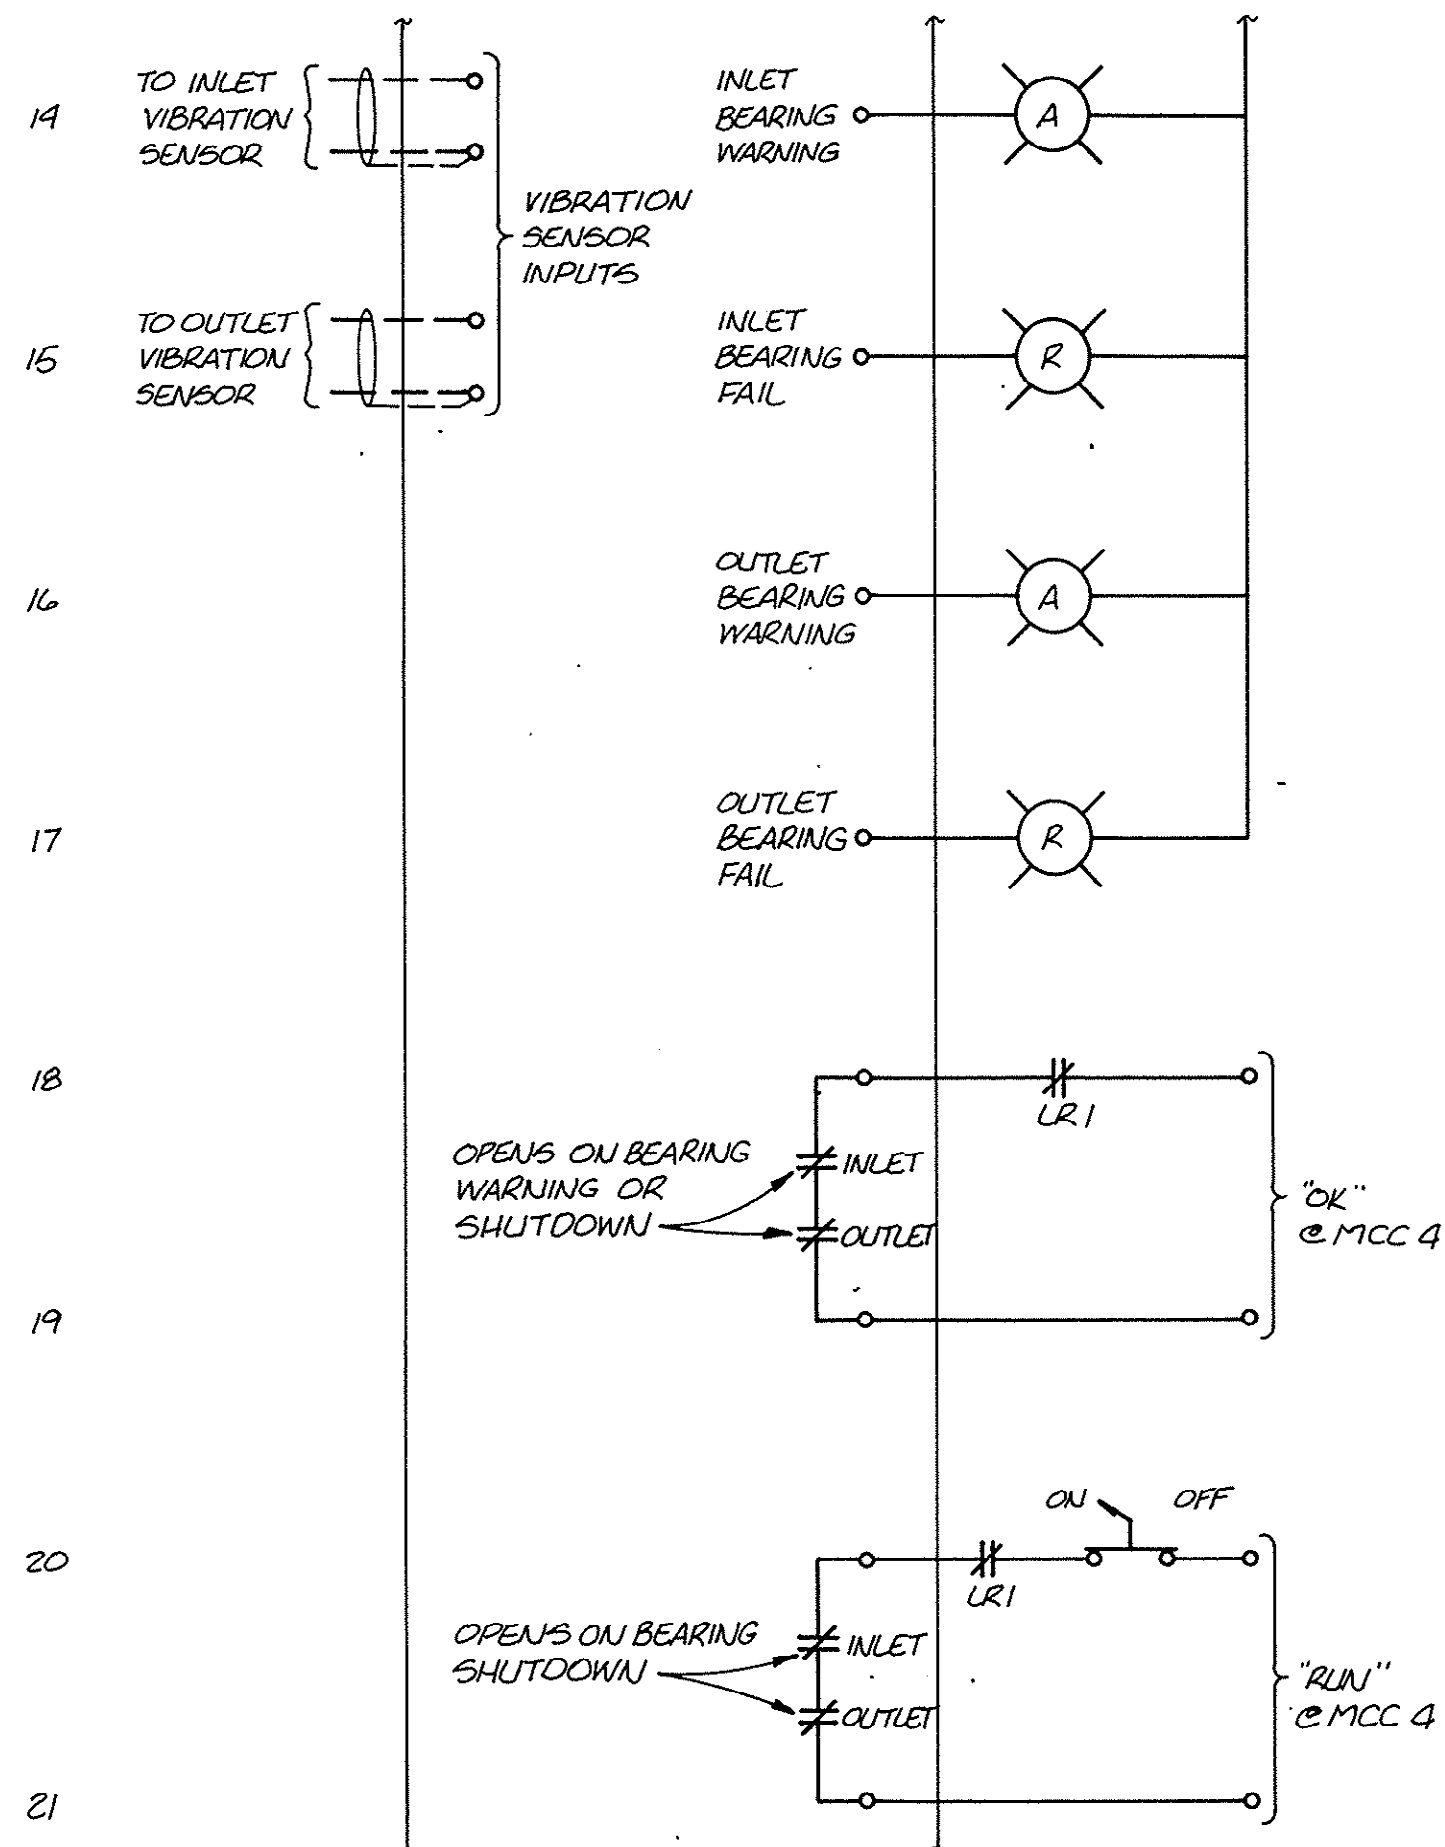

NOTES:
1. LINES 3 THRU 21 ARE TYPICAL FOR EACH BLOWER.
2. GASKET ALL METERS TO CONFORM TO ENCLOSURE TYPE.

LUMINAIRE SCHEDULE							
SYMBOL	TYPE	VOLTAGE	DESCRIPTION	MANUFACTURER	CATALOG NO.	LAMPS	MOUNTING
①	H.P.S. AREA	120 V	H.I.D. WET LOCATION FIXTURE W/ PHOTO CONTROL	HI-TEK	TW 150 S 120 PE	150 W H.P.S.	WALL, 8' A.F.F.
②	ENCLOSED INCAND.	120V	WET LOCATION FIXTURE W/ GLOBE AND GUARD	APPLETON	VG AT 1075 G	150 W A21	WALL, 7' A.F.F.
③	ENCLOSED INCAND.	120V	45° WET LOCATION FIXTURE W/ GLOBE AND GUARD	APPLETON	V MAN 20125-A	200 W F530	STANCHION

PANEL LP-10 LOCATION:MCC 4
SERVICE-VOLTAGE: 208Y/120 3 PHASE 4 WIRE
TYPE:LD A MLO
FULL NEUTRAL FEEDER SIZE: AS SHOWN
IN MCC MOUNTING

CIRCUIT TITLE	BKR	CKT NO.	CKT NO.	BKR	CIRCUIT TITLE
BLOWER PAD LIGHTS	15/1	1	2	20/1	RECEPTACLES
WALKWAY & STAIR LIGHTS	20/2	3	4	15/1	BPP
		5	6	20/1	SPARE
SPARE	20/1	7	8	20/1	SPARE
SPARE	15/1	9	10	15/1	SPARE
SPACE		11	12		SPACE

7-05-017-3



DSGN R. JOHNSON
DR M. HALES
CHK W. PEARSON
APVD R.A. HIRSEKORN

NO. DATE REVISION BY APVD


REUSE OF DOCUMENTS
THIS DOCUMENT, AND THE IDEAS AND DESIGNS INCORPORATED HEREIN, AS AN INSTRUMENT OF PROFESSIONAL SERVICE, IS THE PROPERTY OF CH2M HILL AND IS NOT TO BE USED, IN WHOLE OR IN PART, FOR ANY OTHER PROJECT WITHOUT THE WRITTEN AUTHORIZATION OF CH2M HILL.

VERIFY SCALES
BAR IS ONE INCH ON ORIGINAL DRAWING.
IF NOT ONE INCH ON THIS SHEET, ADJUST SCALES ACCORDINGLY.

MODIFICATIONS TO THE
J. LAMBERT SCHWARTZ WWTP
THE GRAND STRAND
WATER AND SEWER AUTHORITY

WIRING DIAGRAMS AND SCHEDULES

DWG NO. E-5
DATE AUG 1985
PROJ NO. SA19793.A0

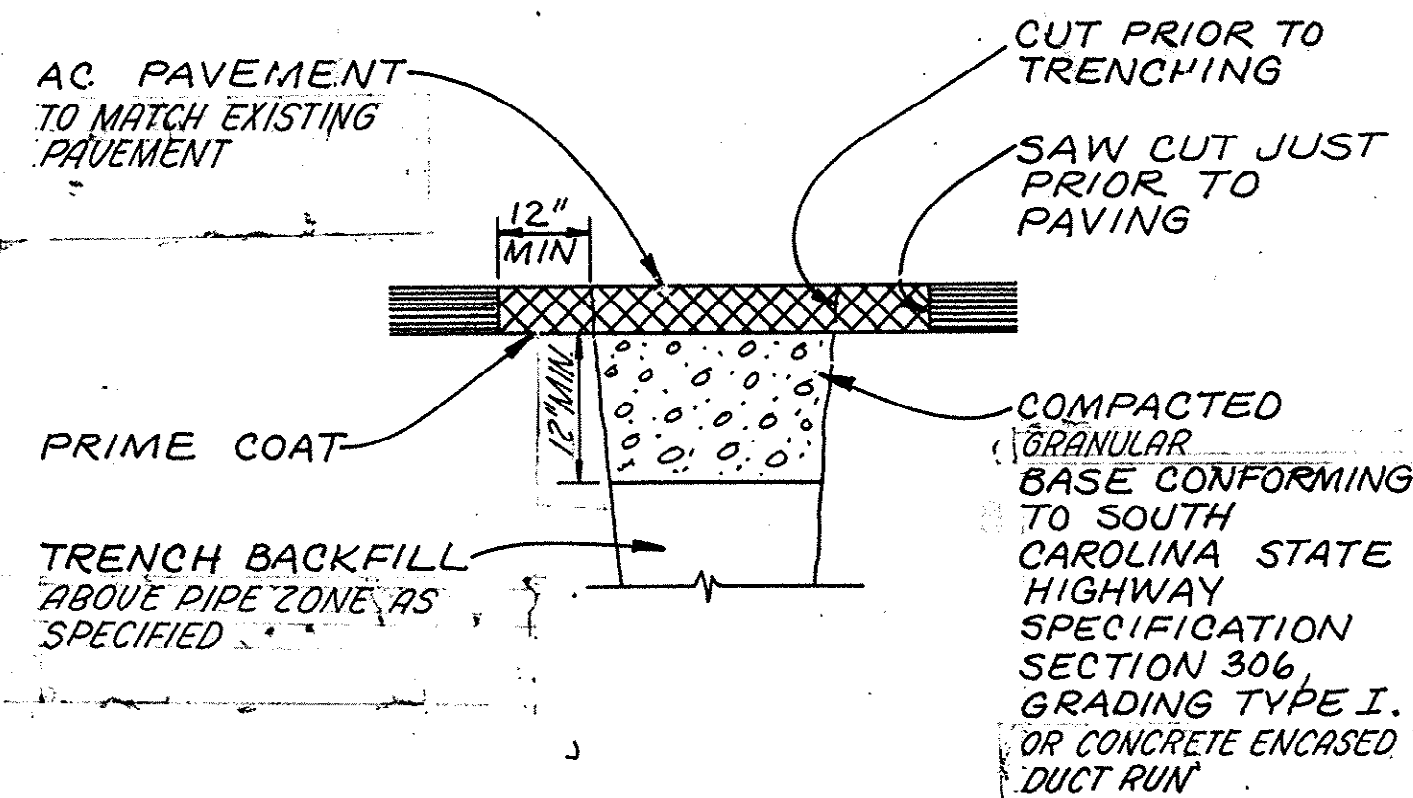

NOTES:

1. PRIME COAT: MC-30 OR RC-30 FOR PRIMING THE PREPARED BASE COURSE. THE MATERIAL USED SHALL MEET THE REQUIREMENTS OF SUBSECTIONS 406.03 AND 406.04 OF THE SOUTH CAROLINA STATE HIGHWAY SPECIFICATIONS.

2. THE ASPHALT CONCRETE FOR PAVING DESIGNATED AREAS SHALL BE A HOT PLANT MIX AND SHALL CONFORM TO THE REQUIREMENTS OF SECTION 403 OF THE SOUTH CAROLINA STATE HIGHWAY SPECIFICATIONS FOR TYPE 1 SURFACE COURSE.

ASPHALT CONCRETE


SURFACE RESTORATION

DETAIL OF REINFORCEMENT - LAP LENGTHS						
BAR SIZE	#6 OR SMALLER	#7	#8	#9	#10	#11
CONC DESIGN STRENGTH 3000 PSI						
GR 40 TOP BAR*	34 DIA, MIN 1'-6"	3'-0"	3'-9"	4'-8"	6'-0"	7'-3"
OTHER BAR	24 DIA, MIN 1'-0"	2'-0"	2'-8"	3'-4"	4'-4"	5'-2"
GR 60 TOP BAR*	49 DIA, MIN 2'-0"	4'-2"	5'-6"	7'-0"	8'-8"	10'-10"
OTHER BAR	36 DIA, MIN 1'-6"	3'-0"	4'-0"	5'-0"	6'-6"	7'-9"
CONC DESIGN STRENGTH 3500 PSI						
GR 40 TOP BAR*	33 DIA, MIN 1'-6"	2'-9"	3'-6"	4'-4"	5'-6"	6'-8"
OTHER BAR	24 DIA, MIN 1'-0"	1'-10"	2'-6"	3'-2"	4'-0"	4'-10"
GR 60 TOP BAR*	47 DIA, MIN 2'-0"	3'-10"	5'-2"	6'-6"	8'-2"	10'-0"
OTHER BAR	34 DIA, MIN 1'-6"	2'-10"	3'-9"	4'-8"	6'-0"	7'-3"
CONC DESIGN STRENGTH 4000 PSI						
GR 40 TOP BAR*	32 DIA, MIN 1'-6"	2'-6"	3'-3"	4'-0"	5'-0"	6'-4"
OTHER BAR	22 DIA, MIN 1'-0"	1'-9"	2'-4"	3'-0"	3'-8"	4'-6"
GR 60 TOP BAR*	45 DIA, MIN 2'-0"	3'-8"	4'-9"	6'-0"	7'-8"	9'-6"
OTHER BAR	32 DIA, MIN 1'-6"	2'-8"	3'-6"	4'-4"	5'-6"	6'-9"

*TOP BARS SHALL BE DEFINED AS ANY HORIZONTAL BARS PLACED SUCH THAT MORE THAN 12" OF FRESH CONCRETE IS CAST IN THE MEMBER BELOW THE BAR, IN ANY SINGLE POUR. HORIZONTAL WALL BARS ARE CONSIDERED TOP BARS.


6. CONT GALV STL WS AS SPEC, SHALL BE INSTALLED IN ALL CJ IN WALLS OF WATER HOLDING BASINS AND CHANNELS, EXCEPT WHERE INDICATED OTHERWISE.

7. PROVIDE AND INSTALL SELECT GRANULAR MATERIAL AS SPECIFIED UNDER ALL SLABS AND FOOTINGS TO UNDISTURBED EARTH WITH MINIMUM THICKNESS EQUAL TO 6", UNLESS OTHERWISE NOTED.

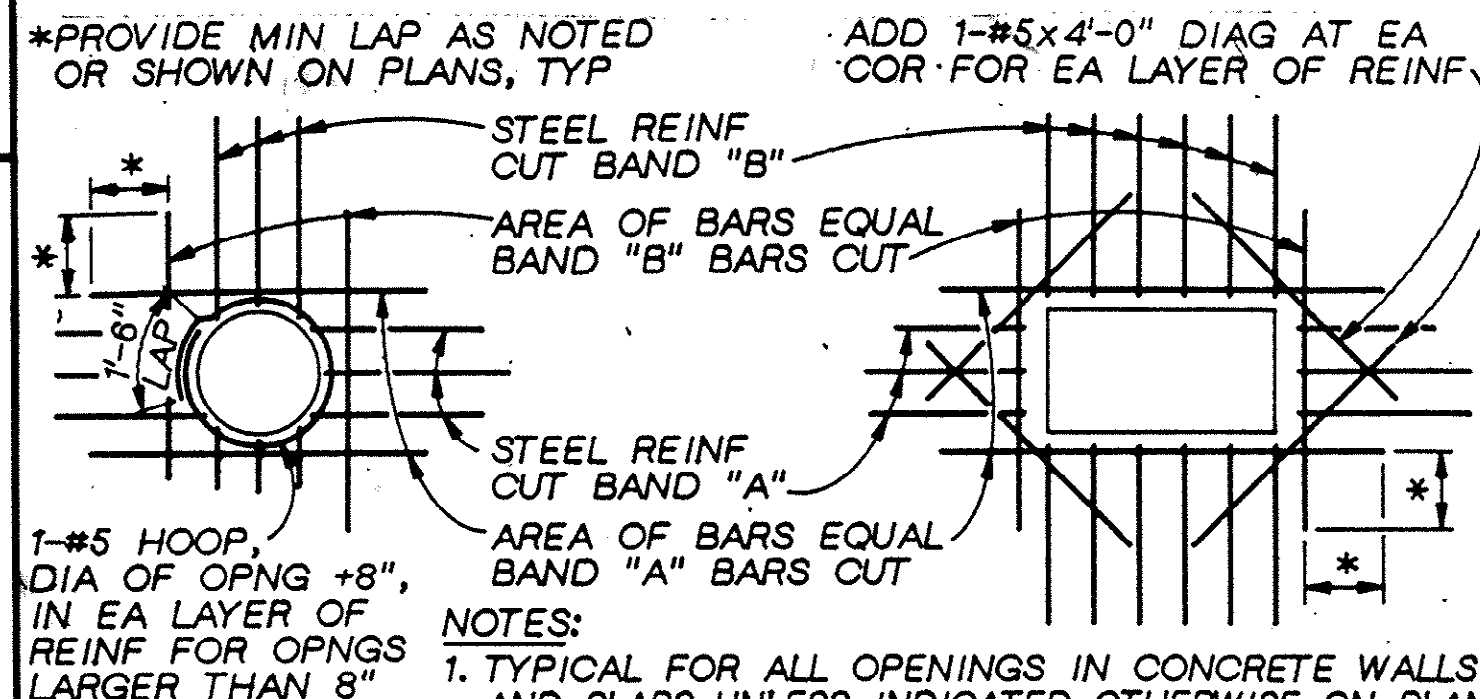


OPENING REINFORCING

NTS

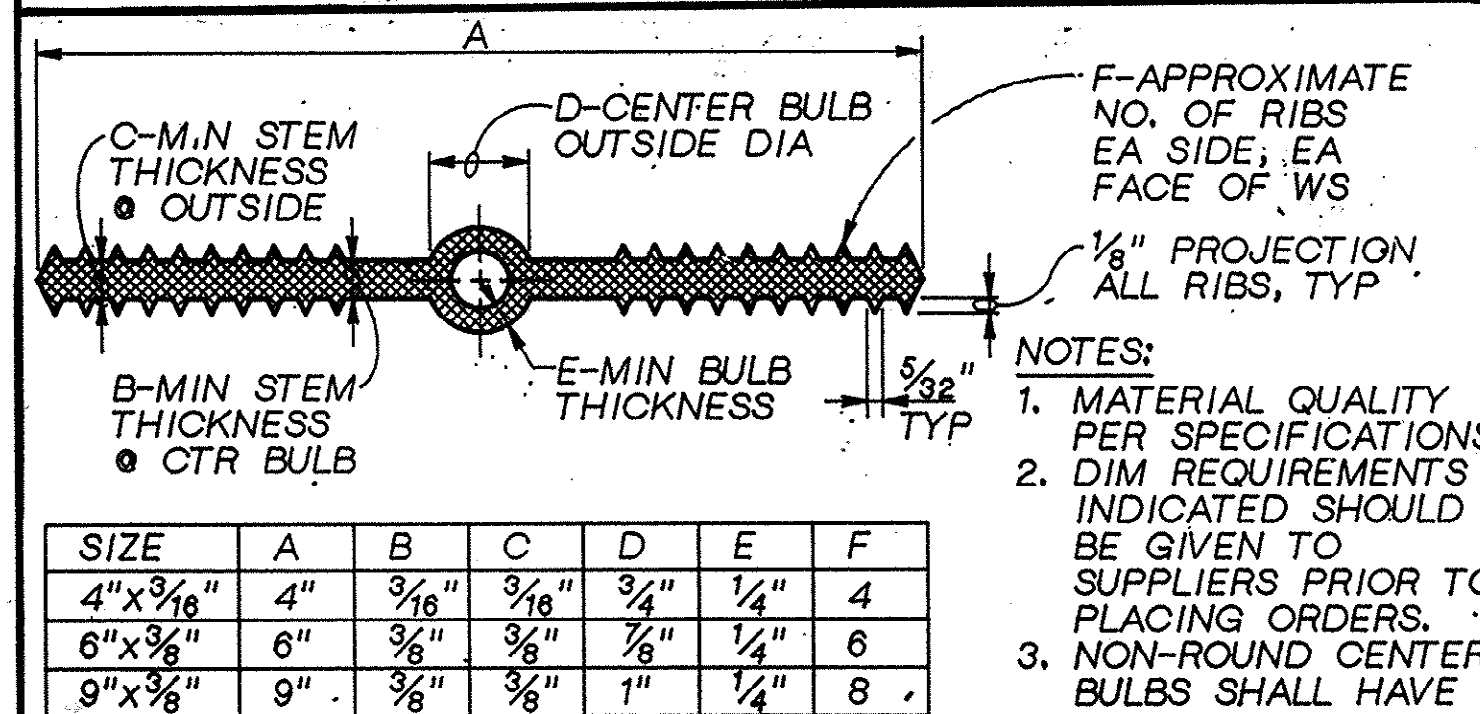


PLASTIC WATERSTOP

NTS

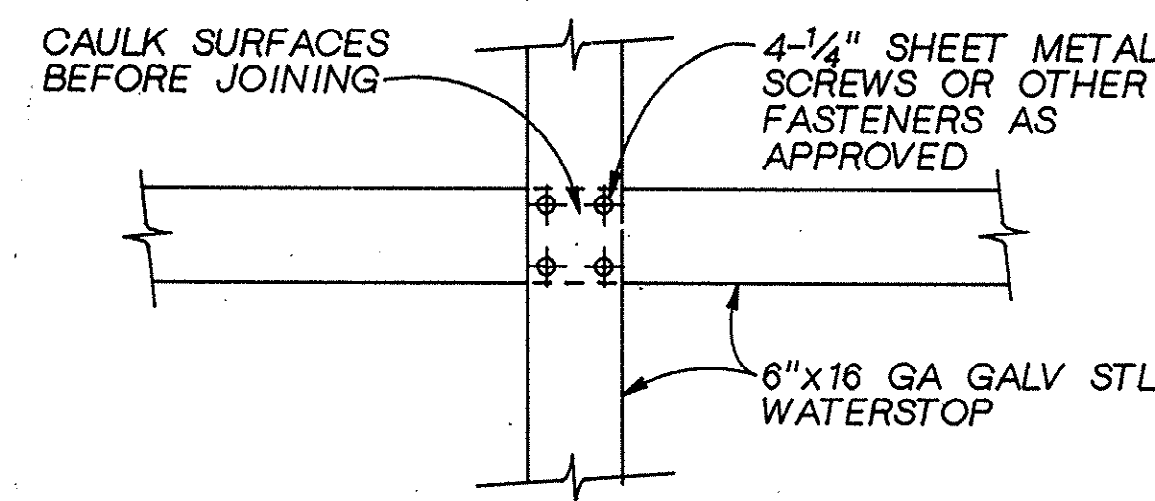


STEEL-STEEL WS SPLICE

NTS

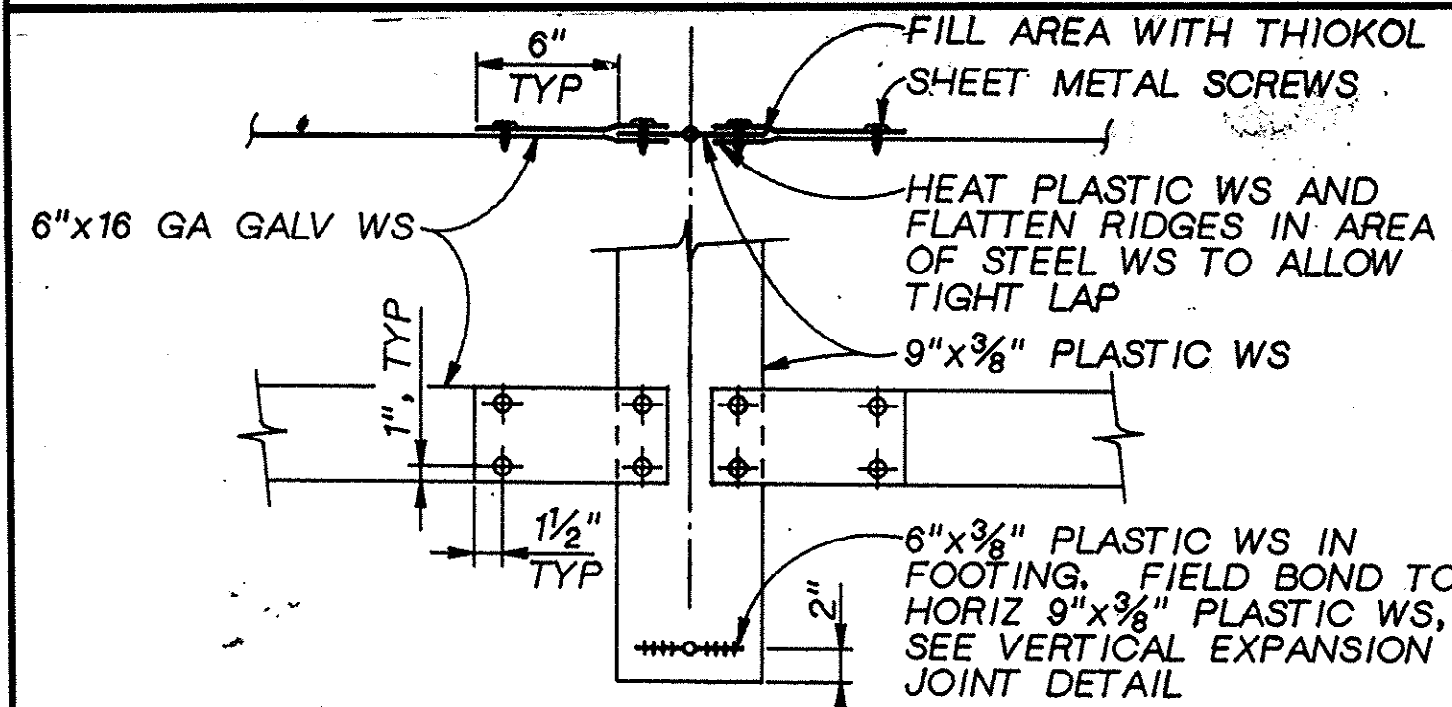


STEEL-PLASTIC WS SPLICE

NTS

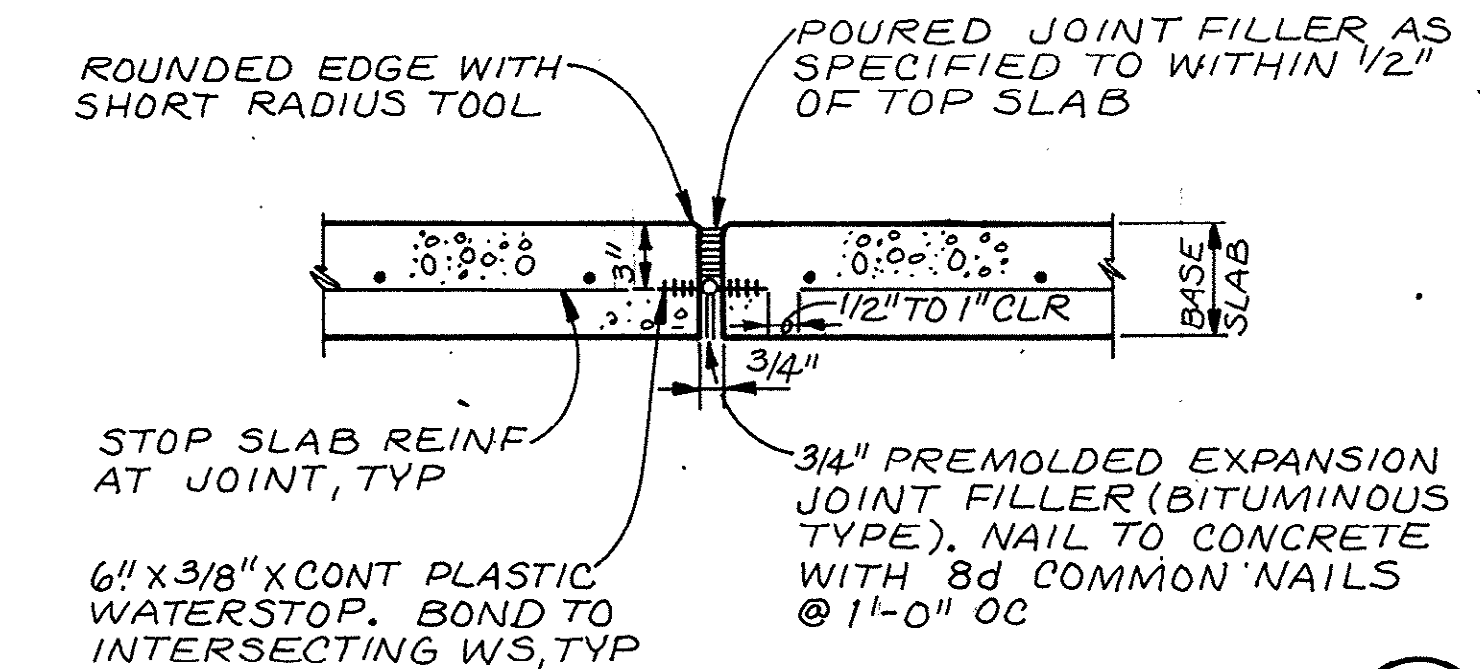


BASE SLAB EXPANSION JOINT

NTS

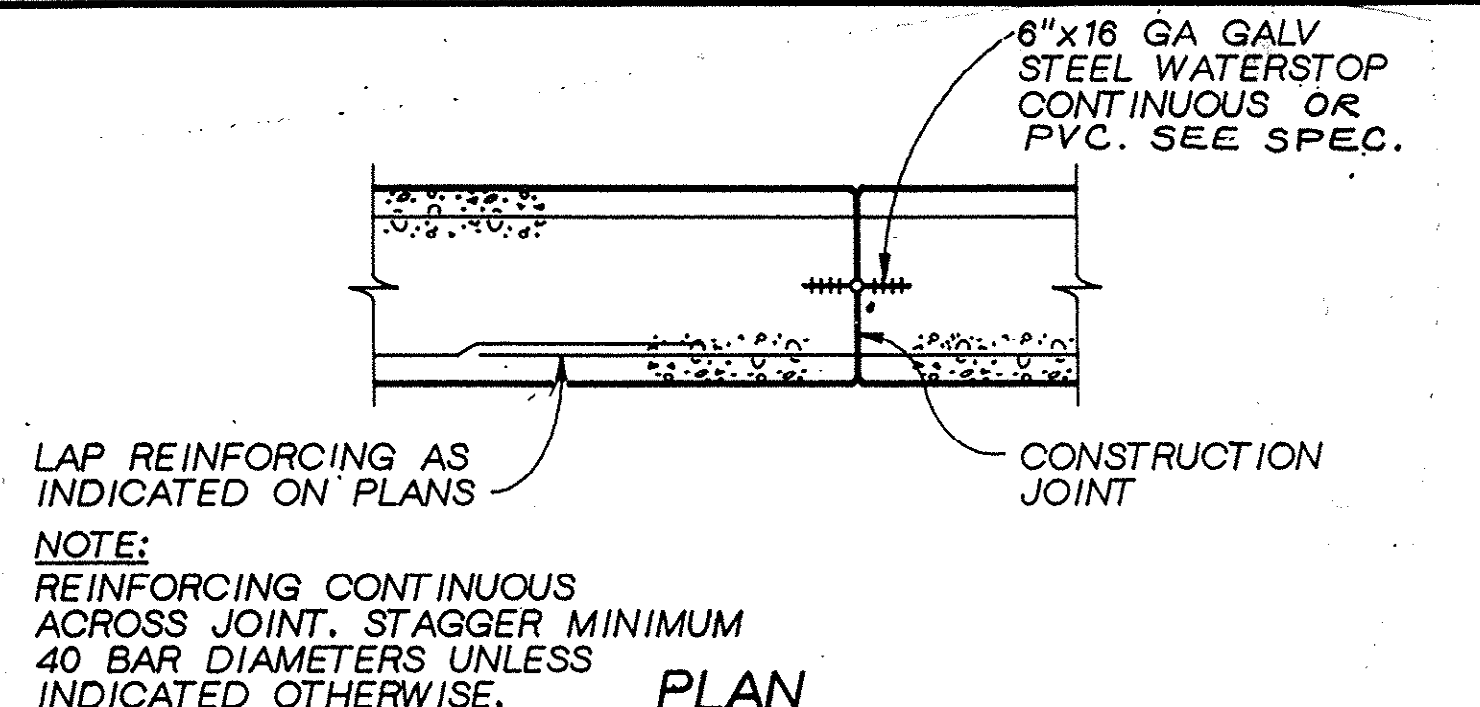


VERTICAL & BASE SLAB CONSTRUCTION JT.

NTS

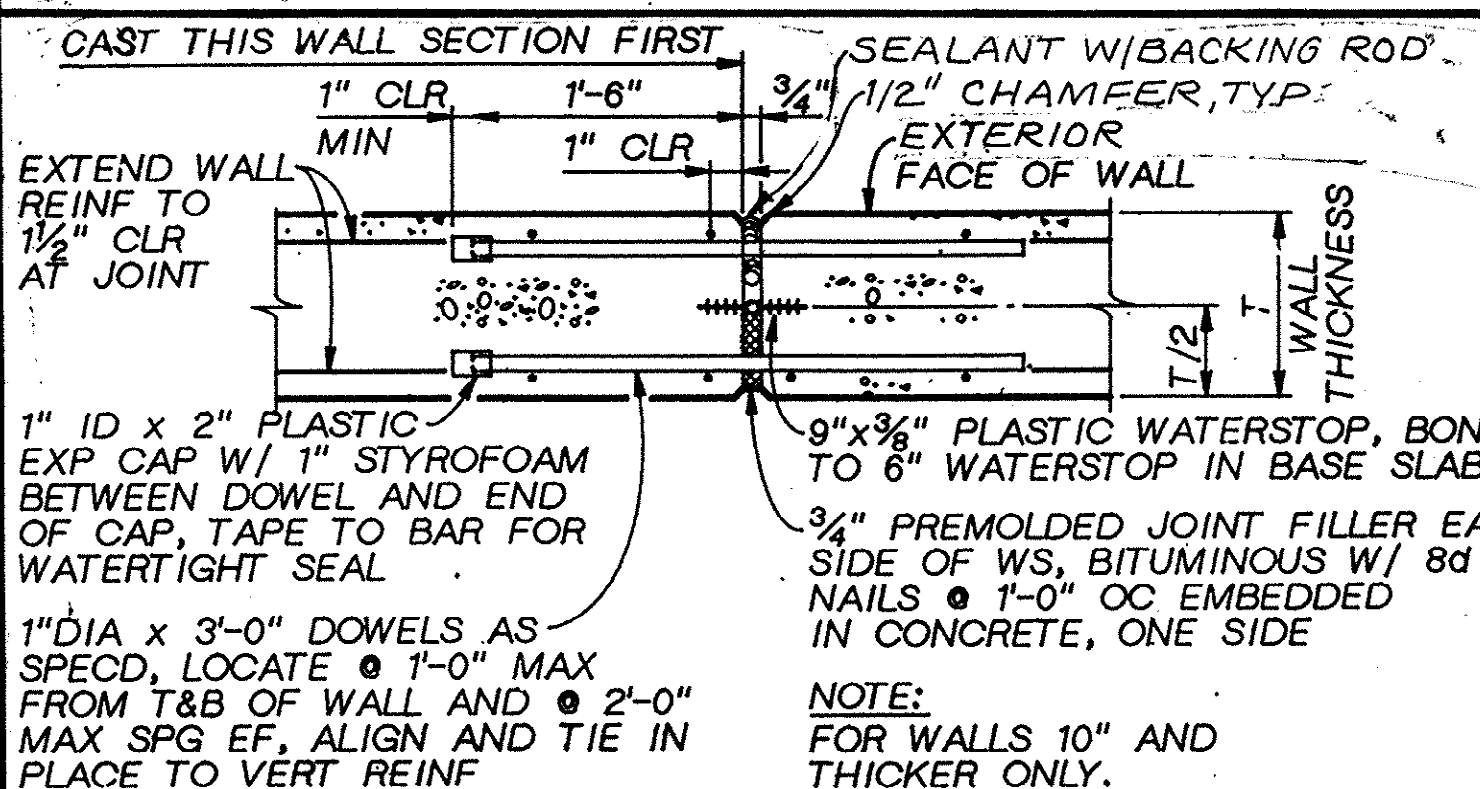


VERTICAL EXPANSION JOINT

NTS

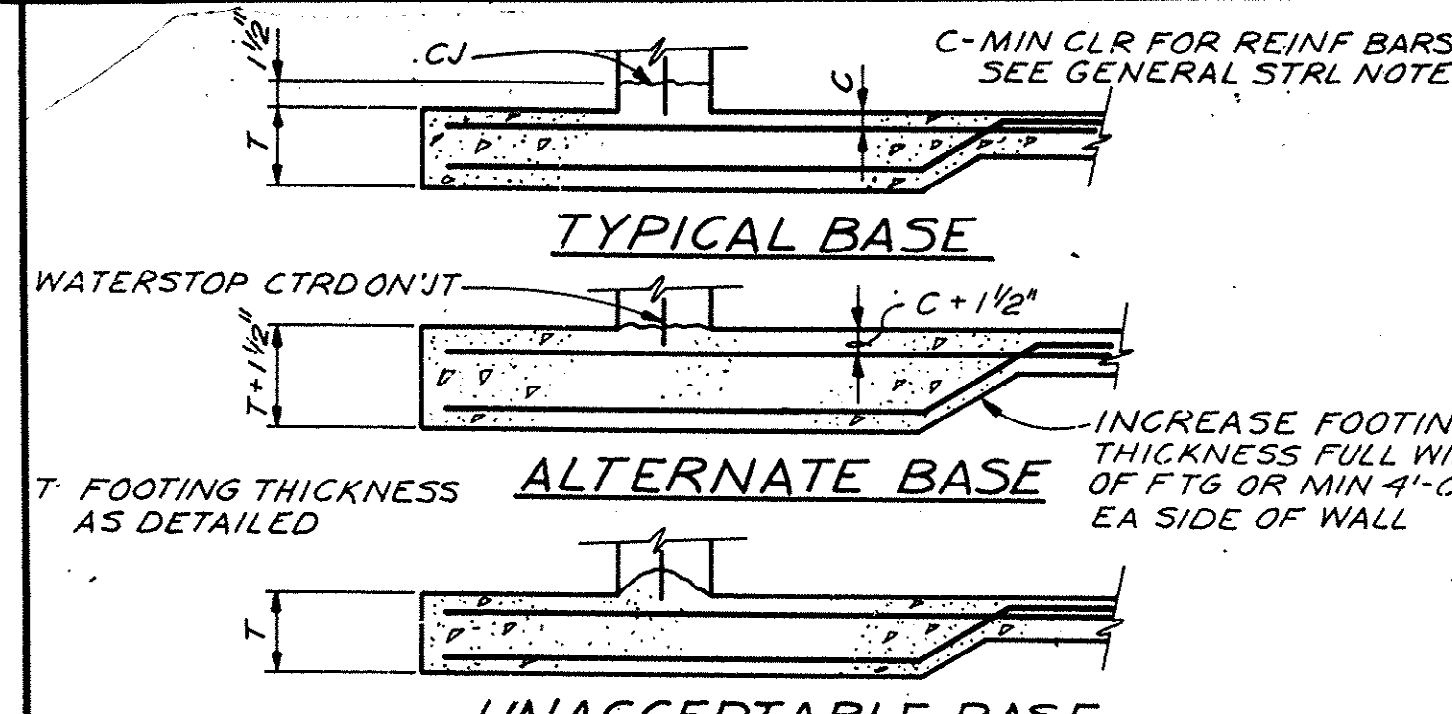

WALL BASE CONSTR JOINT

NTS

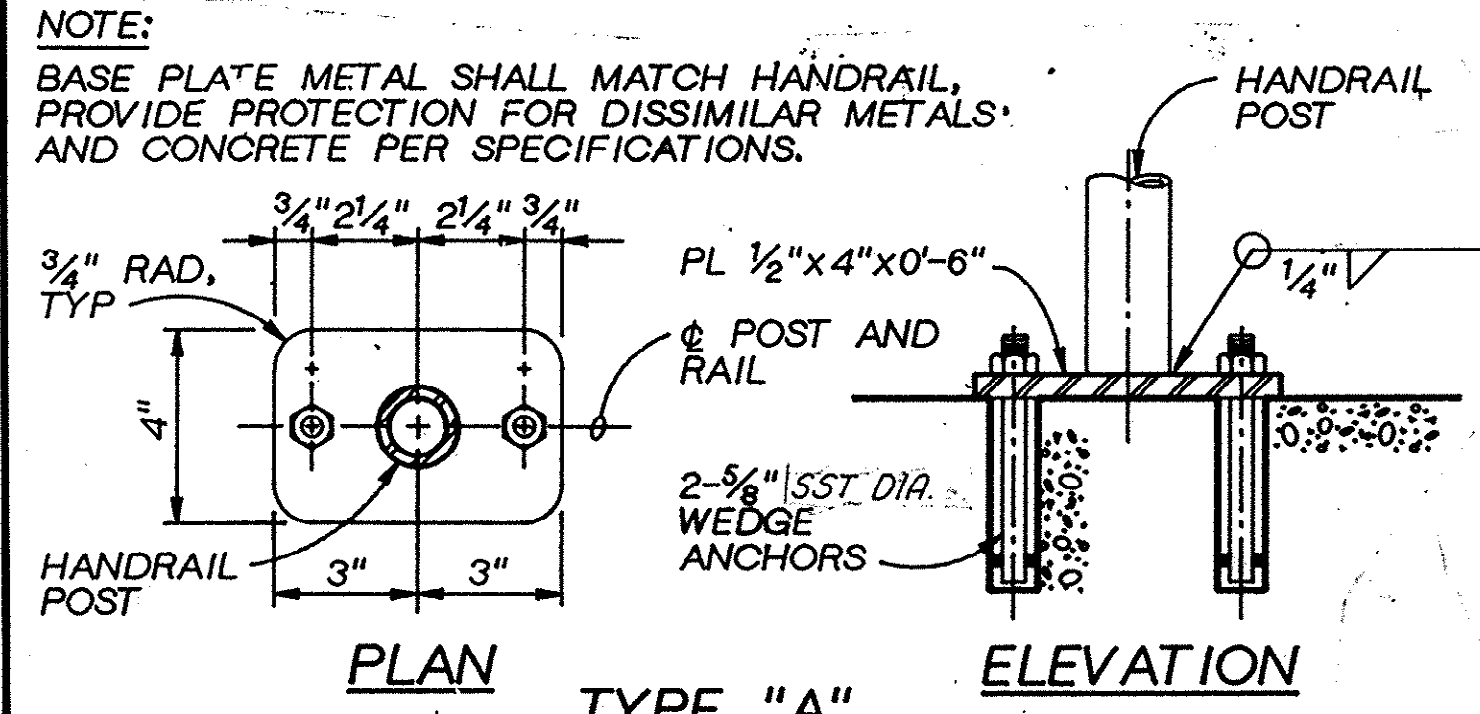

HANDRAIL POST ANCHORAGE

NTS

7-05-018-S

GENERAL STRUCTURAL NOTES

- UNLESS OTHERWISE SHOWN, CONC WALLS AND SLABS SHALL BE REINF AS FOLLOWS: #4@12" EW CENTER OF 6" SECTIONS; #5@12" EW CENTER OF 8" SECTIONS; #4@12" EW OF 10" SECTIONS; #5@12" EW OF 12" SECTIONS. SINGLE MAT REINF SHALL BE AT CENTER OF SECTION, UNLESS SHOWN OTHERWISE.
- MIN CLR FOR REINF BARS, UNLESS SHOWN OTHERWISE, SHALL BE 3" WHEN PLACED ON GROUND; FOR SURFACES EXPOSED TO WATER OR WEATHER 1 1/2" CLR FOR #6 BAR AND SMALLER AND 2" CLR FOR LARGER BARS; INTERIOR SLABS 3/4" CLR, INTERIOR BEAMS 1 1/2" CLR.
- REFER TO WALL CORNER AND WALL INTERSECTION REINFORCING DETAIL. IN GENERAL, THE WALL CORNER REINFORCING SIZES AND SPACINGS SHALL BE CALLED OUT ON THE PLANS AND REFERENCED TO THESE DETAILS AND THE TYPICAL HORIZONTAL WALL REINFORCING SHALL LAP WITH THE HORIZONTAL REINFORCING.
- ALL BENDS, UNLESS OTHERWISE SHOWN, SHALL BE A 90° DEGREE STANDARD HOOK AS DEFINED IN LATEST EDITION OF ACI 318.
- UNLESS OTHERWISE NOTED, ALL WALL REINF BARS SHALL BE CONT AROUND CORNERS AND THROUGH COL OR PILASTERS. REINF SHALL BE EXTENDED INTO CONNECTING WALLS AND LAPPED ON THE OPPOSITE FACE OF THE CONNECTING WALLS, AS INDICATED ELSEWHERE ON THIS SHEET. VERT WALL BARS SHALL BE LAPPED WITH DOWELS FROM BASE SLABS AND EXTENDED INTO THE TOP FACE OF ROOF SLABS AND LAPPED WITH TOP SLAB REINF. UNLESS INDICATED OTHERWISE, CONTRACTOR MAY SPICE CONTINUOUS SLAB OR LONGITUDINAL BEAM BARS AT LOCATIONS OF HIS CHOOSING, EXCEPT THAT TOP BAR SPLICES SHALL BE LOCATED AT MIDSPAN AND BOTTOM BAR SPLICES SHALL BE LOCATED AT SUPPORTS. ALL REINF BENDS AND LAPS, UNLESS OTHERWISE NOTED, SHALL SATISFY THE FOLLOWING MINIMUM REQUIREMENT:

200

201

202

203

204

205

206


207

208

209

210

211

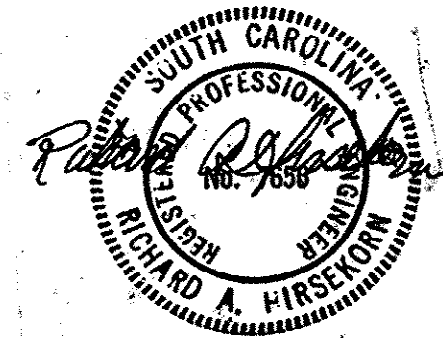

DSGN V. BATES/J. MAXFIELD
DR K. ANDERSEN
CHK T. L. BELSER
APVD R. A. HIRSCHER

NO. DATE

REVISION

BY

APVD

©CH2M HILL

REUSE OF DOCUMENTS

THIS DOCUMENT, AND THE IDEAS AND DESIGNS INCORPORATED HEREIN, AS AN INSTRUMENT OF PROFESSIONAL SERVICE, IS THE PROPERTY OF CH2M HILL AND IS NOT TO BE USED, IN WHOLE OR IN PART, FOR ANY OTHER PROJECT WITHOUT THE WRITTEN AUTHORIZATION OF CH2M HILL.

VERIFY SCALES

BAR IS ONE INCH ON ORIGINAL DRAWING.

IF NOT ONE INCH ON THIS SHEET, ADJUST SCALES ACCORDINGLY.

MODIFICATIONS TO THE

J. LAMBERT SCHWARTZ WWTP

THE GRAND STRAND

WATER AND SEWER AUTHORITY

STRUCTURAL STANDARD DETAILS

DWG. NO. **D-1**
DATE **AUG 1985**
PROJ. NO. **SA19793.AG**

